


62583

LEGEND

- HIGH MAST LIGHT TOWER.
- 400 W. HPS LUMINAIRE (BLACK PHASE-SOLID SYMBOL, RED PHASE-OPEN SYMBOL)
- HIGH MAST TOWER DESIGNATION.
- LIGHTED SIGN STRUCTURE WITH 170 W. FLUORESCENT LUMINAIRE, QUANTITY OF LUMINAIRE AS REQUIRED. (BLACK PHASE-SOLID SYMBOL, RED PHASE, OPEN SYMBOL)
- 3 POLE SAFETY SWITCH
- UNDERPASS LIGHTING UNIT, 70W HPS LUMINAIRE, UNLESS NOTED OTHERWISE. (BLACK PHASE- SOLID SYMBOL, RED PHASE-OPEN SYMBOL)
- LIGHTING CONTROLLER
- GROUND FIELD
- ELECTRIC UTILITY SERVICE
- CLOSED CIRCUIT TELEVISION CAMERA

CIRCUIT	RED PHASE		BLACK PHASE		
	AMPS	WATTS	AMPS	WATTS	
A	19.4	4,656	B	21.3	5,112
C	31.7	7,608	D	30.8	7,392
E	21.9	5,256	F	24.7	5,928
G	10.6	2,544	H	8.7	2,088
I	15.9	3,816	J	15.9	3,816
K	27.1	6,504	L	27.1	6,504
M	-	-	N	-	-
O	-	-	P	-	-
TOTAL	126.6	30,384	TOTAL	128.5	30,840

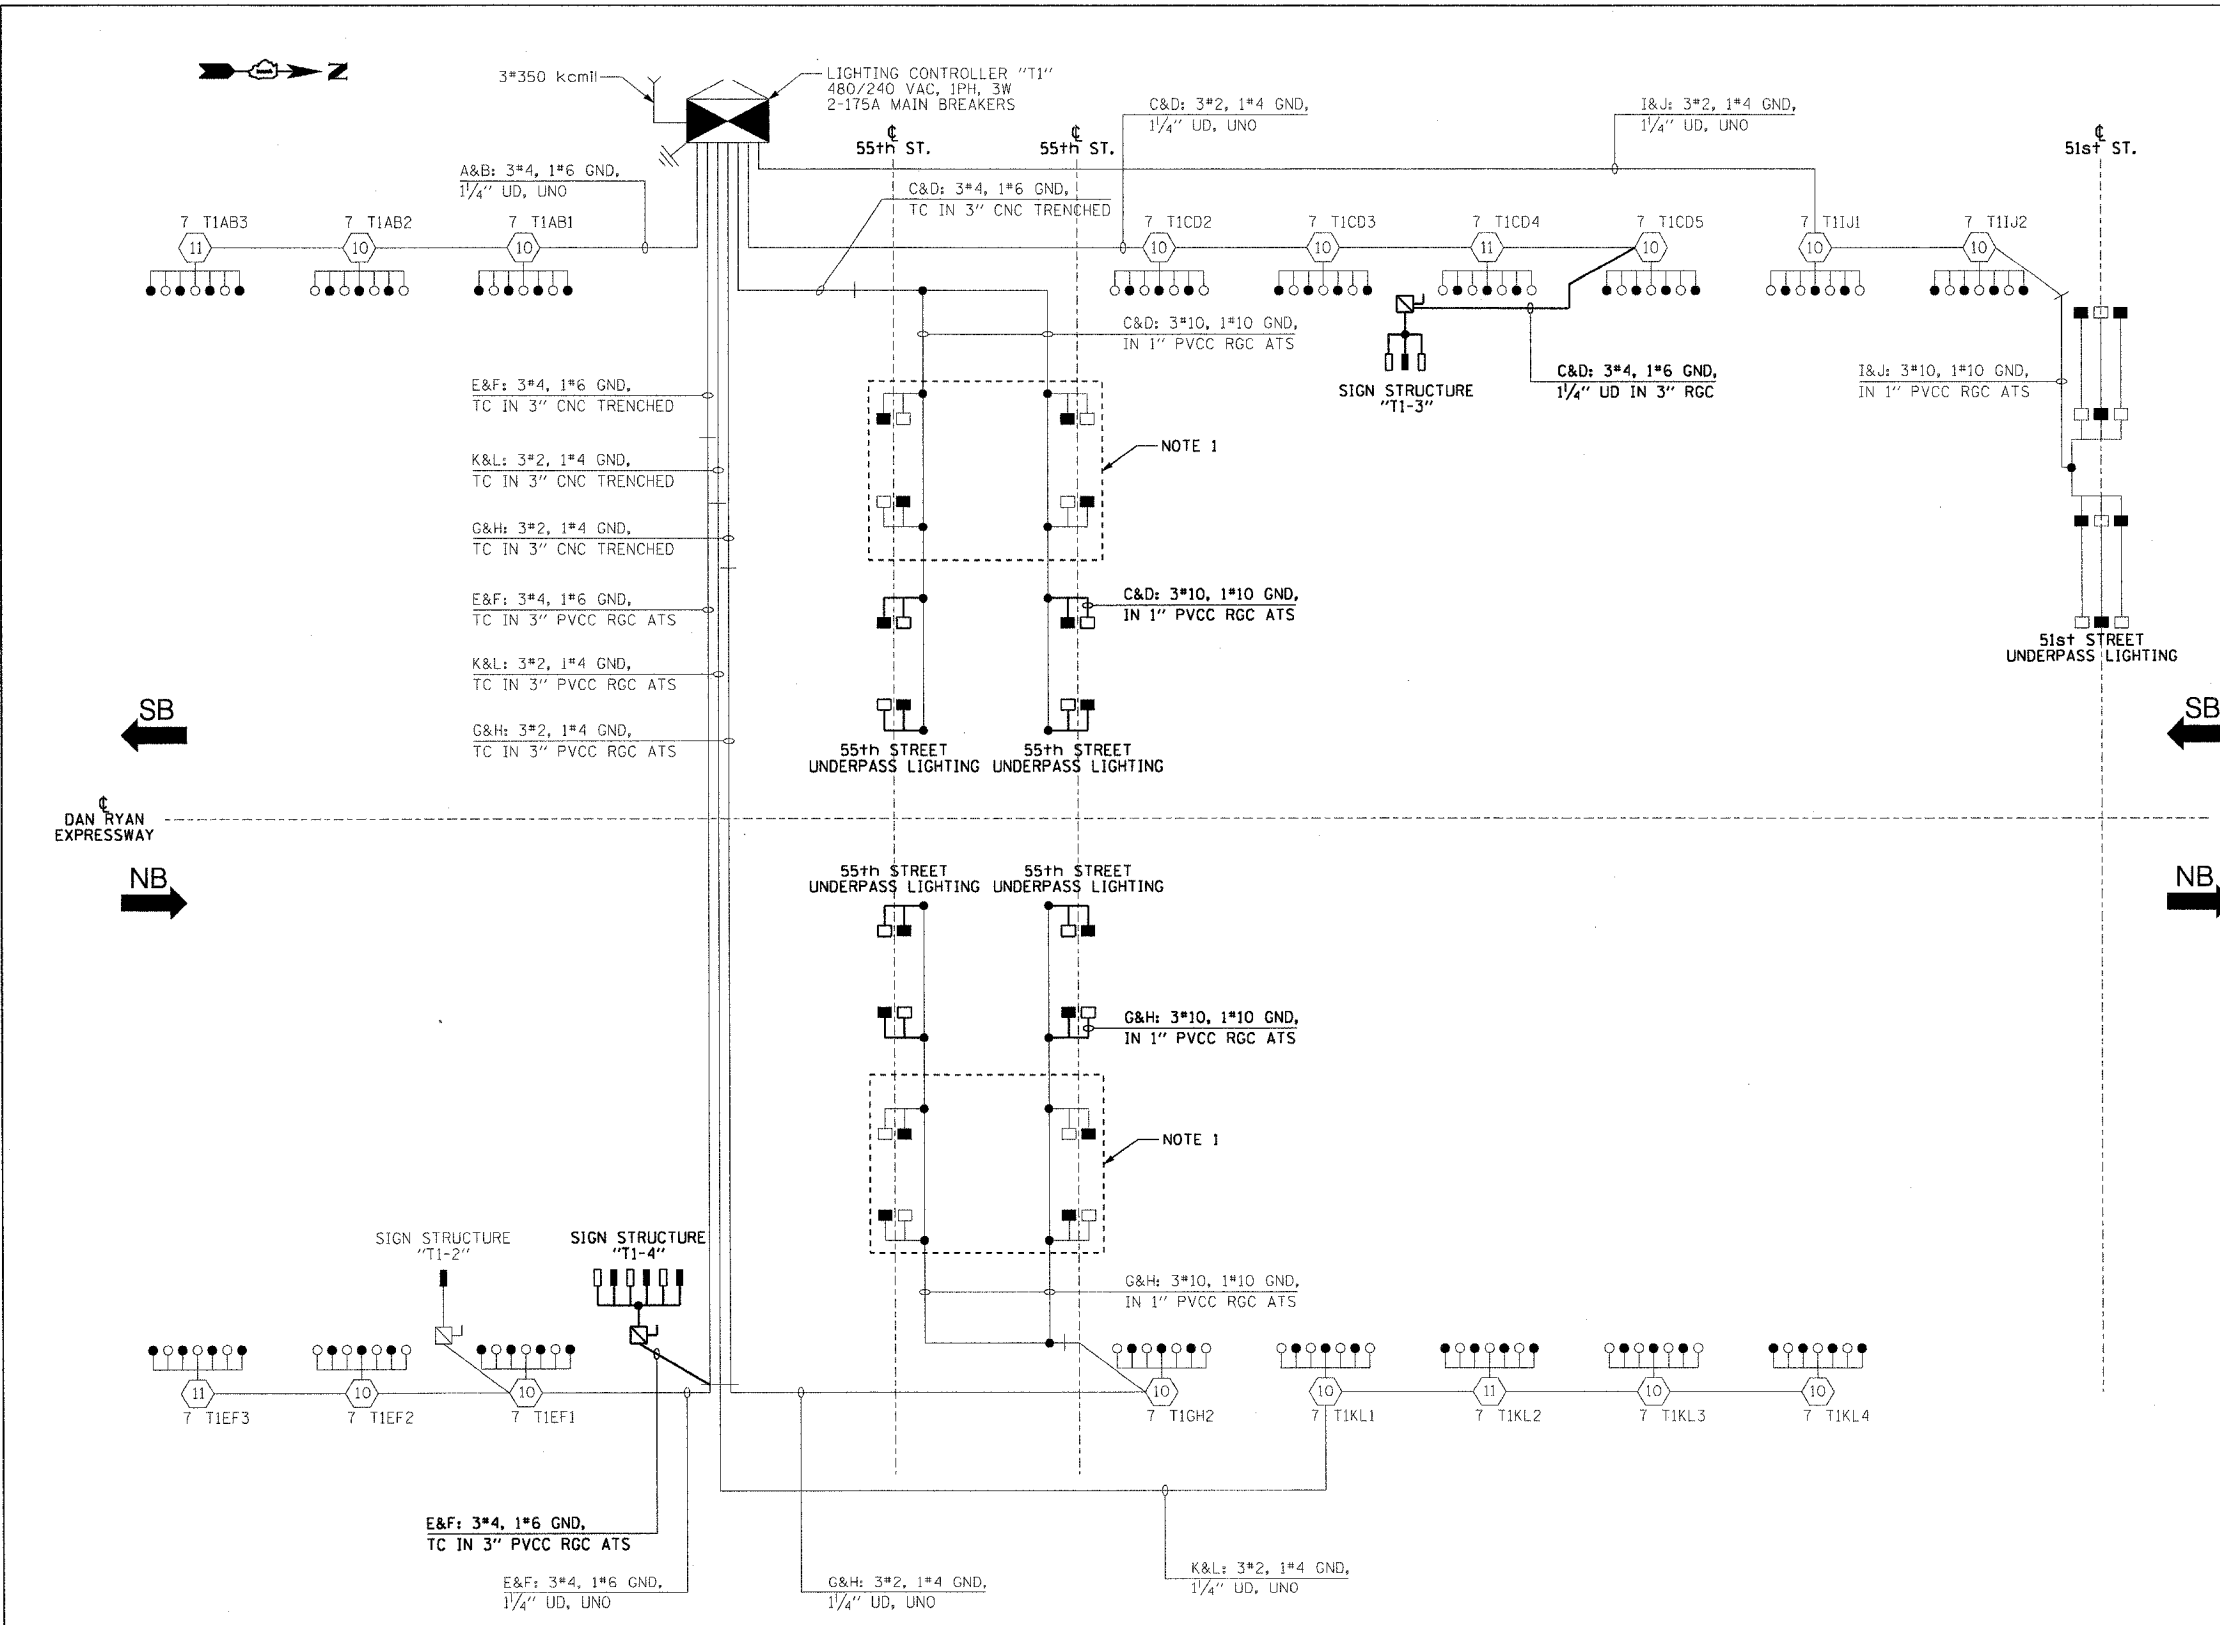

**SINGLE LINE DIAGRAM
LIGHTING CONTROLLER "T1"**
NOT TO SCALE

- NOTES:**
- EXISTING UNDERPASS LIGHTING UNITS, 55 WATT LPS LUMINAIRE. (BLACK PHASE-SOLID SYMBOL, RED PHASE-OPEN SYMBOL)
 - UNLESS NOTED OTHERWISE, ALL ITEMS AND WORK SHOWN IN HEAVY LINE WEIGHT ON THIS DRAWING ARE PROPOSED ITEMS AND WORK.

REVISIONS	
NAME	DATE

ILLINOIS DEPARTMENT OF TRANSPORTATION
F.A.I. 90/94 (DAN RYAN EXPRESSWAY)
31st STREET TO I-57

**SINGLE LINE DIAGRAM
LIGHTING CONTROLLER "T1"
PROPOSED IMPROVEMENTS 2006**

SCALE: NOT TO SCALE DRAWN BY: CJM
DATE: October 29, 2004 CHECKED BY: WDS

10/15/2004 04:47:45 PM m:\p4046\elect\NG\ctrl\2006\sl06-09.ctb