
 


F.A.I. RTE. 90/94	SECTION 2003-0311	COUNTY COOK	TOTAL SHEETS 976	SHEET NO. 364
STA.		TO STA.		
FED. ROAD DIST. NO.	ILLINOIS FED. AID PROJECT		62583	

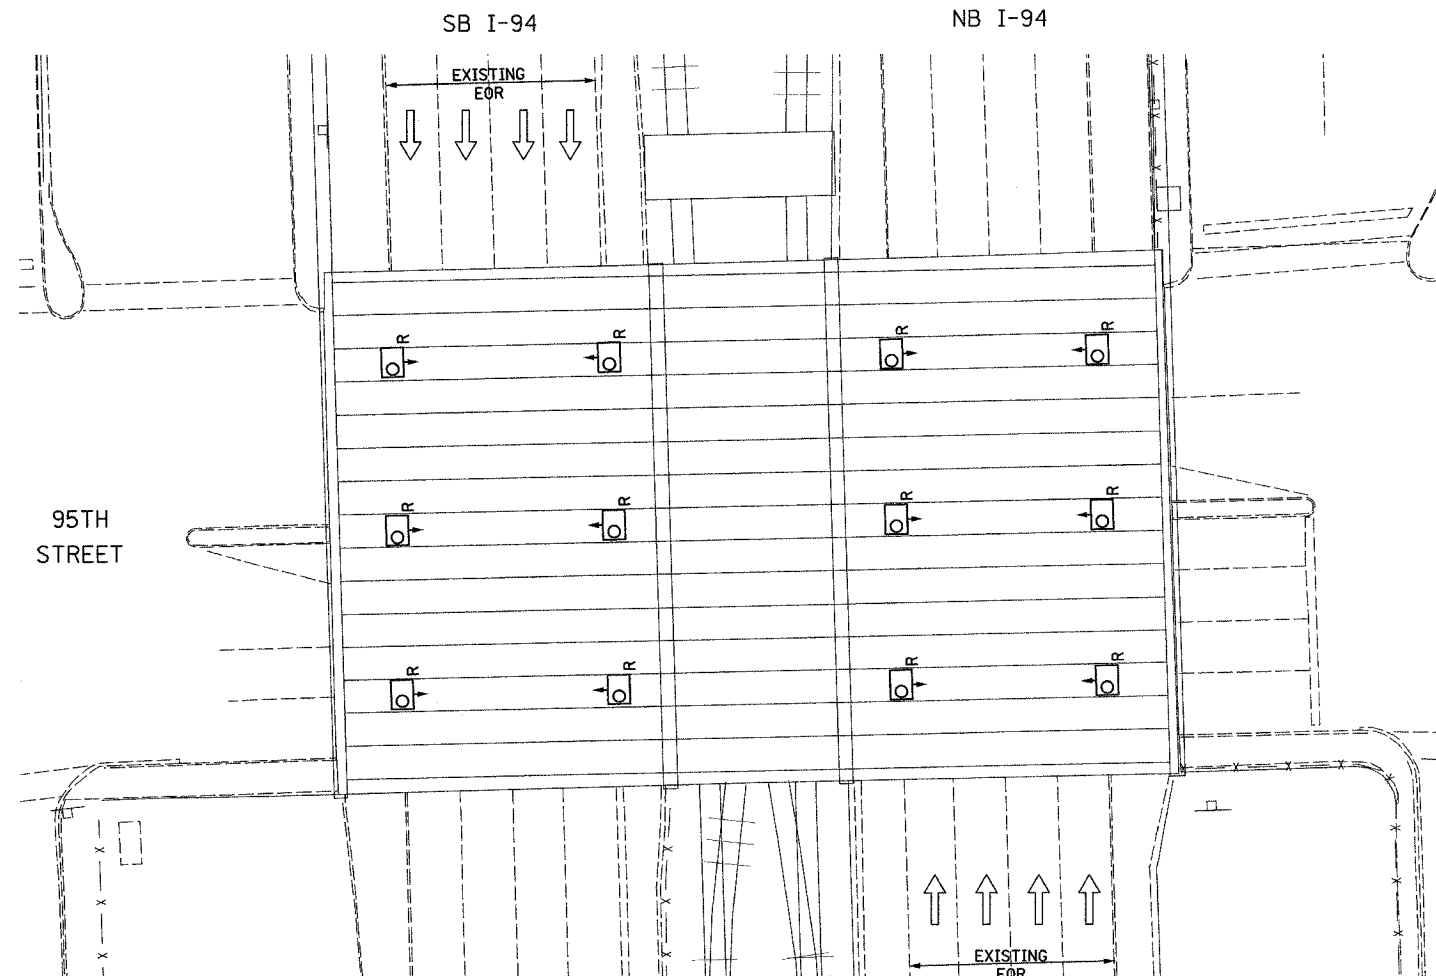

EXISTING UNDERPASS LIGHTING PLAN



UL-09

REVISIONS		ILLINOIS DEPARTMENT OF TRANSPORTATION F.A.I. 90/94 (DAN RYAN EXPRESSWAY) 31st STREET TO I-57
NAME	DATE	
		UNDERPASS LIGHTING PLANS 95TH STREET EXISTING CONDITIONS AND DEMOLITION SCALE: 1"=20' DATE: OCTOBER 29, 2004
DRAWN BY: VG		CHECKED BY: TM

SINGH 300 W. ADAMS ST.
CHICAGO, IL 60606
SINGH & ASSOCIATES, INC. TEL: (312) 629-0240
CONSULTING ENGINEERS FAX: (312) 629-8449

10/15/2004 9:53:58 AM