



F.A.I. RTE.	SECTION	COUNTY	TOTAL SHEETS	SHEET NO.
90/94	2021-922PT.1-AC	COOK	460	87
STA. 118+00	TO STA. 123+00			
FED. ROAD DIST. NO. 1 ILLINOIS FED. AID PROJECT				
62693				

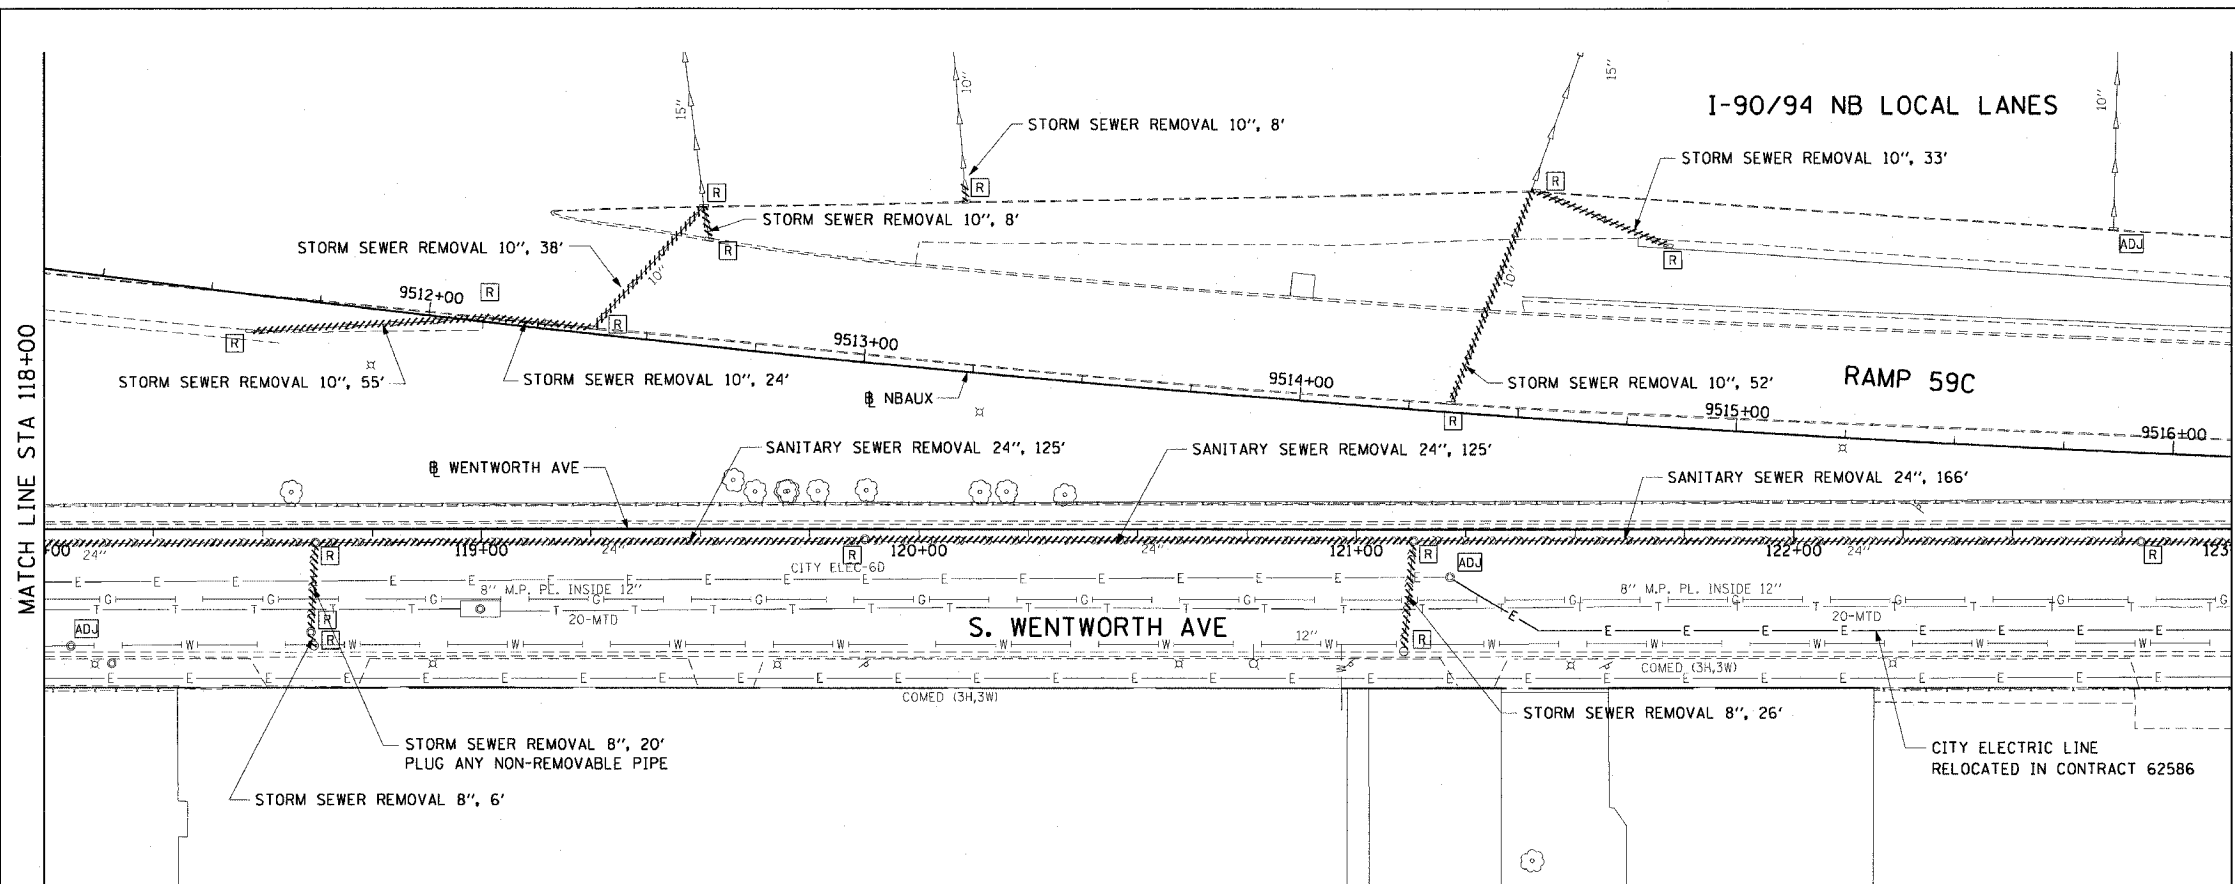

- LEGEND: EXISTING**
- INLET
  - CATCH BASIN
  - MANHOLE
  - STORM SEWER
  - COMBINED SEWER
  - PIPE UNDERDRAIN
  - [R] STRUCTURE TO BE REMOVED
  - [ADJ] STRUCTURE TO BE ADJUSTED
  - //// STORM SEWER REMOVAL OR ABANDON
  - //// COMBINED SEWER REMOVAL OR ABANDON

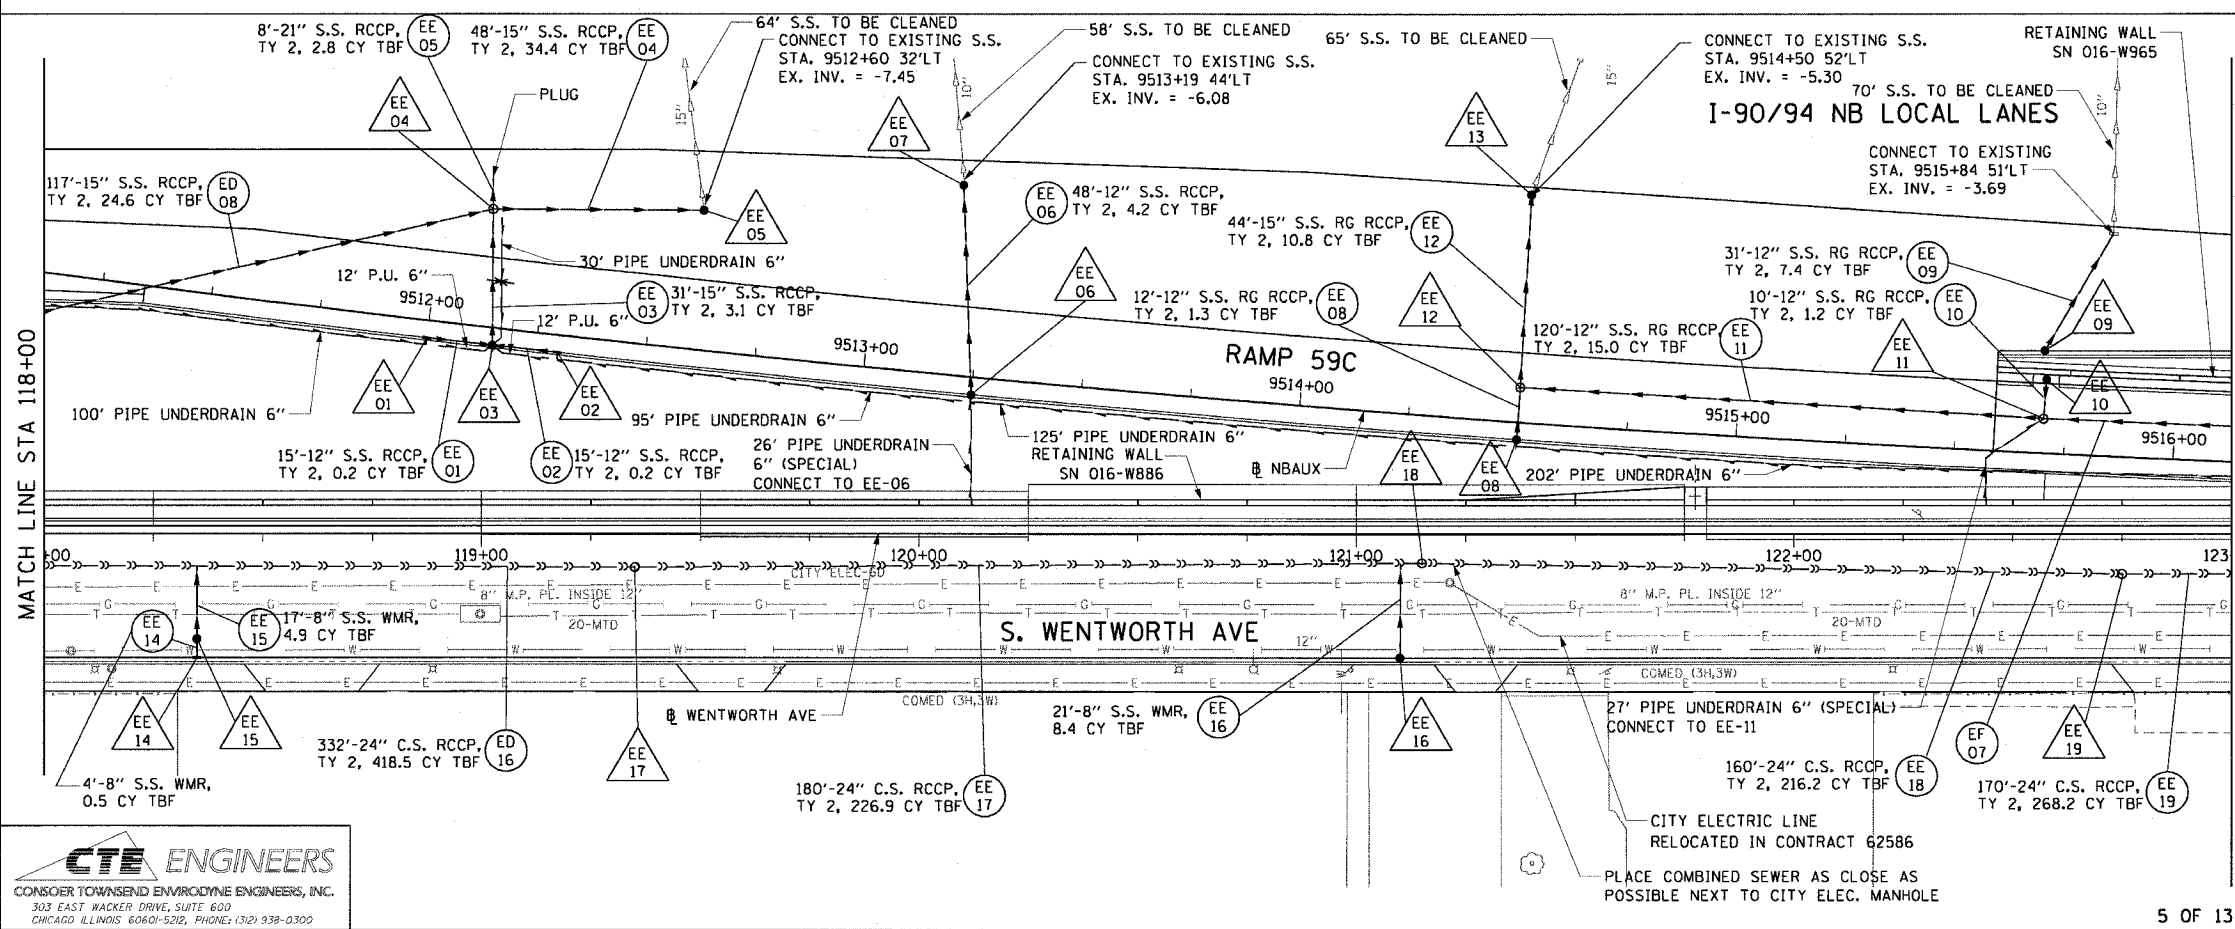

**EXISTING CONDITIONS AND REMOVAL**

- LEGEND: PROPOSED**
- INLET
  - CATCH BASIN
  - MANHOLE
  - STORM SEWER
  - COMBINED SEWER
  - PIPE UNDERDRAIN
  - PROPOSED SWALE
  - (EA 01) PROPOSED STORM SEWER PIPE
  - △ (EA 01) PROPOSED STRUCTURE
  - CITY ELECTRIC HANDHOLE

**NOTES:**  
1. SEE DRAINAGE SCHEDULES FOR STRUCTURE, PIPE AND UNDERDRAIN INFORMATION.

REVISIONS	NAME	DATE

ILLINOIS DEPARTMENT OF TRANSPORTATION  
F.A.I. 90/94 (DAN RYAN EXPRESSWAY)  
63rd ST TO 59th ST (FRONTAGE ROAD & RAMPS)

**DRAINAGE AND UTILITY PLANS  
WENTWORTH AVENUE**

SCALE: 1"=20'  
DATE: October 29, 2004

DRAWN BY: JB  
CHECKED BY: EY

11/22/2004 02:37:44 PM