



F.A.I. RTE.	SECTION	COUNTY	TOTAL SHEETS	SHEET NO.
90/94	2021-922PT.J-AC	COOK	460	90
STA. 506+50		TO STA. 511+50		
FED. ROAD DIST. NO. 1 ILLINOIS FED. AID PROJECT				

62693

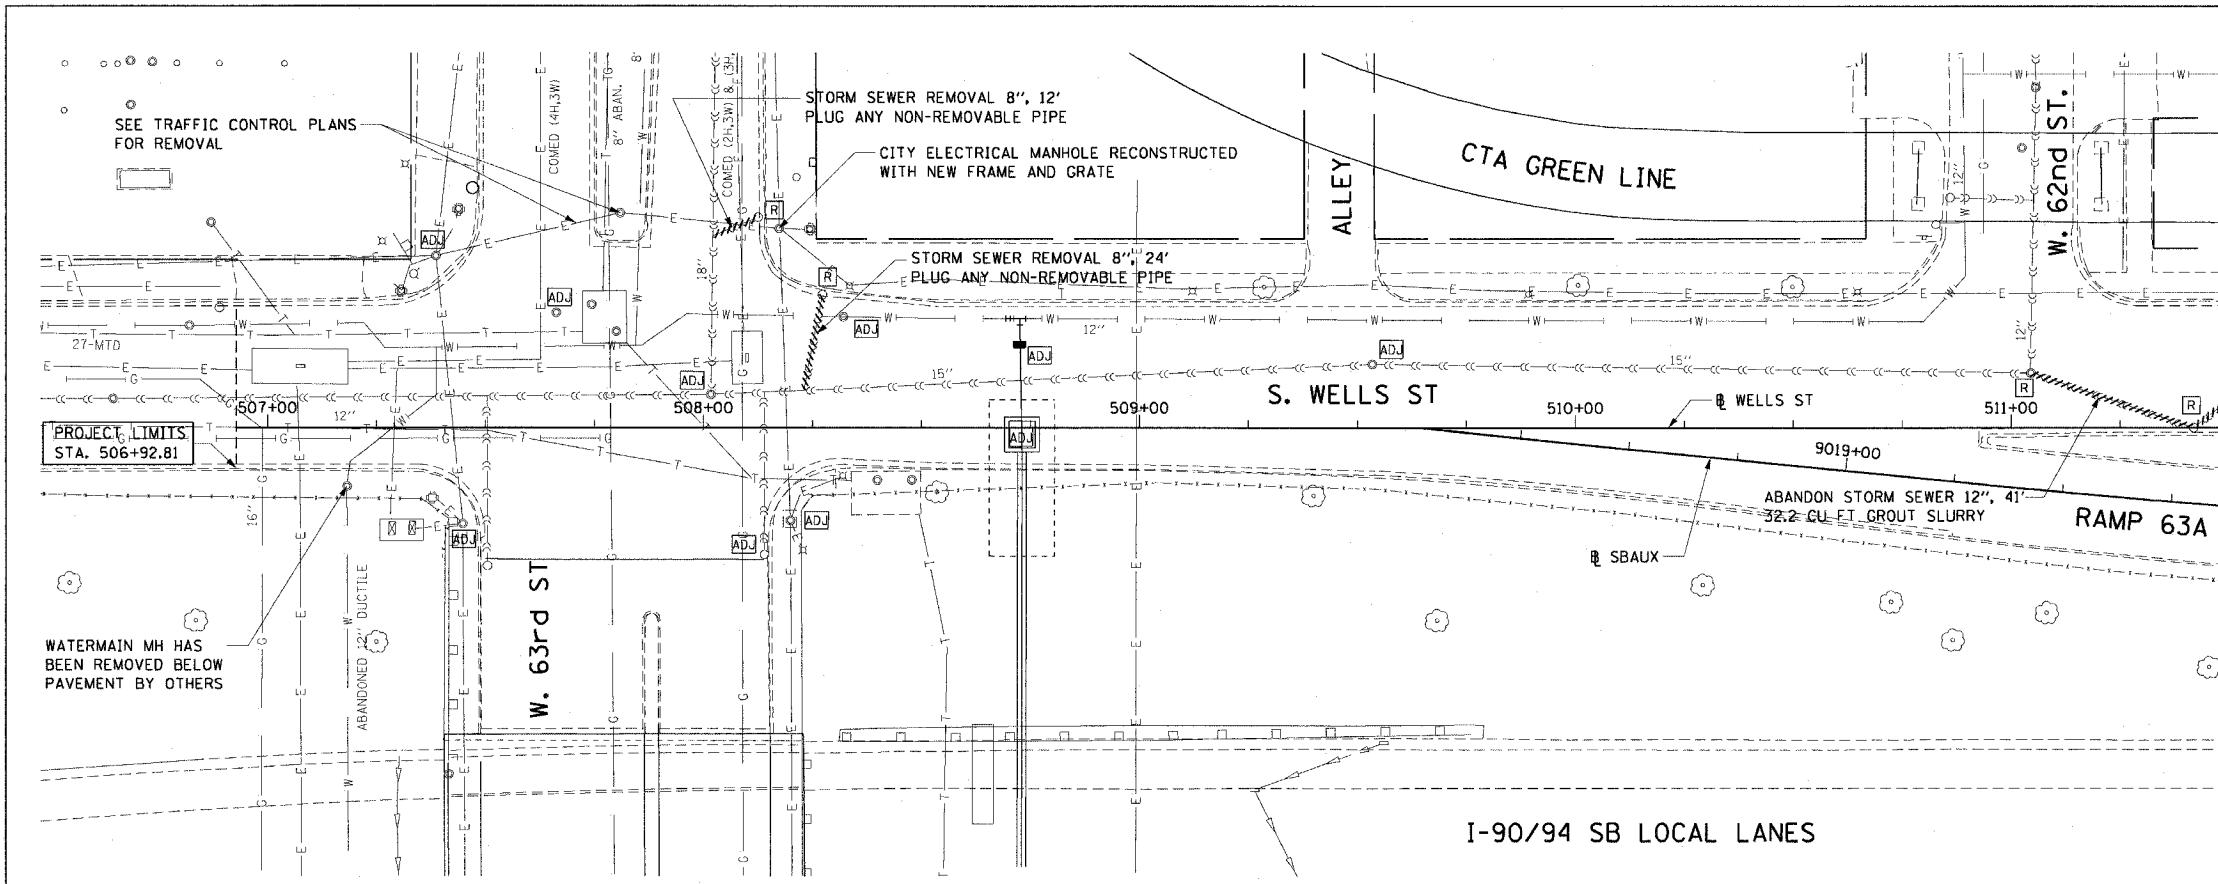

MATCH LINE STA 511+50

- LEGEND: EXISTING**
- INLET
 - CATCH BASIN
 - MANHOLE
 - STORM SEWER
 - COMBINED SEWER
 - PIPE UNDERDRAIN
 - [R] STRUCTURE TO BE REMOVED
 - [AD] STRUCTURE TO BE ADJUSTED
 - //// STORM SEWER REMOVAL OR ABANDON
 - //// COMBINED SEWER REMOVAL OR ABANDON

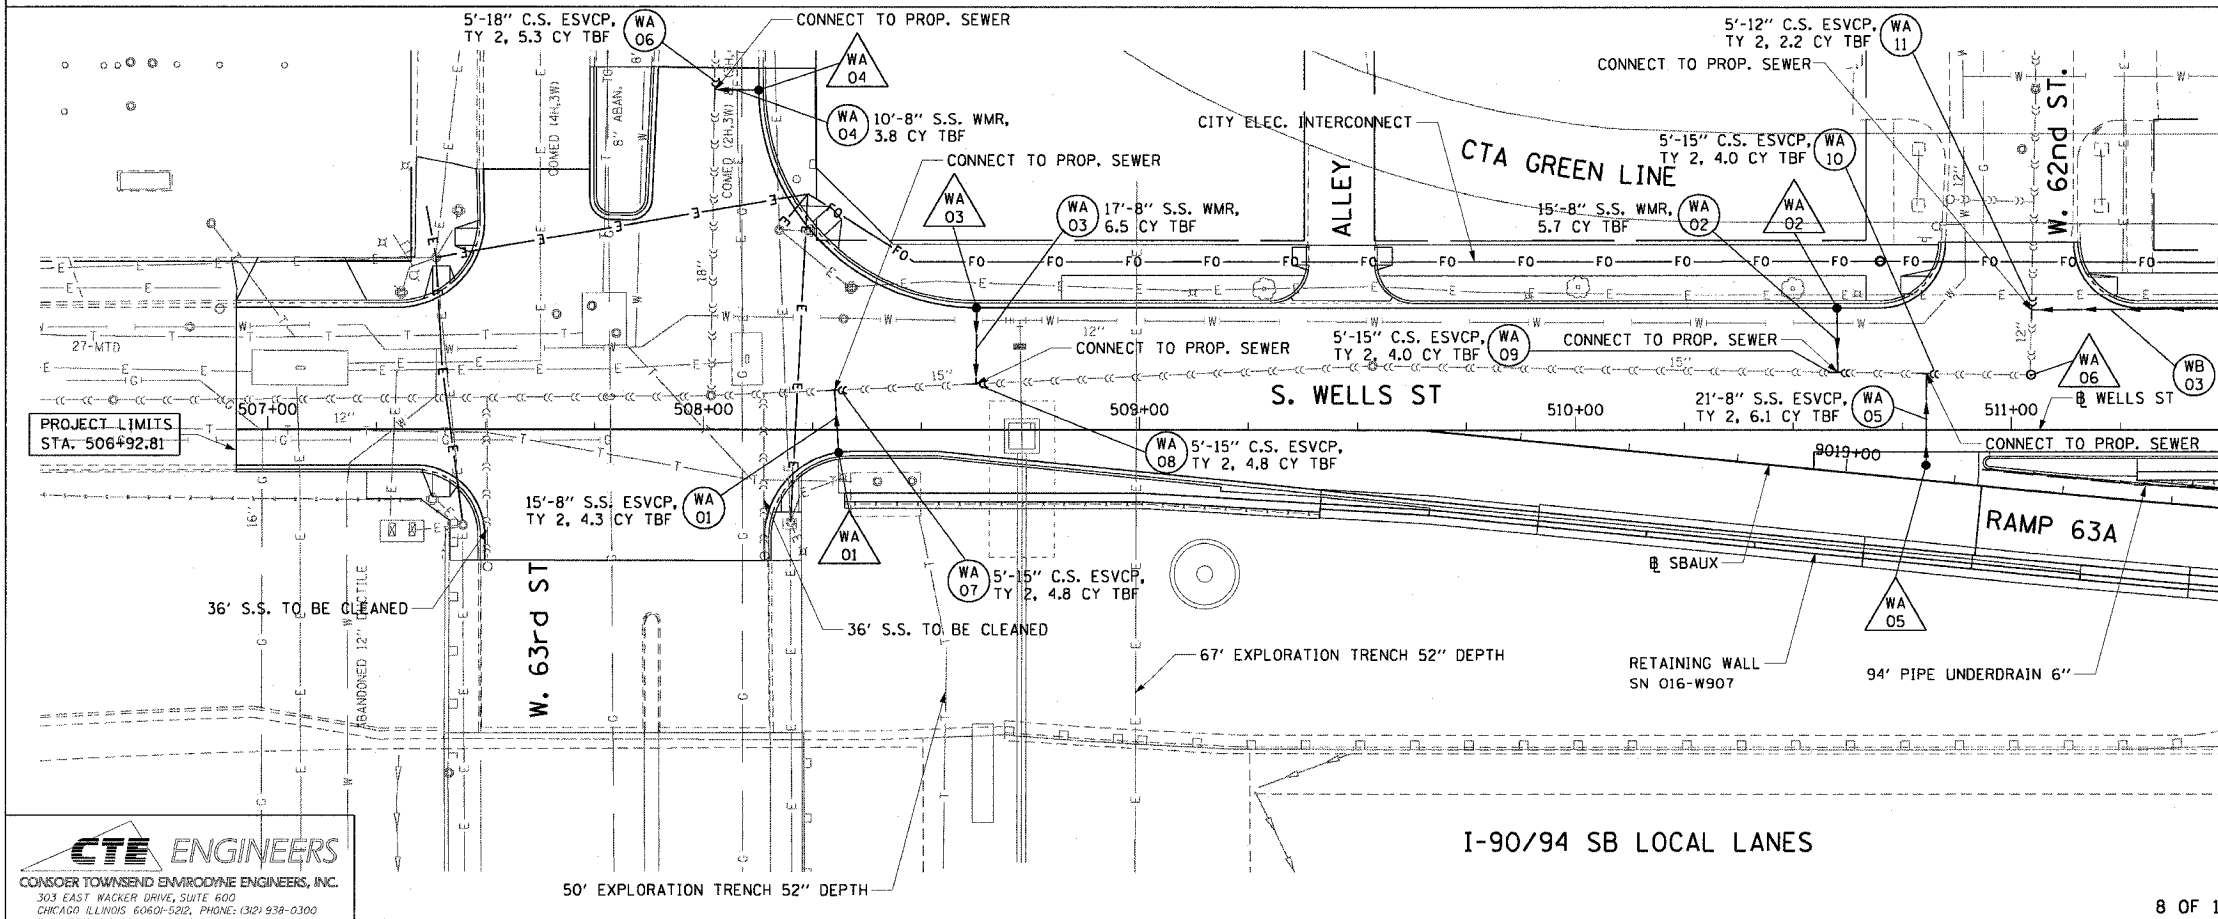

MATCH LINE STA 511+50

EXISTING CONDITIONS AND REMOVAL

- LEGEND: PROPOSED**
- INLET
 - CATCH BASIN
 - MANHOLE
 - STORM SEWER
 - COMBINED SEWER
 - PIPE UNDERDRAIN
 - PROPOSED SWALE
 - (EA 01) PROPOSED STORM SEWER PIPE
 - △(EA 01) PROPOSED STRUCTURE
 - CITY ELECTRIC HANDHOLE

- NOTES:**
- SEE DRAINAGE SCHEDULES FOR STRUCTURE, PIPE AND UNDERDRAIN INFORMATION.
 - SEE INTERCONNECT CONDUIT PLANS FOR CITY ELECTRIC INTERCONNECT IMPROVEMENTS.

REVISIONS	
NAME	DATE

ILLINOIS DEPARTMENT OF TRANSPORTATION
 F.A.I. 90/94 (DAN RYAN EXPRESSWAY)
 63rd ST TO 59th ST (FRONTAGE ROAD & RAMPS)

**DRAINAGE AND UTILITY PLANS
 WELLS STREET**

SCALE: 1"=20'
 DATE: October 29, 2004

DRAWN BY: JB
 CHECKED BY: EY

CTE ENGINEERS
 CONSOER TOWNSEND ENVIRONMENTAL ENGINEERS, INC.
 303 EAST WACKER DRIVE, SUITE 600
 CHICAGO, ILLINOIS 60601-5202, PHONE: (312) 938-0300

1/1/2004 02:38:07 PM