



F.A.I. RTE.	SECTION	COUNTY	TOTAL SHEETS	SHEET NO.
90/94	2021-922PT.1-AC	COOK	460	94
STA.	TO STA.			
FED. ROAD DIST. NO. 1	ILLINOIS	FED. AID PROJECT		
62693				

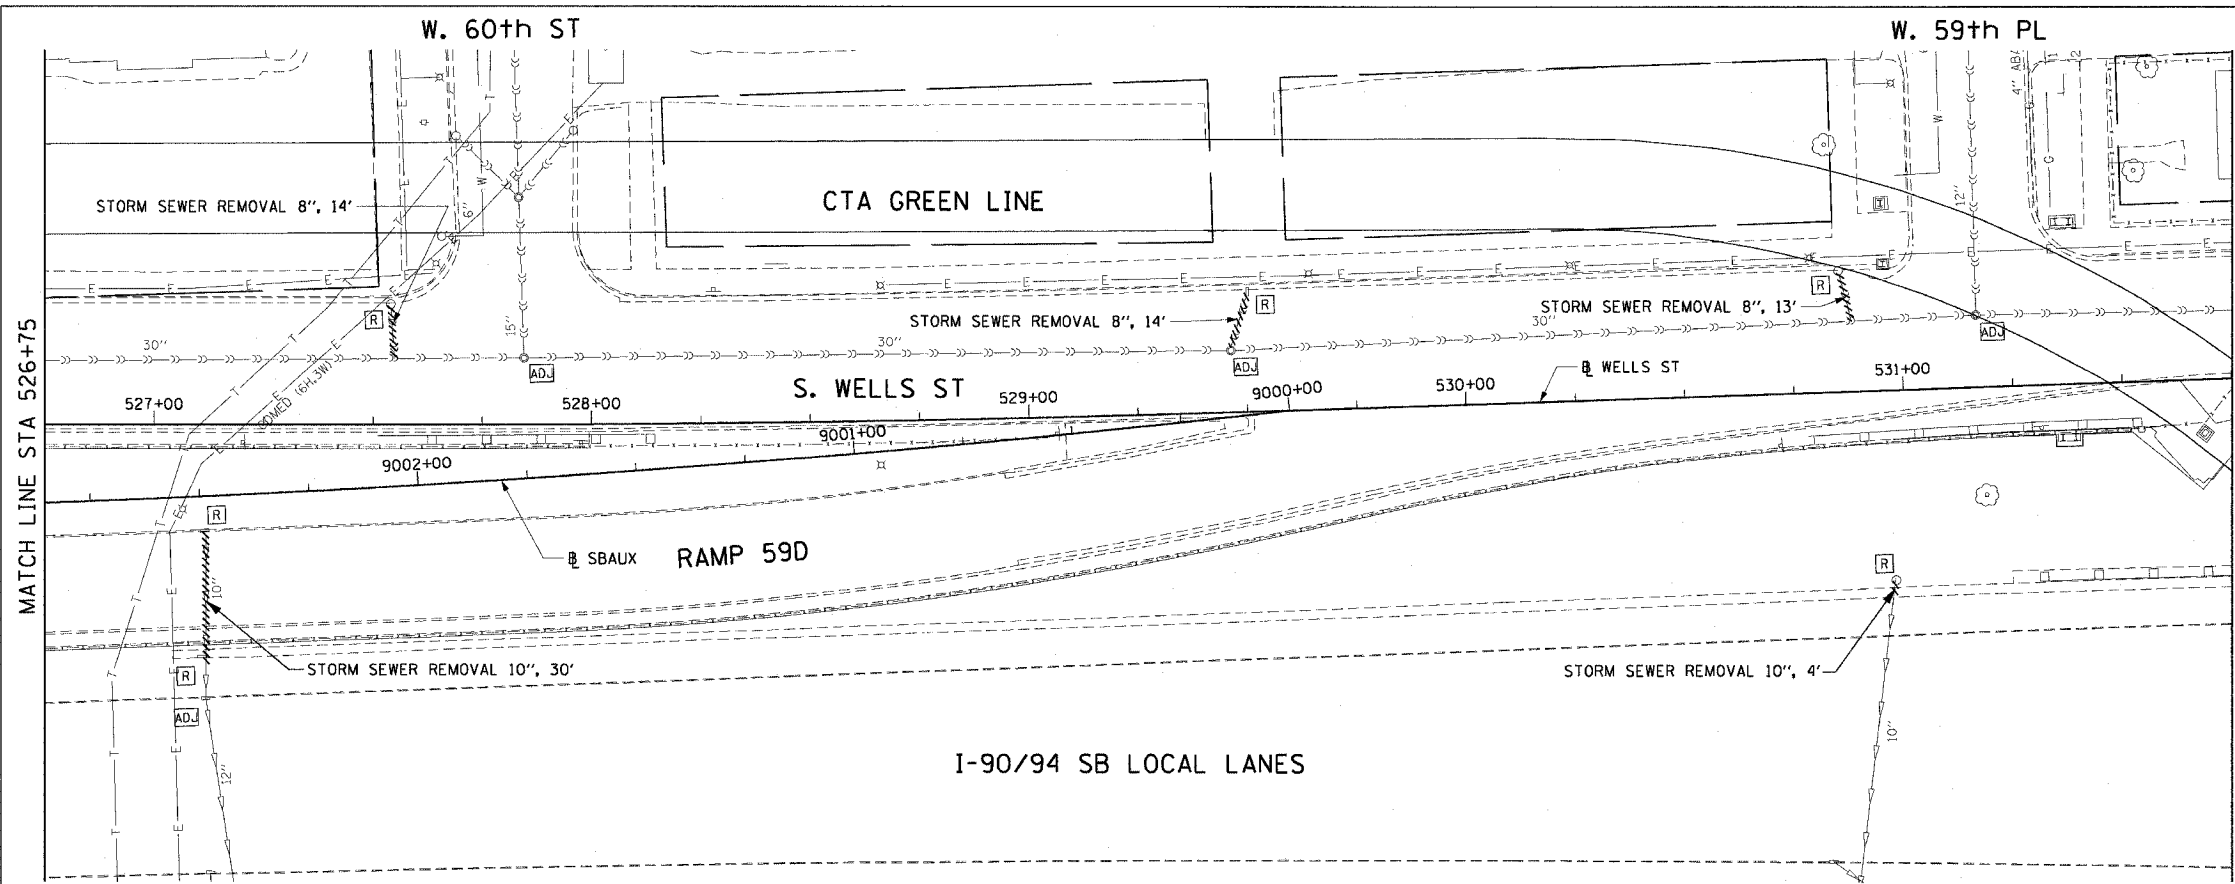

- LEGEND: EXISTING**
- INLET
 - o CATCH BASIN
 - o MANHOLE
 - STORM SEWER
 - COMBINED SEWER
 - PIPE UNDERDRAIN
 - [R] STRUCTURE TO BE REMOVED
 - [AD] STRUCTURE TO BE ADJUSTED
 - //// STORM SEWER REMOVAL OR ABANDON
 - //// COMBINED SEWER REMOVAL OR ABANDON

EXISTING CONDITIONS AND REMOVAL
PROPOSED IMPROVEMENTS

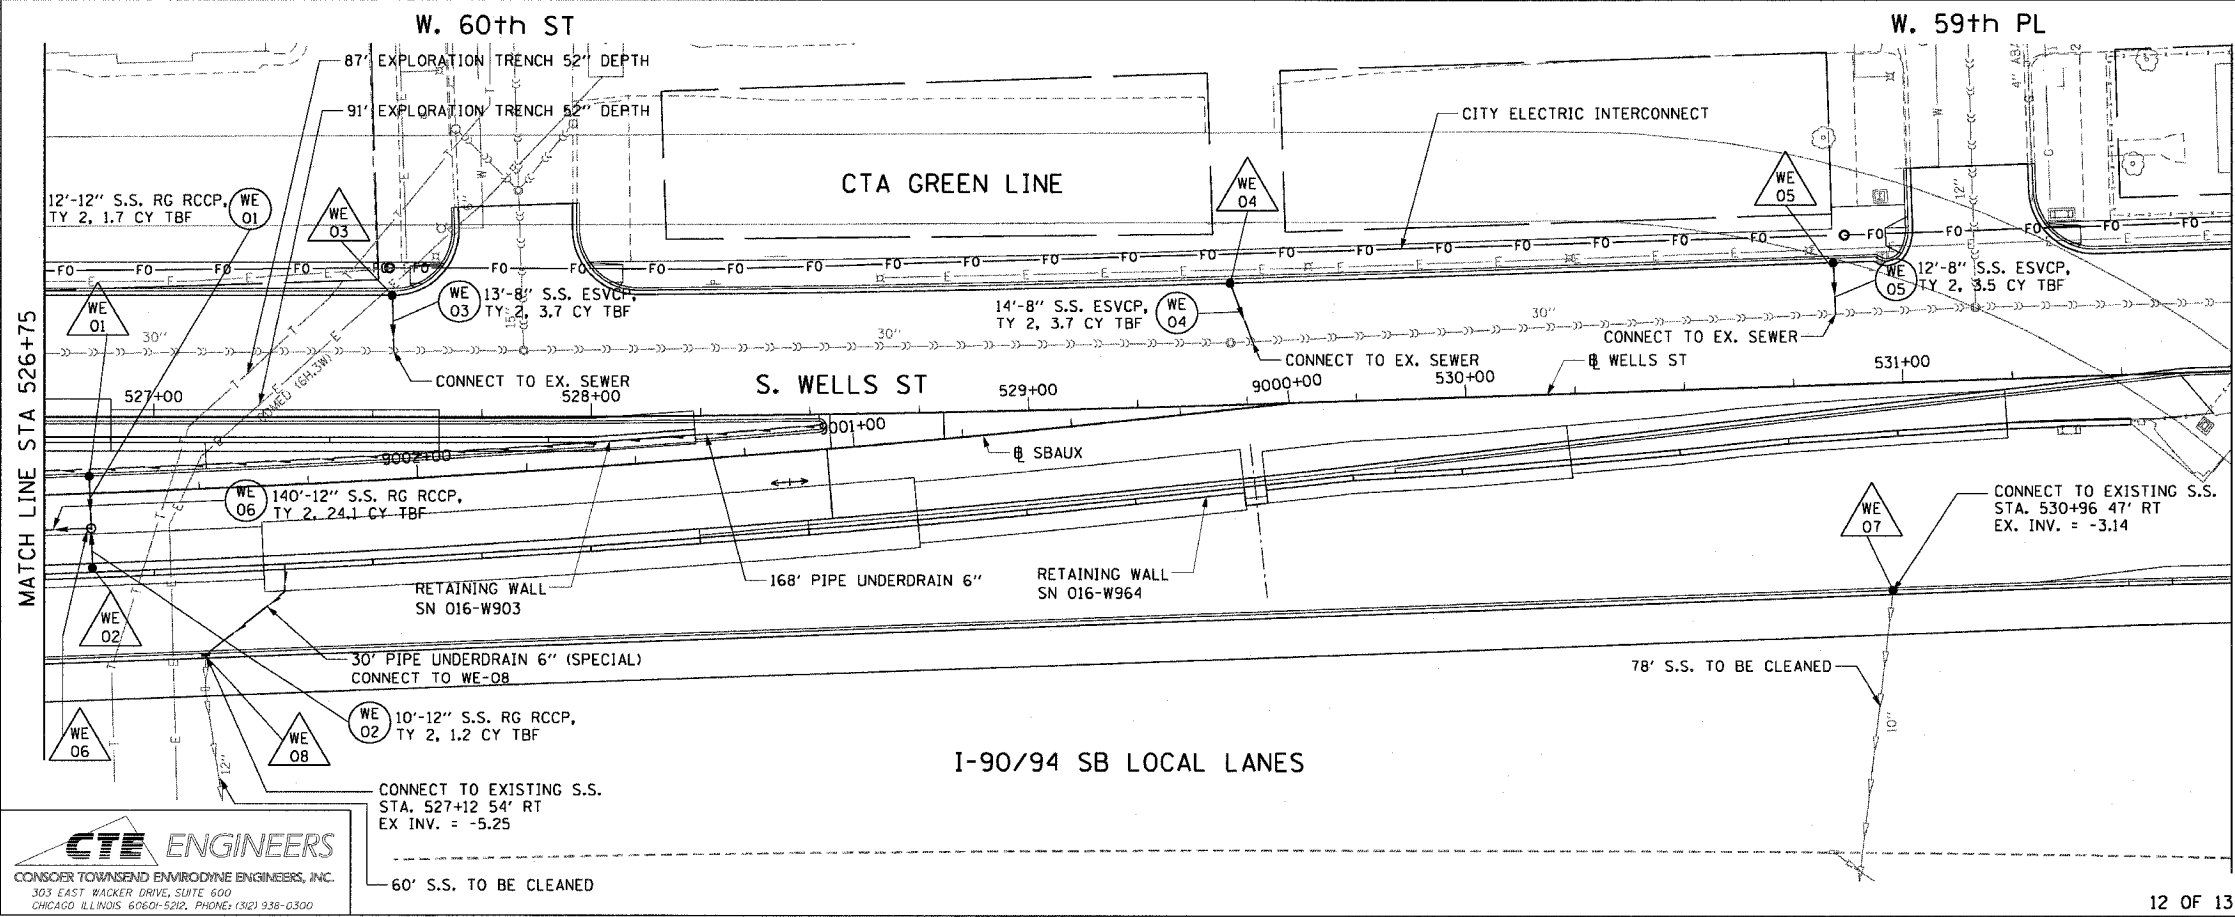

- LEGEND: PROPOSED**
- INLET
 - o CATCH BASIN
 - o MANHOLE
 - STORM SEWER
 - COMBINED SEWER
 - PIPE UNDERDRAIN
 - PROPOSED SWALE
 - (EA 01) PROPOSED STORM SEWER PIPE
 - (EA 01) PROPOSED STRUCTURE
 - o CITY ELECTRIC HANDHOLE

- NOTES:**
- SEE DRAINAGE SCHEDULES FOR STRUCTURE, PIPE AND UNDERDRAIN INFORMATION.
 - SEE INTERCONNECT CONDUIT PLANS FOR CITY ELECTRIC INTERCONNECT IMPROVEMENTS.

REVISIONS	
NAME	DATE

ILLINOIS DEPARTMENT OF TRANSPORTATION
F.A.I. 90/94 (DAN RYAN EXPRESSWAY)
63rd ST TO 59th ST (FRONTAGE ROAD & RAMPS)

**DRAINAGE AND UTILITY PLANS
WELLS STREET**

SCALE: 1"=20'
DATE: October 29, 2004

DRAWN BY: JB
CHECKED BY: EBY

CTE ENGINEERS
CONSOER TOWNSEND ENVIRONMENTAL ENGINEERS, INC.
303 EAST WACKER DRIVE, SUITE 600
CHICAGO, ILLINOIS 60601-5212, PHONE: (312) 938-0300

m:\p040463\civil\ac-cm\90-94\drainage and utility plan\0409090502a.dwg 11/22/2004 02:36:31 PM