



F.A.I. RTE.	SECTION	COUNTY	TOTAL SHEETS	SHEET NO.
90/94	2021-922PT.J-AC	COOK	460	95
STA. 531+75	TO STA. 536+75			
FED. ROAD DIST. NO. 1 ILLINOIS FED. AID PROJECT				
62693				

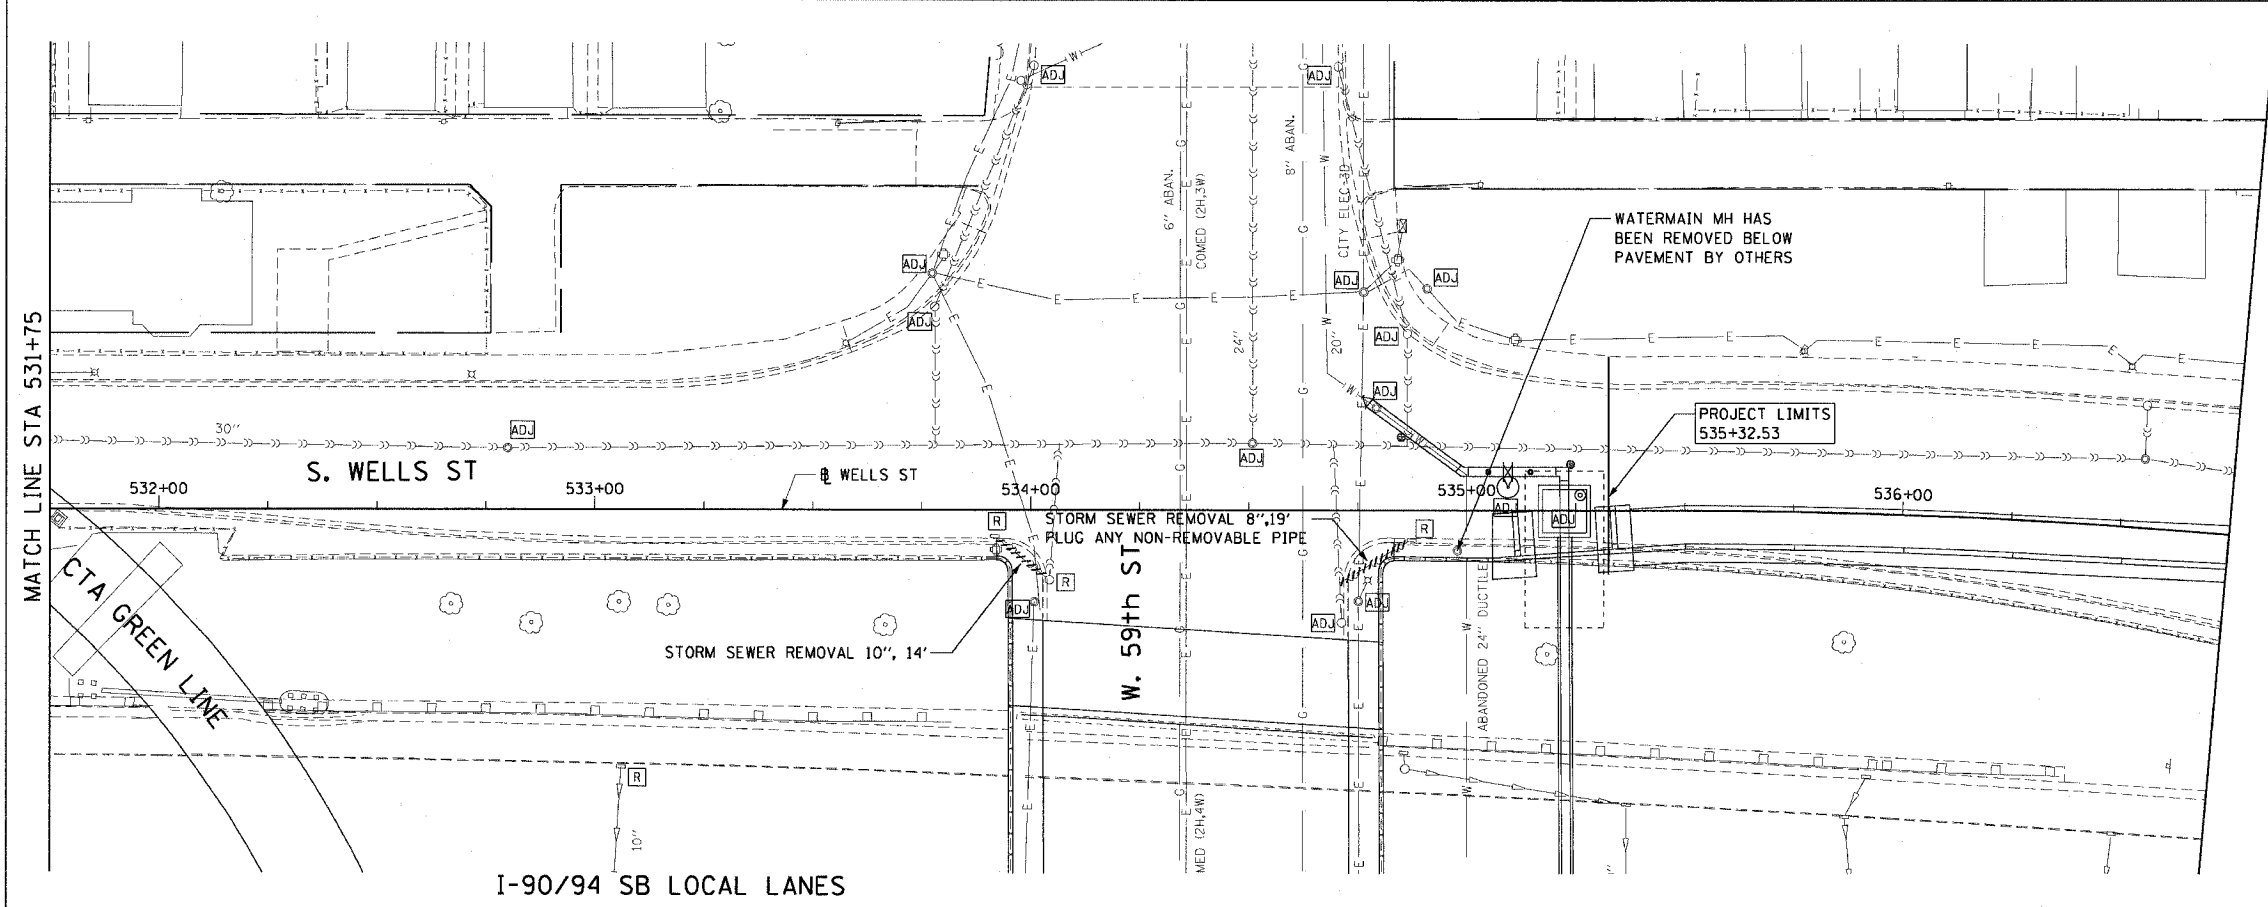

- LEGEND: EXISTING**
- INLET
 - CATCH BASIN
 - MANHOLE
 - STORM SEWER
 - COMBINED SEWER
 - PIPE UNDERDRAIN
 - [R] STRUCTURE TO BE REMOVED
 - [AD] STRUCTURE TO BE ADJUSTED
 - //// STORM SEWER REMOVAL OR ABANDON
 - //// COMBINED SEWER REMOVAL OR ABANDON

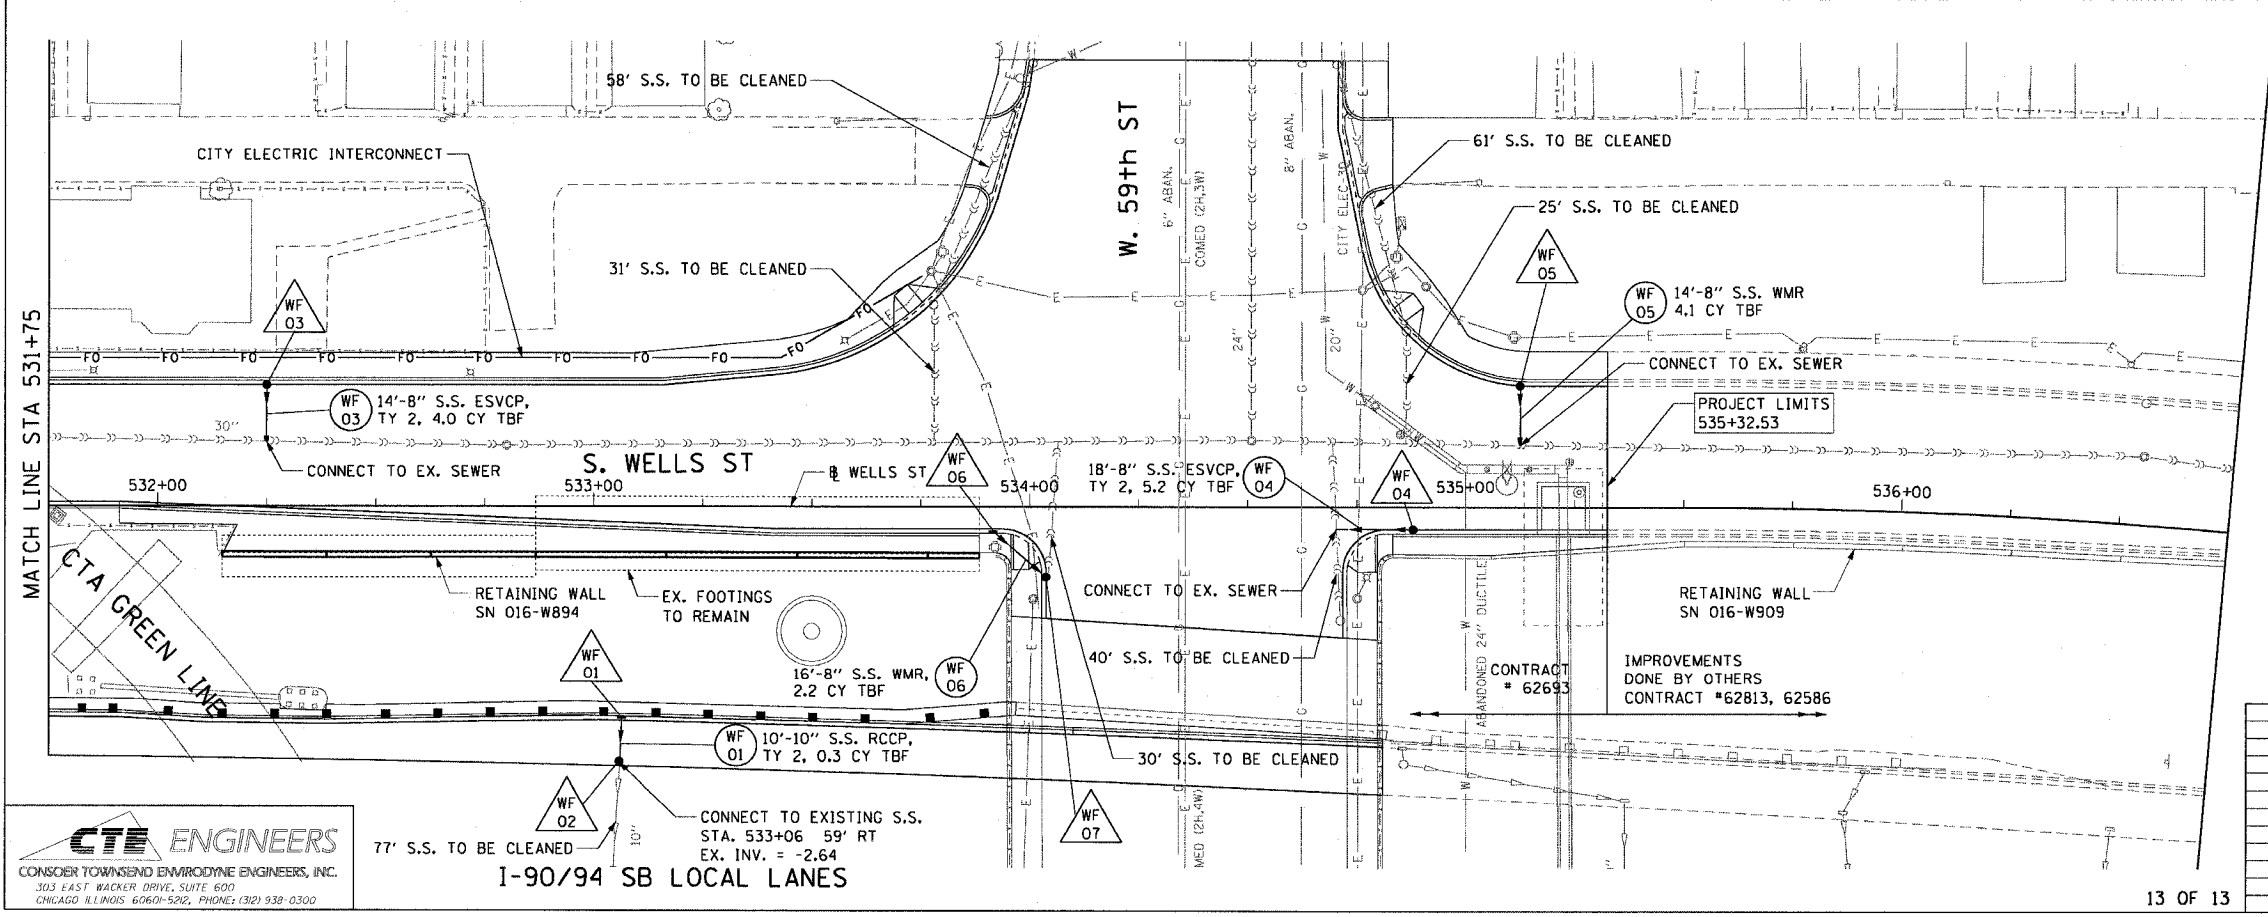

- EXISTING CONDITIONS AND REMOVAL**
- PROPOSED IMPROVEMENTS**
- LEGEND: PROPOSED**
- INLET
 - CATCH BASIN
 - MANHOLE
 - STORM SEWER
 - COMBINED SEWER
 - PIPE UNDERDRAIN
 - PROPOSED SWALE
 - EA 01 PROPOSED STORM SEWER PIPE
 - △ EA 01 PROPOSED STRUCTURE
 - CITY ELECTRIC HANDHOLE

- NOTES:**
- SEE DRAINAGE SCHEDULES FOR STRUCTURE, PIPE AND UNDERDRAIN INFORMATION.
 - SEE INTERCONNECT CONDUIT PLANS FOR CITY ELECTRIC INTERCONNECT IMPROVEMENTS.

REVISIONS	
NAME	DATE

ILLINOIS DEPARTMENT OF TRANSPORTATION
 F.A.I. 90/94 (DAN RYAN EXPRESSWAY)
 63rd ST TO 59th ST (FRONTAGE ROAD & RAMPS)

DRAINAGE AND UTILITY PLANS
WELLS STREET

SCALE: 1"=20'
 DATE: October 29, 2004

DRAWN BY: JB
 CHECKED BY: EY

CTE ENGINEERS
 CONSER TOWNSEND EMPLOYING ENGINEERS, INC.
 303 EAST WACKER DRIVE, SUITE 600
 CHICAGO, ILLINOIS 60601-5202, PHONE: (312) 938-0300

11/22/2004 02:56:37 PM m:\p\00665\civil\ac-ar\90\drainage and utility plan\0066502.dwg