


SIGN DETAIL
1:75

EB-TR-44
STA. 445+40

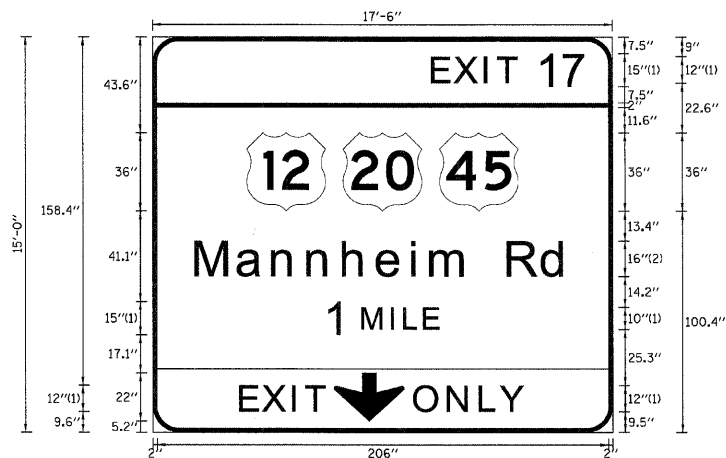

SIGN NUMBER	name
WIDTH x HIGHT.	17'-6" x 15'-0"
BORDER WIDTH	2"
CORNER RADIUS	12"
MOUNTING	Overhead
BACKGROUND	TYPE: Reflective
	COLOR: Green
LEGEND/BORDER	TYPE: Reflective
	COLOR: White,BlackWhite

SYMBOL	ROT	X	Y	WID	HT
M1_4	0	43	100.4	36	36
M1_4	0	87	100.4	36	36
M1_4	0	131	100.4	36	36
ARDOWN	0	82.8	5.2	32	22

Panel Style: sign_default.ssi
Dimensions are in inches.tenths

FONT:
(1) ClearviewHwy-5-W
(2) ClearviewHwy-5-W-R

Letter locations are panel edge to lower left corner

LETTER POSITIONS (X)

											LENGTH	SERIESSIZE
E	X	I	T	1	7							ClearviewHwy-5-W
128.2	138.4	152.1	158	176.7	187.9						70.3	12,15
M	a	n	n	h	e	l	m		R	d		ClearviewHwy-5-W-R
20.2	39.1	55.1	71.2	87.4	102.9	118.8	127.3	145.3	162.5	178.3	169.7	1613
1	M	I	L	E								ClearviewHwy-5-W
79.4	96.2	109.3	115.2	124.3							51.2	15,10
E	X	I	T									ClearviewHwy-5-W
40.4	50.6	64.3	70.2								38.5	12
O	N	L	Y									ClearviewHwy-5-W
119.8	135.2	149.9	159.1								49.8	12

FILE NAME =	DESIGNED - SEW	REVISED -
#FILE#	DRAWN - SEW	REVISED -
USER NAME = #USER#	CHECKED - FML	REVISED -
PLOT DATE = #DATE#	DATE - 12/2009	REVISED -



STATE OF ILLINOIS
DEPARTMENT OF TRANSPORTATION

SIGNING DETAILS

SCALE: N.T.S. SHEET NO. 19 OF 58 SHEETS STA. TO STA.

F.A.I. RTE.	SECTION	COUNTY	TOTAL SHEETS	SHEET NO.
290	2009-099BR	COOK/DUPAGE	394	347
FED. ROAD DIST. NO. ILLINOIS FED. AID PROJECT			CONTRACT NO. 60157	