


SIGN DETAIL

1:75

EB-CL-47  
STA. 468+60

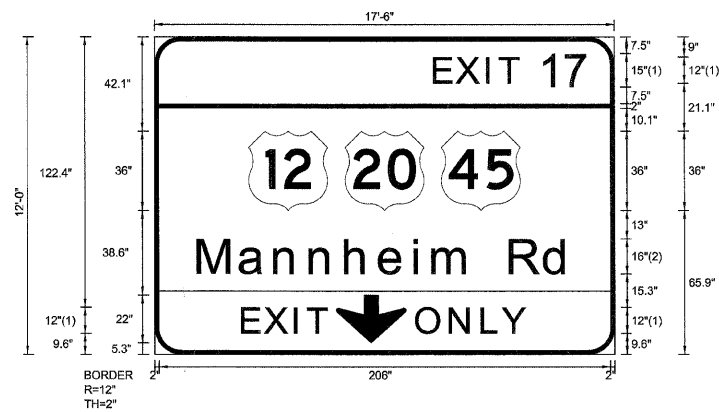

SIGN NUMBER	name
WIDTH x HGHT.	17'-6" x 12'-0"
BORDER WIDTH	2"
CORNER RADIUS	12"
MOUNTING	Overhead
BACKGROUND	TYPE: Reflective COLOR: Green
LEGEND/BORDER	TYPE: Reflective COLOR: White,Black/White

SYMBOL	ROT	X	Y	WID	HT
M1_4	0	43	65.9	36	36
M1_4	0	87	65.9	36	36
M1_4	0	131	65.9	36	36
AROUND	0	82.8	5.2	32	22

Panel Style: sign\_default.ssi  
Dimensions are in inches.tenths

FONT:  
(1) ClearviewHwy-5-W  
(2) ClearviewHwy-5-W-R

Letter locations are panel edge to lower left corner

LETTER POSITIONS (X)

															LENGTH	SERIESSIZE
E	X	I	T	1	7										70.3	ClearviewHwy-5-W 12,15
M	a	n	n	h	e	i	m		R	d					169.7	ClearviewHwy-5-W-R 1613
E	X	I	T												38.5	ClearviewHwy-5-W 12
O	N	L	Y												49.8	ClearviewHwy-5-W 12

FILE NAME =	DESIGNED - SEW	REVISED -
*FILEL*	DRAWN - SEW	REVISED -
USER NAME = *USER*	CHECKED - FML	REVISED -
PLOT DATE = *DATE*	DATE - 12/2009	REVISED -



STATE OF ILLINOIS  
DEPARTMENT OF TRANSPORTATION

SIGNING DETAILS

SCALE: N.T.S. SHEET NO. 21 OF 58 SHEETS STA. TO STA.

F.A.I. RTE.	SECTION	COUNTY	TOTAL SHEETS	SHEET NO.
290	2009-099BR	COOK/DUPAGE	394	349
FED. ROAD DIST. NO. ILLINOIS FED. AID PROJECT			CONTRACT NO. 60157	