


SIGN DETAIL  
1:75

EB-TR-133  
STA. 1208+20

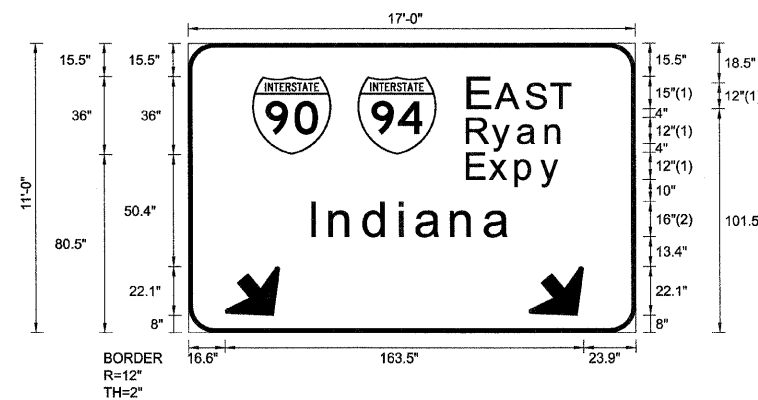

Panel Style: sign\_default.ssi  
Dimensions are in inches.tenths

FONT:  
(1) ClearviewHwy-5-W  
(2) ClearviewHwy-5-W-R

Letter locations are panel edge to lower left corner

SIGN NUMBER	name
WIDTH x HGHT.	17'-0" x 11'-0"
BORDER WIDTH	2"
CORNER RADIUS	12"
MOUNTING	Overhead
BACKGROUND	TYPE: Reflective
	COLOR: Green
LEGEND/BORDER	TYPE: Reflective
	COLOR: White/White

SYMBOL	ROT	X	Y	WID	HT
M1_1	0	29.3	80.5	36	36
M1_1	0	77.3	80.5	36	36
ARDOWN	40	16.6	8	32	22
ARDOWN	40	155.2	8	32	22

LETTER POSITIONS (X)

										LENGTH	SERIESSIZE
E	A	S	T								ClearviewHwy-5-W
128.3	141	154.7	166.1							46.5	15,12
R	y	a	n								ClearviewHwy-5-W
127.7	139.2	151	163.7							44.3	129.8
E	x	p	y								ClearviewHwy-5-W
127.7	137.7	149.9	161.2							42.9	129.8
I	n	d	i	a	n	a					ClearviewHwy-5-W-R
56.6	65	80.5	96.9	104.4	120.4	135.6				90.8	1613

FILE NAME =	DESIGNED - SEW	REVISED -
*FILEL*	DRAWN - SEW	REVISED -
USER NAME = *USER*	CHECKED - SEW	REVISED -
PLOT DATE = *DATE*	DATE - 1/25/10	REVISED -



STATE OF ILLINOIS  
DEPARTMENT OF TRANSPORTATION

SIGNING DETAILS

SCALE: N.T.S. SHEET NO. 20 OF 46 SHEETS STA. TO STA.

F.A.I. RTE.	SECTION	COUNTY	TOTAL SHEETS	SHEET NO.
290	(2525, ETC., 2727) RS-8	COOK	201	128
FED. ROAD DIST. NO.			ILLINOIS FED. AID PROJECT	
			CONTRACT NO. 60K11	