


SIGN DETAIL
1:75

WB-BM-124
STA. 1078+70

SIGN NUMBER	name
WIDTH x HGHT.	23'-6" x 8'-6"
BORDER WIDTH	2"
CORNER RADIUS	12"
MOUNTING	Overhead
BACKGROUND	TYPE: Reflective COLOR: Green
LEGEND/BORDER	TYPE: Reflective COLOR: White/White

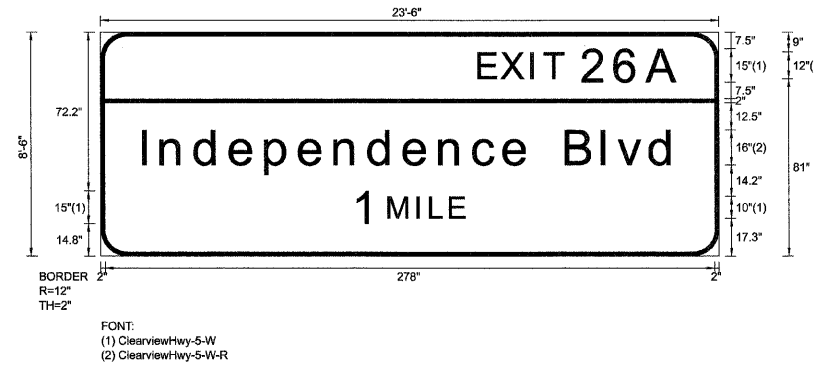

Panel Style: sign_default.ssi
Dimensions are in inches tenths

Letter locations are panel edge to lower left corner

SYMBOL	ROT	X	Y	WID	HT

LETTER POSITIONS (X)

																										LENGTH	SERIESIZE			
E	X	I	T	2	6	A																								ClearviewHwy-5-W
173	183.3	196.9	202.8	220.5	235.6	250																							91	12,15
I	n	d	e	p	e	n	d	e	n	c	e	B	I	v	d															ClearviewHwy-5-W-R
19.5	27.9	43.4	59.4	75.6	91	107.2	122.8	138.8	155	170.5	184.4	196.1	212.7	229.3	236.2	250.9													243	16/13
1	M	I	L	E																										ClearviewHwy-5-W
115.9	131.7	144.8	150.7	159.8																									50.2	15,10

FILE NAME =	DESIGNED - SEW	REVISED -
FILEL	DRAWN - SEW	REVISED -
USER NAME = *USER*	CHECKED - SEW	REVISED -
PLOT DATE = *DATE*	DATE - 1/25/10	REVISED -



STATE OF ILLINOIS
DEPARTMENT OF TRANSPORTATION

SIGNING DETAILS

SCALE: N.T.S. SHEET NO. 23 OF 46 SHEETS STA. TO STA.

F.A.I. RTE.	SECTION	COUNTY	TOTAL SHEETS	SHEET NO.
290	(2525, ETC., 2727) RS-8	COOK	201	131
FED. ROAD DIST. NO. [ILLINOIS] FED. AID PROJECT			CONTRACT NO. 60K11	