


SIGN DETAIL
1:75

WB-BM-134
STA. 1132+20

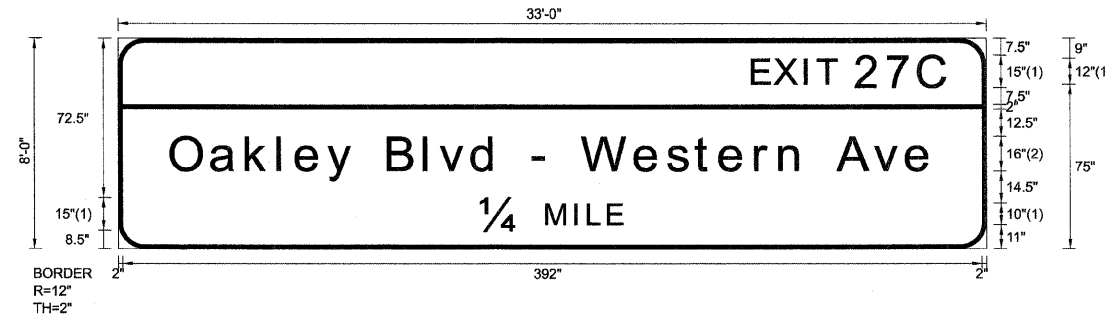

FONT:
(1) ClearviewHwy-S-W
(2) ClearviewHwy-S-W-R

Panel Style: sign_default.ssi
Dimensions are in inches.tenths

Letter locations are panel edge to lower left corner

SIGN NUMBER	name
WIDTH x HGHT.	33'-0" x 8'-0"
BORDER WIDTH	2"
CORNER RADIUS	12"
MOUNTING	Overhead
BACKGROUND	TYPE: Reflective COLOR: Green
LEGEND/BORDER	TYPE: Reflective COLOR: White/White

SYMBOL	ROT	X	Y	WID	HT

LETTER POSITIONS (X)

LENGTH SERIESSIZE

Letter	X	Length	Series Size
E	289.7	88.3	ClearviewHwy-5-W
X	300	12.15	
I	313.7		
T	319.6		
2	337.2		
7	351.4		
C	365.8		
O	24.4	347.3	ClearviewHwy-5-W-R
a	42.9		
k	58.8		
l	73.3		
e	81.5		
y	95.8		
B	108.3		
l	123.6		
v	140.2		
d	147.2		
-	161.9		
W	173.4		
e	190.3		
s	196.6		
t	212		
e	236.2		
r	251		
n	263.7		
A	274.9		
v	291.1		
e	302.1		
1/4	313.2		
M	328.6		
I	345.2		
L	359.9		
E	165.7	64.5	ClearviewHwy-5-W
	195.7	15.10	
	208.8		
	214.7		
	223.8		

FILE NAME =	DESIGNED - SEW	REVISED -
FILEL	DRAWN - SEW	REVISED -
USER NAME = #USER#	CHECKED - SEW	REVISED -
PLOT DATE = #DATE#	DATE - 1/25/10	REVISED -



STATE OF ILLINOIS
DEPARTMENT OF TRANSPORTATION

SIGNING DETAILS

SCALE: N.T.S. SHEET NO. 30 OF 46 SHEETS STA. TO STA.

F.A.I. RTE.	SECTION	COUNTY	TOTAL SHEETS	SHEET NO.
290	(2525, ETC., 2727) RS-8	COOK	201	137
FED. ROAD DIST. NO. ILLINOIS FED. AID PROJECT			CONTRACT NO. 60K11	