




CONTRACT NO.				
F.A. RTE.	SECTION	COUNTY	TOTAL SHEETS	SHEET NO.
2328	1132-N	Will	133	1058
STA.		TO STA.		
FED. ROAD DIST. NO.		ILLINOIS FED. AID PROJECT		

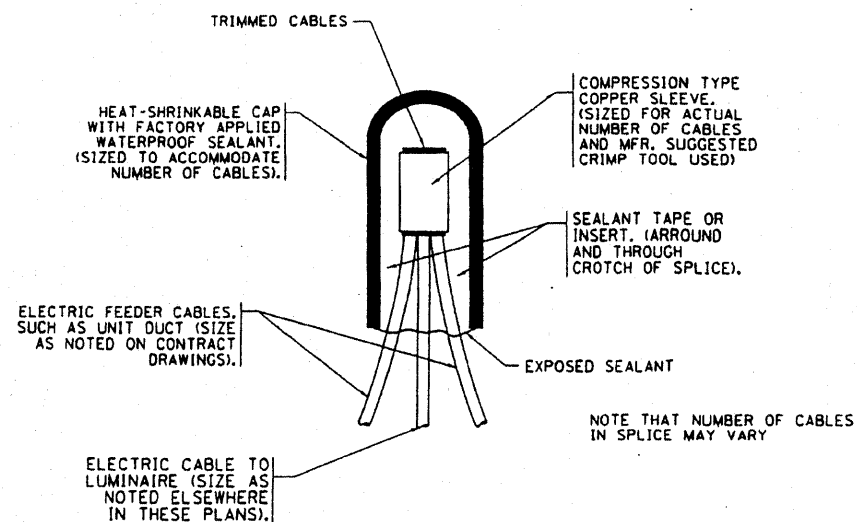

TYPICAL SPLICE DETAIL
N.T.S.

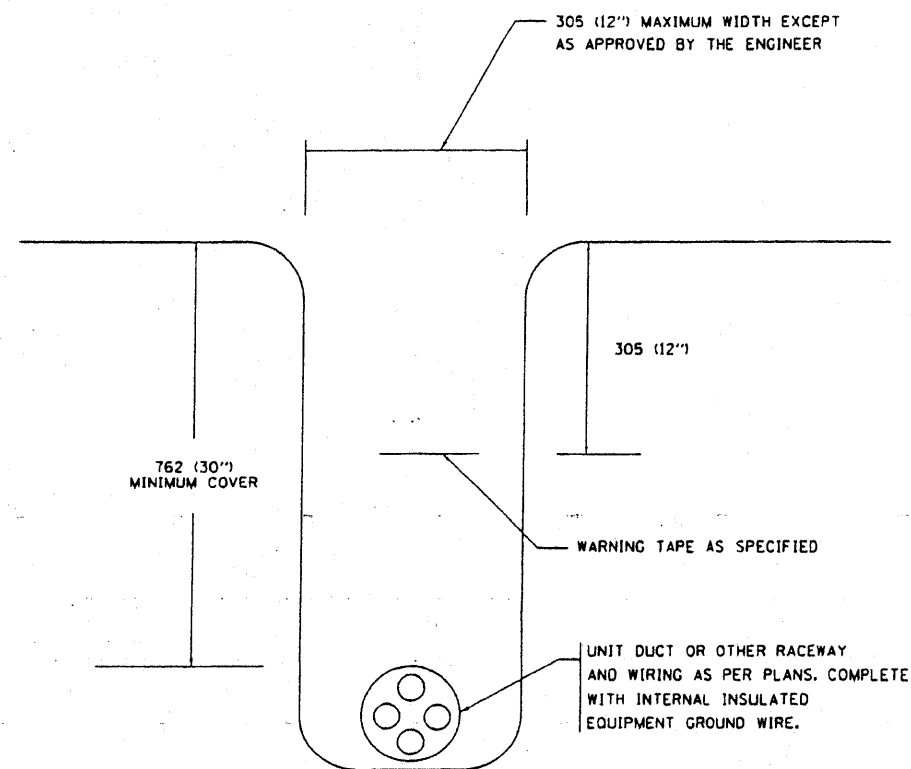

TYPICAL WIRING IN TRENCH DETAIL
N.T.S.

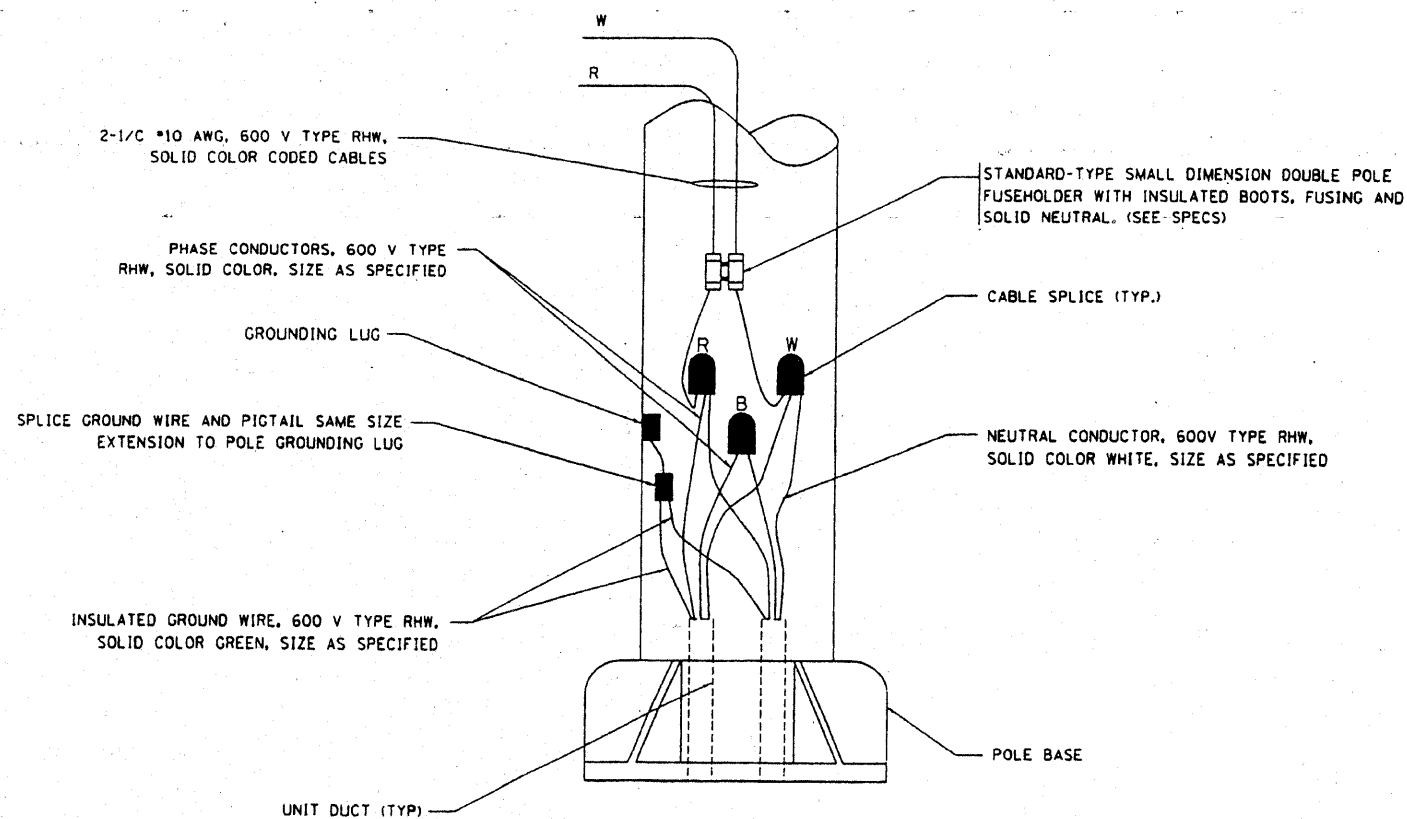

POLE WIRING DETAIL
N.T.S.

REVISIONS		ILLINOIS DEPARTMENT OF TRANSPORTATION
NAME	DATE	
		MISC. ELECTRICAL DETAILS SHEET A

VERT. SCALE: HORIZ. DATE: 4/25/2006

DRAWN BY
CHECKED BY
BE-702
REVISION DATE:

1 REVISED 11/05/07 AH

PLT DATE: 4/20/2006
FILE NAME: c:\p\projects\misc\misc\misc.dwg
USER NAME: jgibson