
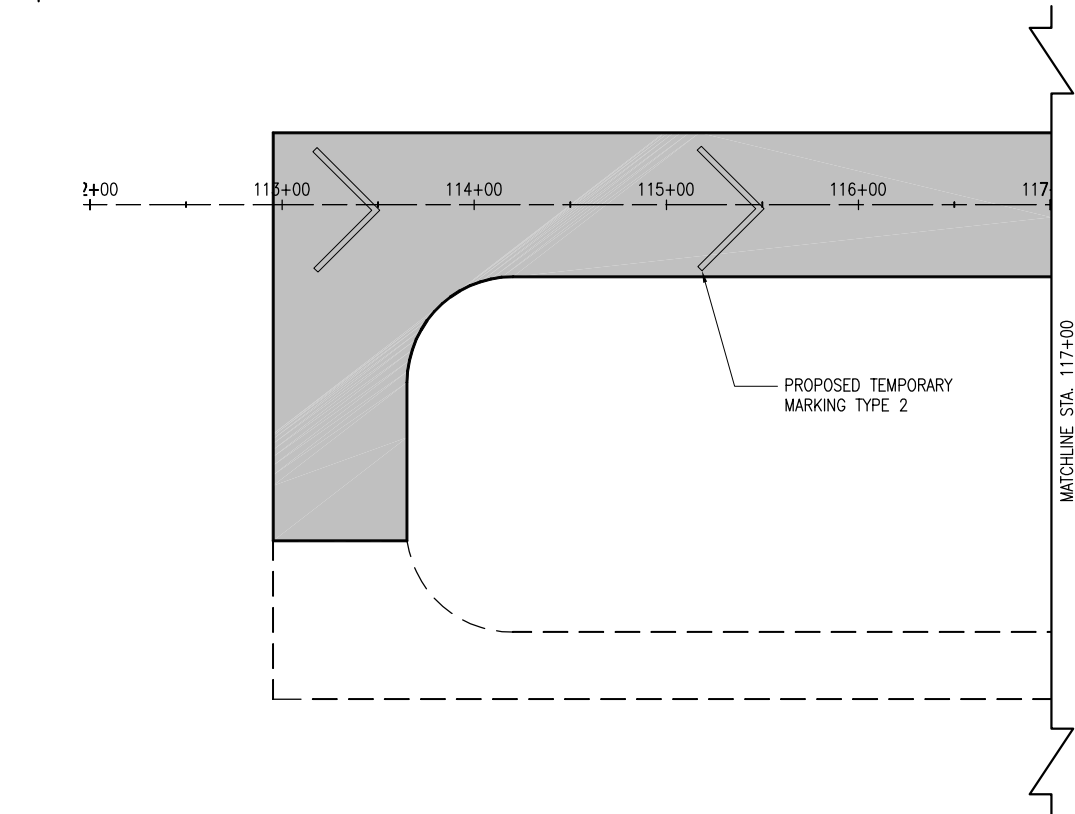


NOTE:

THE CONTRACTOR MAY ELIMINATE THE ABOVE GROUND JUMPERS BETWEEN THE TEMPORARILY DISPLACED THRESHOLD LIGHTS AND RUNWAY LIGHTS R2-29 AND R2-40 BY DIRECTIONAL BORING A CABLE IN UNIT DUCT UNDER THE RUNWAY AT STATION 126+00 AND CONNECTING THAT CABLE TO LIGHTS TR-4 AND TR-5. NO ADDITIONAL COMPENSATION WILL BE ALLOWED IF THE CONTRACTOR ELECTS TO DIRECTIONAL BORE THE CABLE.

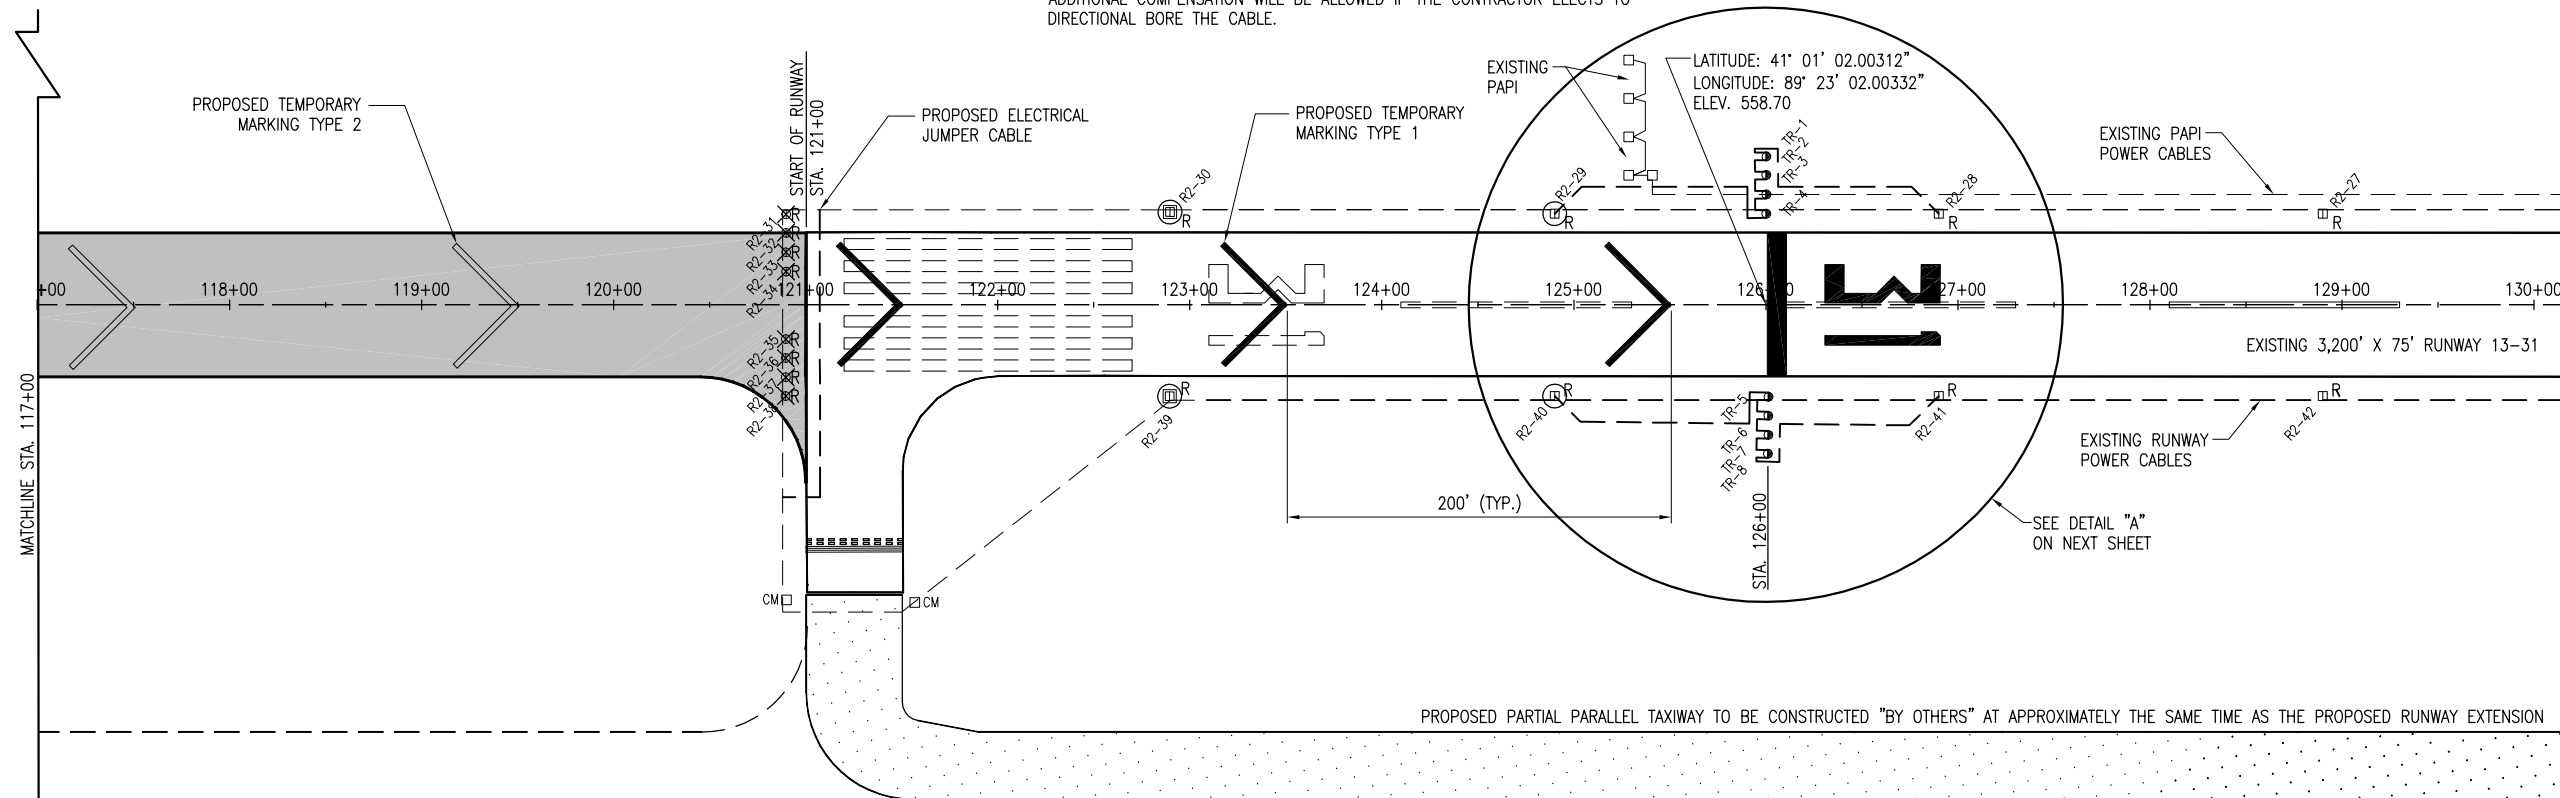

MARKING REMOVAL QUANTITIES			
DESCRIPTION	UNIT AREA	NO. REQUIRED	TOTAL AREA
RUNWAY THRESHOLD STRIPES	862.5	6	5,175
RUNWAY CENTERLINE STRIPES	360	2	720
NUMBER 1	318	1	318
NUMBER 3	634	1	634
TOTAL MARKING			6,847

LEGEND

- EXISTING PAVEMENT
- EXISTING MARKING (TO REMAIN IN PLACE)
- EXISTING MARKING (TO BE REMOVED)
- PROPOSED TEMPORARY MARKING TYPE 1
- PROPOSED TEMPORARY MARKING TYPE 2
- EXISTING ELECTRICAL DUCT
- EXISTING ELECTRICAL CABLES
- PROPOSED ELECTRICAL CABLES
- EXISTING STAKE MOUNTED RUNWAY LIGHT
- EXISTING STAKE MOUNTED RUNWAY LIGHT (TO BE COVERED)
- EXISTING BASE MOUNTED RUNWAY LIGHT
- EXISTING BASE MOUNTED RUNWAY LIGHT (TO BE COVERED)
- EXISTING STAKE MOUNTED RUNWAY THRESHOLD LIGHT (TO BE RELOCATED)
- RELOCATED STAKE MOUNTED RUNWAY THRESHOLD LIGHT


620900-PAVEMENT MARKING REMOVAL NOTES

THE EXISTING PAVEMENT MARKING SHALL BE REMOVED IN ACCORDANCE WITH ITEM 620 "PAVEMENT MARKING" AS STATED ON PAGE 272 OF THE STANDARD SPECIFICATIONS FOR CONSTRUCTION OF AIRPORTS, ADOPTED APRIL 1, 2012.

THE AREAS THAT ARE DESIGNATED FOR REMOVAL ARE SHOWN ON THE CONSTRUCTION PLANS.

ALL AREAS TO BE REMOVED ARE CALCULATED AREAS. ANY ADDITIONAL AREAS, DUE TO OVER SPRAY, SHALL BE CONSIDERED INCIDENTAL TO THE CONTRACT AND NO ADDITIONAL COMPENSATION WILL BE ALLOWED.

THE PROPOSED MARKING REMOVAL WILL BE PAID FOR UNDER ITEM: AR620900 PAVEMENT MARKING REMOVAL ___ PER S.F.

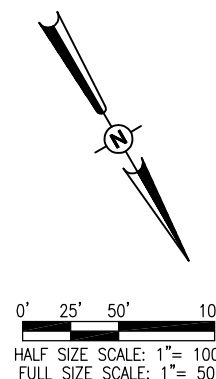

REVISION	DATE

MARSHALL COUNTY AIRPORT
LACON, ILLINOIS

IL PROJ.: C75-4223 BLOCK GRANT PROJ.: 3-17-0059-B15

Hanson Proj. No. 10A00051	BAK	07/09/10
Filename R-551MRK.DWG	BAK	07/09/10
Scale 1"=50'	CAH	03/30/11
Date 12/14/12		
LAYOUT		
DRAWN		
REVIEWED		

HANSON
Professional Services Inc. 2013
Hanson Professional Services Inc.
1525 South Sixth Street
Springfield, Illinois 62703-2986
Ph: (217) 788-2450 Fax: (217) 788-2503
www.hanson-inc.com
Offices Nationwide

PAVE, LIGHT AND MARK
805' EXTENSION

PROPOSED TEMPORARY
MARKING AND LIGHTING PLAN