


ITEM DESCRIPTION	SYMBOL
THERMOPLASTIC PVM. MARKING LINE 4", 30" SKIP 10' DASH, YELLOW	A
THERMOPLASTIC PVM. MARKING LINE 12", SCHOOL CROSSWALK @ 36" C-C, WHITE	B
THERMOPLASTIC PVM. MARKING LINE 24", STOP BAR, WHITE	C

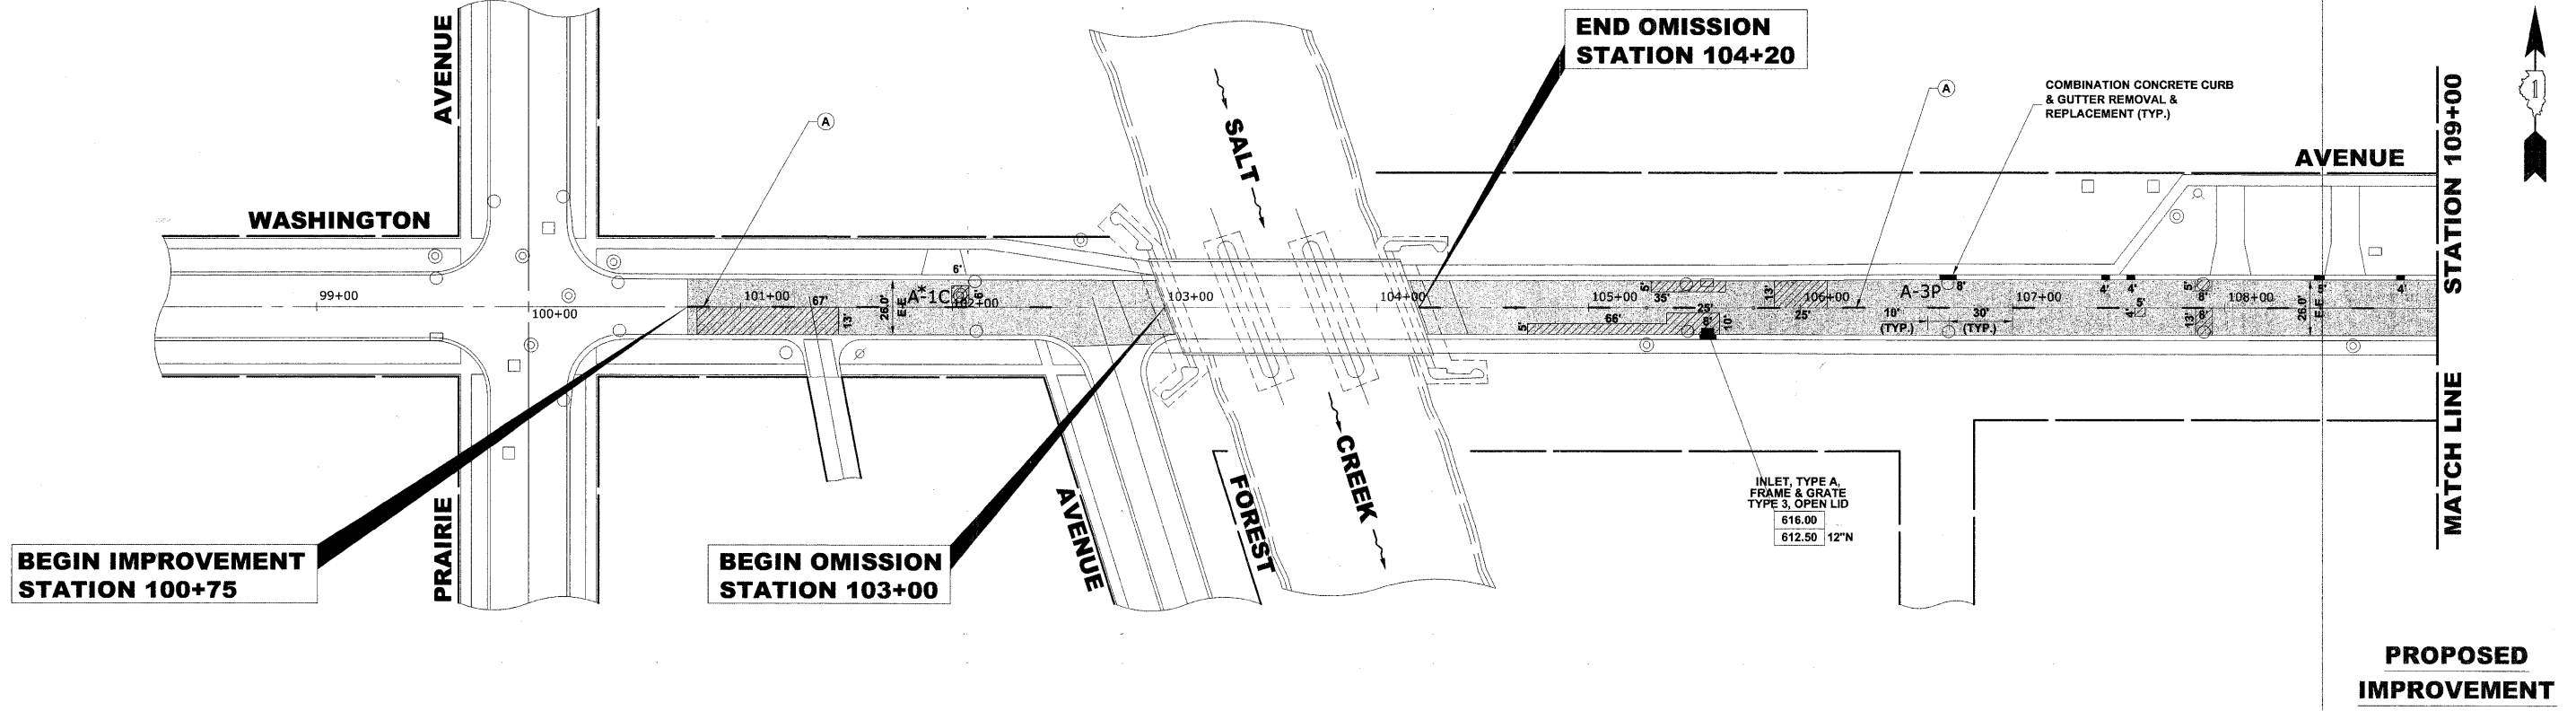

HANCOCK ENGINEERING ♦ Civil Engineers
 ♦ Municipal Consultants
 ♦ Established 1911

9933 Roosevelt Road
 Westchester, Illinois 60154-2780
 Phone: 708/865-0300
 Fax: 708/865-1212

**WASHINGTON AVENUE
 PROJECT NO. M- 8003(902)
 VILLAGE SECTION 07-00123-00-RS
 VILLAGE OF BROOKFIELD, ILLINOIS**

**WASHINGTON AVENUE
 PAVING PLAN**

SCALE:	1" = 40'	SHEET	10 / 20
DRAWN BY:	LEV/MK	OF	
BOOK NO.:	SCANS/BP/LS		
DATE:	1-16-08		
REVISION:	E.H.E. NO. 125-07-13601		