

1. COVER SHEET
2. GENERAL NOTES
3. SUMMARY OF QUANTITIES
4. SITE PLAN - LOCATION 1, ASHKUM MAINTENANCE FACILITY
5. SITE PLAN - LOCATION 2, PONTIAC MAINTENANCE FACILITY

STATE OF ILLINOIS
DEPARTMENT OF TRANSPORTATION
DIVISION OF HIGHWAYS
PROPOSED
HIGHWAY PLANS


FAP 673 & 681 (IL 116)

SECTION D3 FACILITY PRESERVATION 2014-1


CLEANING AND PAINTING STEEL BUILDINGS
IROQUOIS AND LIVINGSTON COUNTIES

C-93-103-13

F.A.P. RTE.	SECTION	COUNTY	TOTAL SHEETS	SHEET NO.
673 & 681	D3 FACILITY PRESERVATION 2014-1	*	5	1
*IROQUOIS AND LIVINGSTON			CONTRACT NO. 66D04	

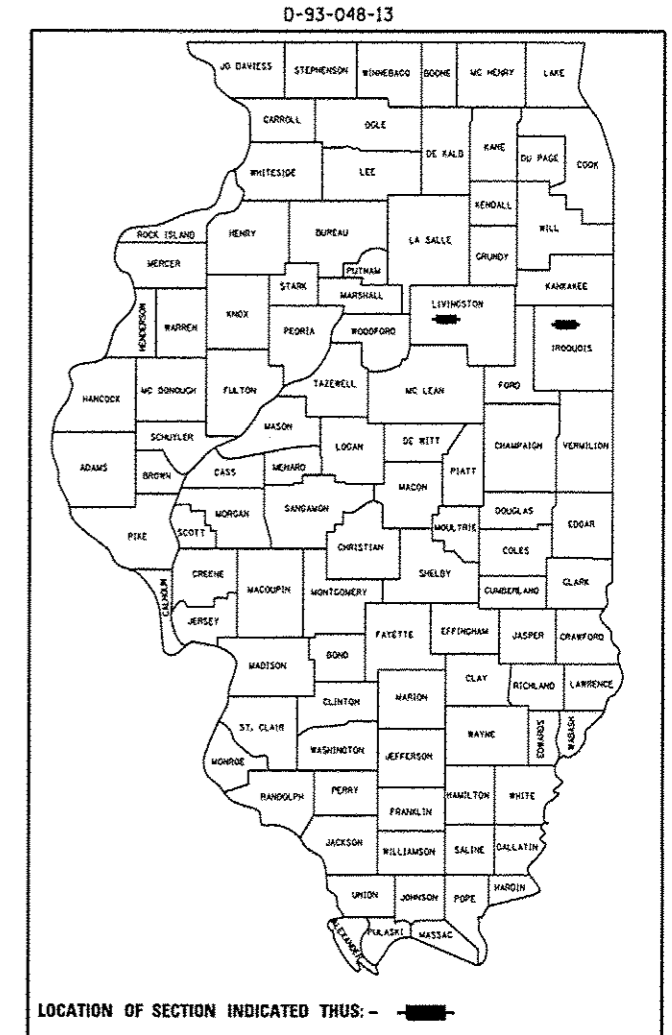


LOCATION 1
ASHKUM MAINTENANCE FACILITY
 849 E IL ROUTE 116

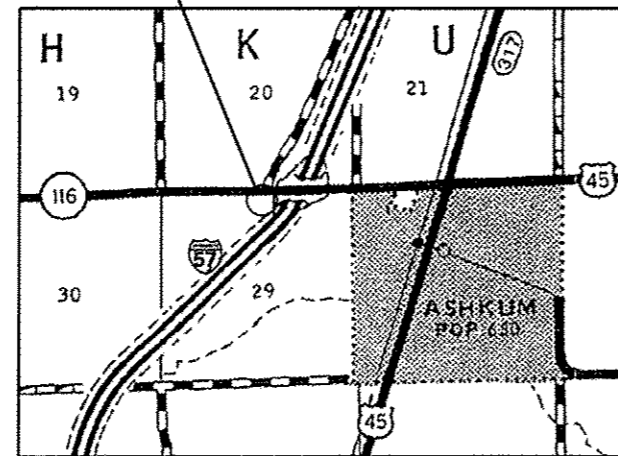


IROQUOIS COUNTY

LOCATION 3
PONTIAC MAINTENANCE FACILITY
 12970 E. IL ROUTE 116

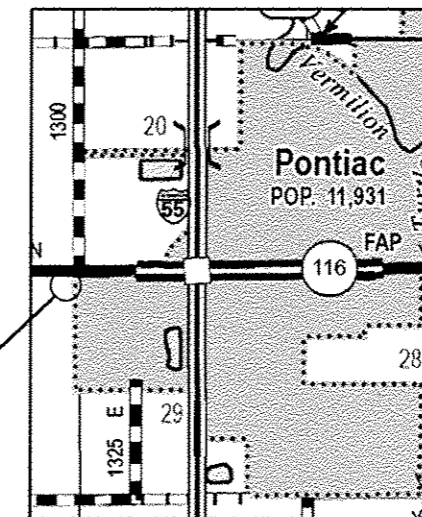

LIVINGSTON COUNTY

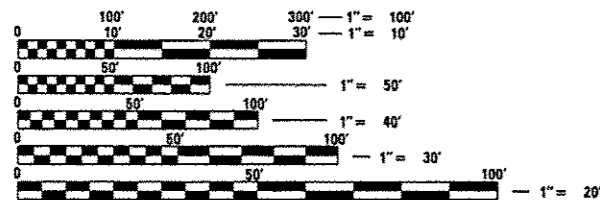

FULL SIZE PLANS HAVE BEEN PREPARED USING STANDARD ENGINEERING SCALES. REDUCED SIZED PLANS WILL NOT CONFORM TO STANDARD SCALES. IN MAKING MEASUREMENTS ON REDUCED PLANS, THE ABOVE SCALES MAY BE USED.

J.U.L.I.E.
 JOINT UTILITY LOCATION INFORMATION FOR EXCAVATION
 1-800-892-0123
 OR 811

PROJECT ENGINEER: JOE KANNEL P.E.
PROJECT MANAGER: RON WOODSHANK
TOWNSHIP: VARIOUS

CONTRACT NO. 66D04

STATE OF ILLINOIS
 DEPARTMENT OF TRANSPORTATION
 DIVISION OF HIGHWAYS

SUBMITTED Oct. 24 2013
Paul A. Laska
 DEPUTY DIRECTOR OF HIGHWAYS, REGION ENGINEER

Dec 6 2013
John D. Baranzelli, PE
 acting ENGINEER OF DESIGN AND ENVIRONMENT

Dec 6 2013
Omer Osman, PE
 DIRECTOR OF HIGHWAYS, CHIEF ENGINEER

PRINTED BY THE AUTHORITY
OF THE STATE OF ILLINOIS

GENERAL NOTES

PLAN DIMENSIONS AND DETAILS RELATIVE TO EXISTING PLANS ARE SUBJECT TO ROUTINE VARIATIONS. THE CONTRACTOR SHALL FIELD VERIFY EXISTING DIMENSIONS AND DETAILS AFFECTING NEW CONSTRUCTION AND MAKE NECESSARY APPROVED ADJUSTMENTS PRIOR TO CONSTRUCTION OR ORDERING OF MATERIALS. SUCH VARIATIONS SHALL NOT BE CAUSE FOR ADDITIONAL COMPENSATION FOR A CHANGE IN THE SCOPE OF THE WORK. HOWEVER, THE CONTRACTOR WILL BE PAID FOR THE QUANTITY FURNISHED BASED UPON THE UNIT BID FOR THE WORK.

FOR STABILIZATION, ALL TYPE III BARRICADES SHALL REQUIRE A MINIMUM OF FOUR SAND BAGS PER BARRICADE.

THE CONTRACTOR SHALL BE RESPONSIBLE FOR PROTECTING UTILITY PROPERTY FROM CONSTRUCTION OPERATIONS AS OUTLINED IN ARTICLE 107.31 OF THE STANDARD SPECIFICATIONS. THE "JULIE" NUMBER IS 1-800-892-0123. A MINIMUM OF FORTY-EIGHT (48) HOURS ADVANCE NOTICE IS REQUIRED.

ANY REFERENCE TO A STANDARD IN THESE PLANS SHALL BE INTERPRETED TO MEAN THE EDITION AS INDICATED BY THE SUBNUMBER LISTED ON THE INDEX OF SHEETS OR THE COPY OF THE STANDARD INCLUDED IN THESE PLANS.

THE CONTRACTOR SHALL BE REQUIRED TO SECURE WASTE CONTAINERS THAT REMAIN ON THE JOB SITE. THIS WILL ENTAIL THAT ALL WASTE CONTAINERS CAN NOT BE MOVED OR OPENED DURING NON-WORKING HOURS.

WORKING DAYS SHALL BE CHARGED UNTIL THE CONTRACTOR/ SUBCONTRACTOR LICENSED TO DISPOSE OF LEAD PAINT RESIDUE HAS REMOVED THE WASTE MATERIAL FROM THE JOB SITE ACCORDING TO ALL FEDERAL, STATE AND LOCAL LAWS AND ORDINANCES.

THE EXISTING STEEL ^{MAY CONTAIN} CONTAINS LEAD. THE CONTRACTOR SHOULD TAKE APPROPRIATE PRECAUTIONS TO DEAL WITH THE PRESENCE OF LEAD PAINT ON THIS PROJECT. EXISTING PAINT COATINGS SHALL NOT BE DISTURBED OR REMOVED.

THE SSPC-OP1 AND SSPC-OP2 PAINTING CONTRACTOR CERTICATIONS WILL BE REQUIRED FOR THIS PROJECT.

THE CLEANING AND PAINTING OF THE EXISTING STEEL SHALL BE AS SPECIFIED IN THE SPECIAL PROVISION FOR "CLEANING AND PAINTING EXISTING STEEL BUILDINGS".

ALL EXISTING EXTERIOR STEEL, INCLUDING WALLS, DOORS, TRIM WORK, GUTTERS AND ROOFS SHALL BE CLEANED PER "LOW PRESSURE WATER CLEANING" SSPC-SP12. ALL EXISTING EXTERIOR STEEL INCLUDING WALLS, DOORS, TRIM WORK GUTTERS AND ROOFS SHALL BE PAINTED WITH AN APPROVED GALVANIZED METAL PRIMER OR ACRYLIC PRIMER SUITABLE FOR METAL AND TWO (2) COATS OF AN APPROVED "ACRYLIC PAINT". THE COLOR OF THE FINAL FINISH COAT FOR THE EXTERIOR WALLS SHALL BE "TAN", THE COLOR OF THE FINAL FINISH COAT FOR DOORS, WINDOWS AND ROOFS SHALL BE "WHITE". THE FINAL FINISH COAT FOR ALL TRIM WORK SHALL BE DARK BROWN. ALL PAINT MATERIALS SHALL BE APPROVED BY THE ENGINEER PRIOR TO THE ORDERING OF MATERIALS.

ALL EXISTING EXTERIOR STEEL INCLUDING WALLS, DOORS, TRIM WORK, GUTTERS INCLUDING DOWN SPOUTS, AND ROOF EAVES SHALL BE CLEANED ACCORDING TO THE REQUIREMENTS OF SSPC-SP1 AND SSPC-SP2 (SSI-ST3). ALL EXISTING EXTERIOR STEEL INCLUDING WALLS, DOORS, TRIM WORK, GUTTERS INCLUDING DOWN SPOUTS, AND ROOF EAVES SHALL BE PAINTED WITH ONE (1) APPLICATION OF A "LOW FILM ACRYLIC INHIBITING PRIMER" SUITABLE FOR METAL SURFACES AND TWO (2) APPLICATIONS OF AN INDUSTRIAL "SPRAY SAFE" ACRYLIC PAINT.

DATE: 10-24-13

PREPARED BY: [Signature]
DISTRICT STUDIES & PLANS ENGINEER

EXAMINED BY: [Signature]
DISTRICT CONSTRUCTION ENGINEER

[Signature]
DISTRICT MATERIALS ENGINEER

[Signature]
DISTRICT OPERATIONS ENGINEER

FILE NAME =	USER NAME = woodshenkr1	DESIGNED - RW	REVISED -	STATE OF ILLINOIS DEPARTMENT OF TRANSPORTATION	GENERAL NOTES	F.A.P. RTE.	SECTION	COUNTY	TOTAL SHEETS	SHEET NO.
c:\pwork\pwork\woodshenkr1\d0336544\0366004-shr-detail.dgn	DRAWN - RW	REVISED -	673 & 681			D3 FACILITY PRESERVATION 2014-1	*	5	2	
PLOT SCALE = 1/8" = 1'-0"	CHECKED -	REVISED -	* ILLINOIS AND LIVINGSTON			CONTRACT NO. 66004				
#MODELNAME#	DATE -	REVISED -	SCALE:			SHEET 1 OF 1 SHEETS	STA. TO STA.	ILLINOIS FED. AID PROJECT		

CONSTR. CODE	
CDB FUNDS	
100% STATE	
ROADWAY	
0044	
RURAL	URBAN
IROQUOIS	LIVINGSTON
0.5	0.5
1	
	1
1	
	1
1	
	1

CODE NO.	ITEM	UNIT	TOTAL QUANTITY
67100100	MOBILIZATION	L SUM	1
X0327632	CLEANING AND PAINTING STEEL BUILDING, LOCATION 1	L SUM	1
X0327633	CLEANING AND PAINTING STEEL BUILDING, LOCATION 2	L SUM	1
X0327635	CLEANING AND PAINTING STEEL BUILDING WARRANTY, LOCATION 1	L SUM	1
X0327636	CLEANING AND PAINTING STEEL BUILDING WARRANTY, LOCATION 2	L SUM	1
Z0007101	CONTAINMENT AND DISPOSAL OF LEAD PAINT CLEANING RESIDUES NO. 1	L SUM	1
Z0007102	CONTAINMENT AND DISPOSAL OF LEAD PAINT CLEANING RESIDUES NO. 2	L SUM	1

FILE NAME *	USER NAME = woodshankr	DESIGNED - RW	REVISED -
c:\pwork\p1dot\woodshankr\148336544	036004-shs-details.dgn	DRAWN - RW	REVISED -
#MODELNAME*	PLOT SCALE = 100.0000' / 1" /	CHECKED -	REVISED -
	PLOT DATE = 10/22/2013	DATE -	REVISED -

**STATE OF ILLINOIS
DEPARTMENT OF TRANSPORTATION**

SUMMARY OF QUANTITIES

SCALE: SHEET 1 OF 1 SHEETS STA. TO STA.

F.A.P. RTE.	SECTION	COUNTY	TOTAL SHEETS	SHEET NO.
673 & 681	D3 FACILITY PRESERVATION 2014-1	*	5	3
*IROQUOIS AND LIVINGSTON			CONTRACT NO. 66004	
[ILLINOIS] FED. AID PROJECT				

Rev.



APPROXIMATE SQUARE FOOTAGE: 36,000

Imagery Date: 5/13/2012 1998

40°52'56.60" N 87°58'13.70" W elev. 576 ft

©2010 Google

Eye alt 1903 ft

FILE NAME :	USER NAME : woodshank-1	DESIGNED - RW	REVISED -	STATE OF ILLINOIS DEPARTMENT OF TRANSPORTATION	SITE PLAN - LOCATION 1 ASHKUM MAINTENANCE FACILITY	F.A.P. RTE.	SECTION	COUNTY	TOTAL SHEETS	SHEET NO.
o:\pwwork\pwwork\woodshank-1\d0336544\366004-sht-details.dgn	PLOT SCALE = 1/80.0000 / in.	DRAWN - RW	REVISED -			673 & 681 D3 FACILITY PRESERVATION 2014-1			5	4
MODELNAME	PLOT DATE = 10/16/2013	CHECKED -	REVISED -			* IROUOIS AND LIVINGSTON	CONTRACT NO. 66D04		ILLINOIS FED. AID PROJECT	
		DATE -	REVISED -			SCALE:	SHEET 1 OF 1 SHEETS	STA. TO STA.		

12970 E 1700 N Rd, Poz

E 1700 N Rd

116

BUILDING 2

BUILDING 1

©2013 Google

©2010 Google

APPROXIMATE SQUARE FOOTAGE: 40,000

Imagery Date: 8/27/2012 1998

40°52'20.46" N 88°40'54.30" W elev. 658 ft

Eye alt 1374 ft

FILE NAME =	USER NAME = woodshankr1	DESIGNED - RW	REVISED -	STATE OF ILLINOIS DEPARTMENT OF TRANSPORTATION	SITE PLAN - LOCATION 2 PONTIAC MAINTENANCE FACILITY	F.A.P. RTE.	SECTION	COUNTY	TOTAL SHEETS	SHEET NO.
c:\pwwork\pwwork\woodshankr1\69336544\0366004-sht-details.dgn		DRAWN - RW	REVISED -			673 & 681	D3 FACILITY PRESERVATION 2014-1		5	5
		PLOT SCALE = 1/8" = 100.0000' / in.	REVISED -			* IROQUOIS AND LIVINGSTON		CONTRACT NO. 66D04		
MODELNAME =		DATE -	REVISED -			SCALE:	SHEET 1 OF 1 SHEETS	STA. TO STA.	ILLINOIS FED. AID PROJECT	