

STATE OF ILLINOIS
DEPARTMENT OF TRANSPORTATION



F.A. RTE.	SECTION	COUNTY	TOTAL SHEETS	SHEET NO.
VAR.	DIST 8 TS 2024-1	MADISON, ST. CLAIR, & MARION	17	1
		ILLINOIS	CONTRACT NO. 76T45	

FOR INDEX OF SHEETS, SEE SHEET NO. 2

PROPOSED HIGHWAY PLANS

VARIOUS ROUTES
SECTION DIST 8 TS 2024-1
VIDEO DETECTION SYSTEMS REPLACEMENT
TRAFFIC SIGNAL MODERNIZATION
VARIOUS COUNTIES
(MADISON, ST. CLAIR, & MARION)

C-98-043-24

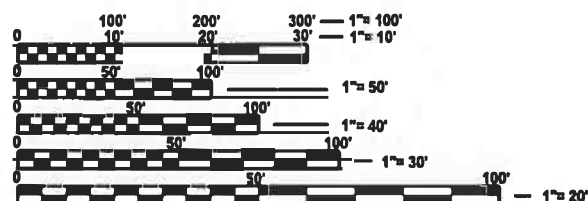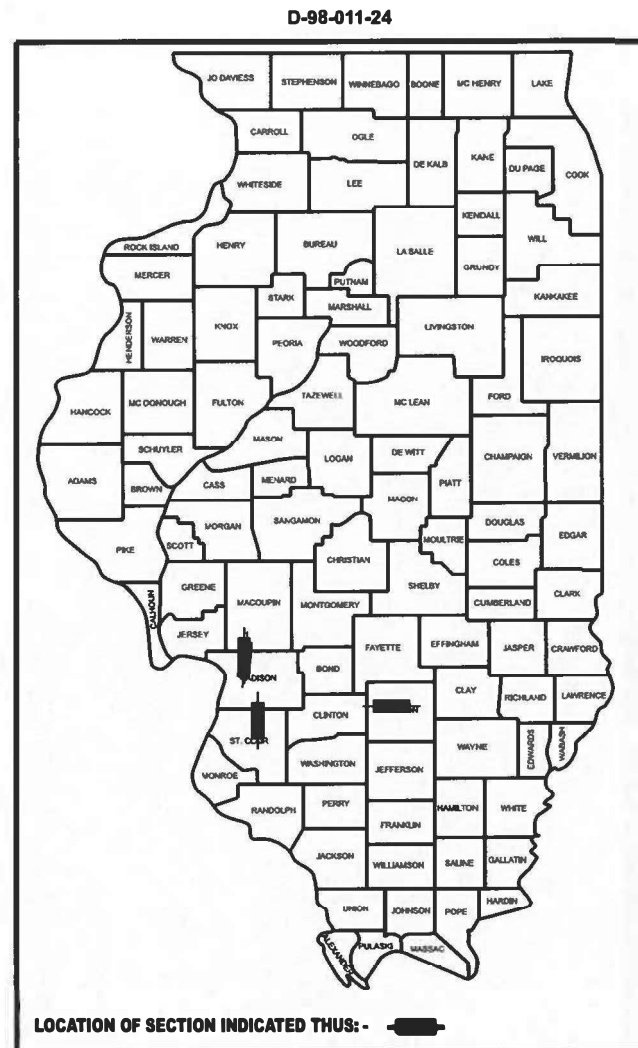


FULL SIZE PLANS HAVE BEEN PREPARED USING STANDARD ENGINEERING SCALES. REDUCED SIZED PLANS WILL NOT CONFORM TO STANDARD SCALES. IN MAKING MEASUREMENTS ON REDUCED PLANS, THE ABOVE SCALES MAY BE USED.

J.U.L.I.E.
JOINT UTILITY LOCATION INFORMATION FOR EXCAVATION
1-800-892-0123
OR 811

PROJECT ENGINEER : CHERYL KEPLAR
PROJECT MANAGER : RICHARD BARBEE

CONTRACT NO. 76T45

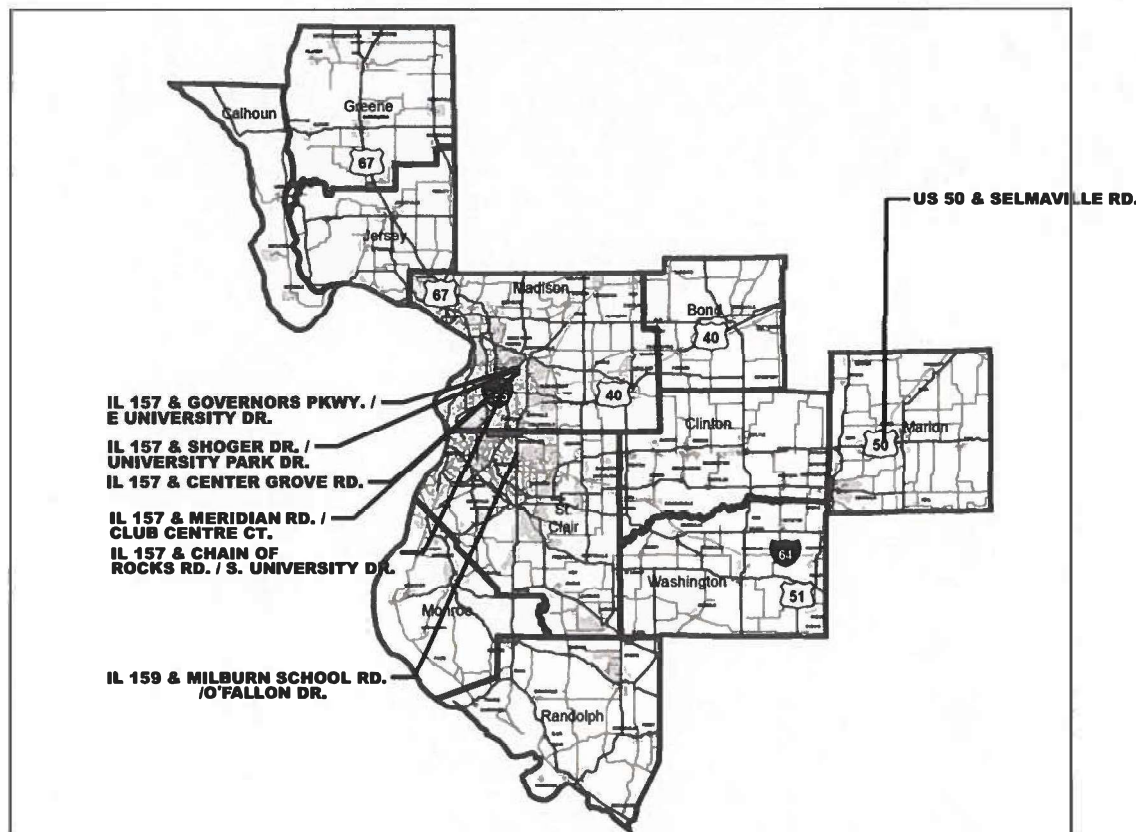

GROSS LENGTH = x.xx FT. = x.xxx MILE
NET LENGTH = x.xx FT. = x.xxx MILE

STATE OF ILLINOIS
DEPARTMENT OF TRANSPORTATION

SUBMITTED February 20 24
Richard Barbree
REGIONAL ENGINEER

March 22, 2024
[Signature]
ENGINEER OF DESIGN AND ENVIRONMENT

March 22, 2024
[Signature]
DIRECTOR OF HIGHWAYS PROJECT IMPLEMENTATION

PRINTED BY THE AUTHORITY
OF THE STATE OF ILLINOIS

GENERAL NOTES

1. UTILITIES KNOWN TO HAVE FACILITIES WITHIN THE PROJECT AREA:
 ADB COMPANIES
 AMEREN ILLINOIS
 AT&T ILLINOIS
 BUCKEYE PARTNERS L.P.-WOOD RIVER PIPELINE
 VILLAGE OF CASEYVILLE
 CHARTER COMMUNICATIONS, INC.
 CLEARWAVE FIBER LLC
 DEPARTMENT OF CENTRAL MANAGEMENT SERVICES
 COUNTRYMARK COOPERATIVE, LLP
 CITY OF EDWARDSVILLE
 EVERSTREAM GLC HOLDING COMPANY LLC
 I3 BROADBAND
 VERIZON BUSINESS
 METRO
 CITY OF O'FALLON
 CITY OF SALEM
 SOUTHERN ILLINOIS UNIVERSITY- EDWARDSVILLE
 TRI-COUNTY ELECTRIC COOPERATIVE, INC.
 WABASH COMMUNICATIONS
 WINDSTREAM KDL, INC.
2. NO SURVEY WAS PERFORMED FOR THIS PROJECT AND THE PLANS WERE CREATED USING MICROFILM AND FIELD MEASUREMENTS.
3. THE RESIDENT ENGINEER SHALL VERIFY THE EXISTENCE OF HIGHWAY LIGHTING, INTELLIGENT TRANSPORTATION SYSTEMS (I.T.S.) UTILITIES, AND/OR ELECTRICAL CABLES ASSOCIATED WITH TRAFFIC SIGNALS WITHIN THE PROJECT LIMITS. IF ANY OF THESE EXIST WITHIN THE PROJECT LIMITS, AND IF THESE ITEMS REQUIRE LOCATING, THE CONTRACTOR SHALL BE DIRECTED TO DO SO ACCORDING TO SECTION 803 OF THE STANDARD SPECIFICATIONS. THIS WORK SHALL BE PAID FOR ACCORDING TO ARTICLE 109.04 OF THE STANDARD SPECIFICATIONS.
4. THE DEPARTMENT STRONGLY ENCOURAGES THE PRIME CONTRACTOR AND THEIR APPROVED SUB-CONTRACTORS TO HIRE MINORITY, WOMEN AND DISADVANTAGED INDIVIDUALS FROM ITS FEDERALLY FUNDED HIGHWAY CONSTRUCTION CAREERS TRAINING PROGRAM (HCCTP) TO HELP MEET WORKFORCE AND TRAINEE GOALS. THIS PROGRAM IS TRAINING MINORITIES, WOMEN AND DISADVANTAGED INDIVIDUALS IN HIGHWAY CONSTRUCTION-RELATED SKILLS, E.G., MATH FOR THE TRADES, JOB READINESS, TECHNICAL SKILLS COURSEWORK (CARPENTRY, CONCRETE FLATWORK, BLUEPRINT READING, SITE PLANS, SITE WORK, TOOLS USE, ETC.) AND OSHA 10 HOUR CERTIFICATION, TO PREPARE THEM FOR A CAREER IN THE HIGHWAY CONSTRUCTION TRADES. GRADUATES ARE WELL-TRAINED AND READY TO BECOME PRODUCTIVE ENTRY-LEVEL CONSTRUCTION WORKERS. CONTACT THE DISTRICT 8 EEO OFFICE AT 618-346-3360 AND/OR THE HCCTP COORDINATOR AT 618-874-6528 TO LEARN MORE ABOUT THE PROGRAM AND FOR ASSISTANCE IN MEETING WORKFORCE AND TRAINEE GOALS.
5. IT SHALL BE THE CONTRACTOR'S RESPONSIBILITY TO VERIFY ALL DIMENSIONS AND CONDITIONS EXISTING IN THE FIELD PRIOR TO ORDERING MATERIALS AND BEGINNING CONSTRUCTION.
6. THE ILLINOIS DEPARTMENT SHALL BE NOTIFIED AT LEAST 72 HOURS PRIOR TO REPLACING OF AND TURNING ON THE CONTROLLER UNIT.
7. IT SHALL BE THE CONTRACTOR'S RESPONSIBILITY TO MAINTAIN THE EXISTING TRAFFIC SIGNAL INSTALLATION DURING THE WORK.

INDEX OF SHEETS

SHT NO.	DESCRIPTION
1	COVER SHEET
2	INDEX OF SHEET, HIGHWAY STANDARDS, COMMITMENTS, AND GENERAL NOTES
3	SUMMARY OF QUANTITIES
TRAFFIC SIGNAL PLANS	
4-5	IL 157 & CHAIN OF ROCKS RD. / S. UNIVERSITY DR.
6-7	IL 157 & CENTER GROVE RD.
8-9	IL 157 & SHOGER DR. / UNIVERSITY PARK DR.
10-11	IL 157 & GOVERNORS PKWY. / E. UNIVERSITY DR.
12-13	IL 157 & MERIDIAN RD.
14-15	IL 159 & MILBURN SCHOOL RD. / O'FALLON DR.
16-17	US 50 & SELMAVILLE RD.

COMMITMENTS
NONE

HIGHWAY STANDARDS

000001-08	STANDARD SYMBOLS, ABBREVIATIONS AND PATTERNS
001006	DECIMAL OF AN INCH AND OF A FOOT
701001-02	OFF-RD OPERATIONS, 2L, 2W, MORE THAN 15' (4.5 m) AWAY
701006-05	OFF-RD OPERATIONS, 2L, 2W, 15' (4.5 m) TO 24" (600 mm) FROM PAVEMENT EDGE
701101-05	OFF-RD OPERATIONS, MUTLILANE, 15' (4.5 m) TO 24" (600 mm) FROM PAVEMENT EDGE
701106-02	OFF-RD OPERATIONS, MUTLILANE, 15' (4.5 m) AWAY
701301-04	LANE CLOSURE, 2L, 2W, SHORT TIME OPERATIONS
701701-10	UBRAN LANE CLOSURE, MULTILANE INTERSECTION
701901-09	TRAFFIC CONTROL DEVICES
857001-01	STANDARD PHASE DESIGNATION DIAGRAMS AND PHASE SEQUENCES
862001-01	UNINTERRUPTABLE POWER SUPPLY (UPS)

STATE OF ILLINOIS
DEPARTMENT OF TRANSPORTATION

INDEX OF SHEETS, HIGHWAY STANDARDS
COMMITMENTS, AND GENERAL NOTES

SCALE: SHEET OF SHEETS STA. TO STA.

F.A. RTE.	SECTION	COUNTY	TOTAL SHEETS	SHEET NO.
VAR.	DIST 8 TS 2024-1	MADISON, ST. CLAIR, & WARREN	17	2
CONTRACT NO. 76T45				
ILLINOIS FED. AID PROJECT				


 
 
 
 
 
REV. - MS


MODEL: SQC-1 [Sheet]
 FILE NAME: c:\p\work\pwr\daniel.hopkins@illinois.gov\d092908\0876745-sht-SQC.dgn

CODE NO.	ITEM	UNIT	TOTAL QUANTITY	CONSTRUCTION CODE			
				100% STATE	Madison County	St. Clair County	Marion County
					TRAFFIC SIGNALS	TRAFFIC SIGNALS	TRAFFIC SIGNALS
					0021 URBAN	0021 URBAN	0021 URBAN
67100100	MOBILIZATION	L SUM	1	0.72	0.14	0.14	
70102635	TRAFFIC CONTROL AND PROTECTION, STANDARD 701701	L SUM	1	0.72	0.14	0.14	
85000200	MAINTENANCE OF EXISTING TRAFFIC SIGNAL INSTALLATION	EACH	7	5	1	1	
89502350	REMOVE AND REINSTALL ELECTRIC CABLE FROM CONDUIT	FOOT	4294	3112	582	600	
89502375	REMOVE EXISTING TRAFFIC SIGNAL EQUIPMENT	EACH	7	5	1	1	
X8891007	VIDEO DETECTION SYSTEM COMPLETE	EACH	7	5	1	1	

REV. - MS

USER NAME = daniel.hopkins	DESIGNED -	REVISED -	STATE OF ILLINOIS DEPARTMENT OF TRANSPORTATION	SUMMARY OF QUANTITIES			F.A. RTE.	SECTION	COUNTY	TOTAL SHEETS	SHEET NO.
PLOT SCALE = 0.16666633 / in.	DRAWN -	REVISED -					VAR.	DIST 8 TS 2024-1	MADISON, ST. CLAIR, & MARION	17	3
PLOT DATE = 1/23/2024	CHECKED -	REVISED -		SCALE:	SHEET OF SHEETS	STA. TO STA.	ILLINOIS FED. AID PROJECT CONTRACT NO. 76T45				
	DATE -	REVISED -									

EXISTING SEQUENCE OF OPERATION								
PHASE	1	2	3	4	5	6	7	8
MOVEMENT	 NB LT	 SB	 WB	 EB	 SB LT	 NB	NOT USED	NOT USED
CONCURRENT MOVEMENT PERMITTED	5 or 6	5 or 6	NONE	NONE	1 or 2	1 or 2	NOT USED	NOT USED

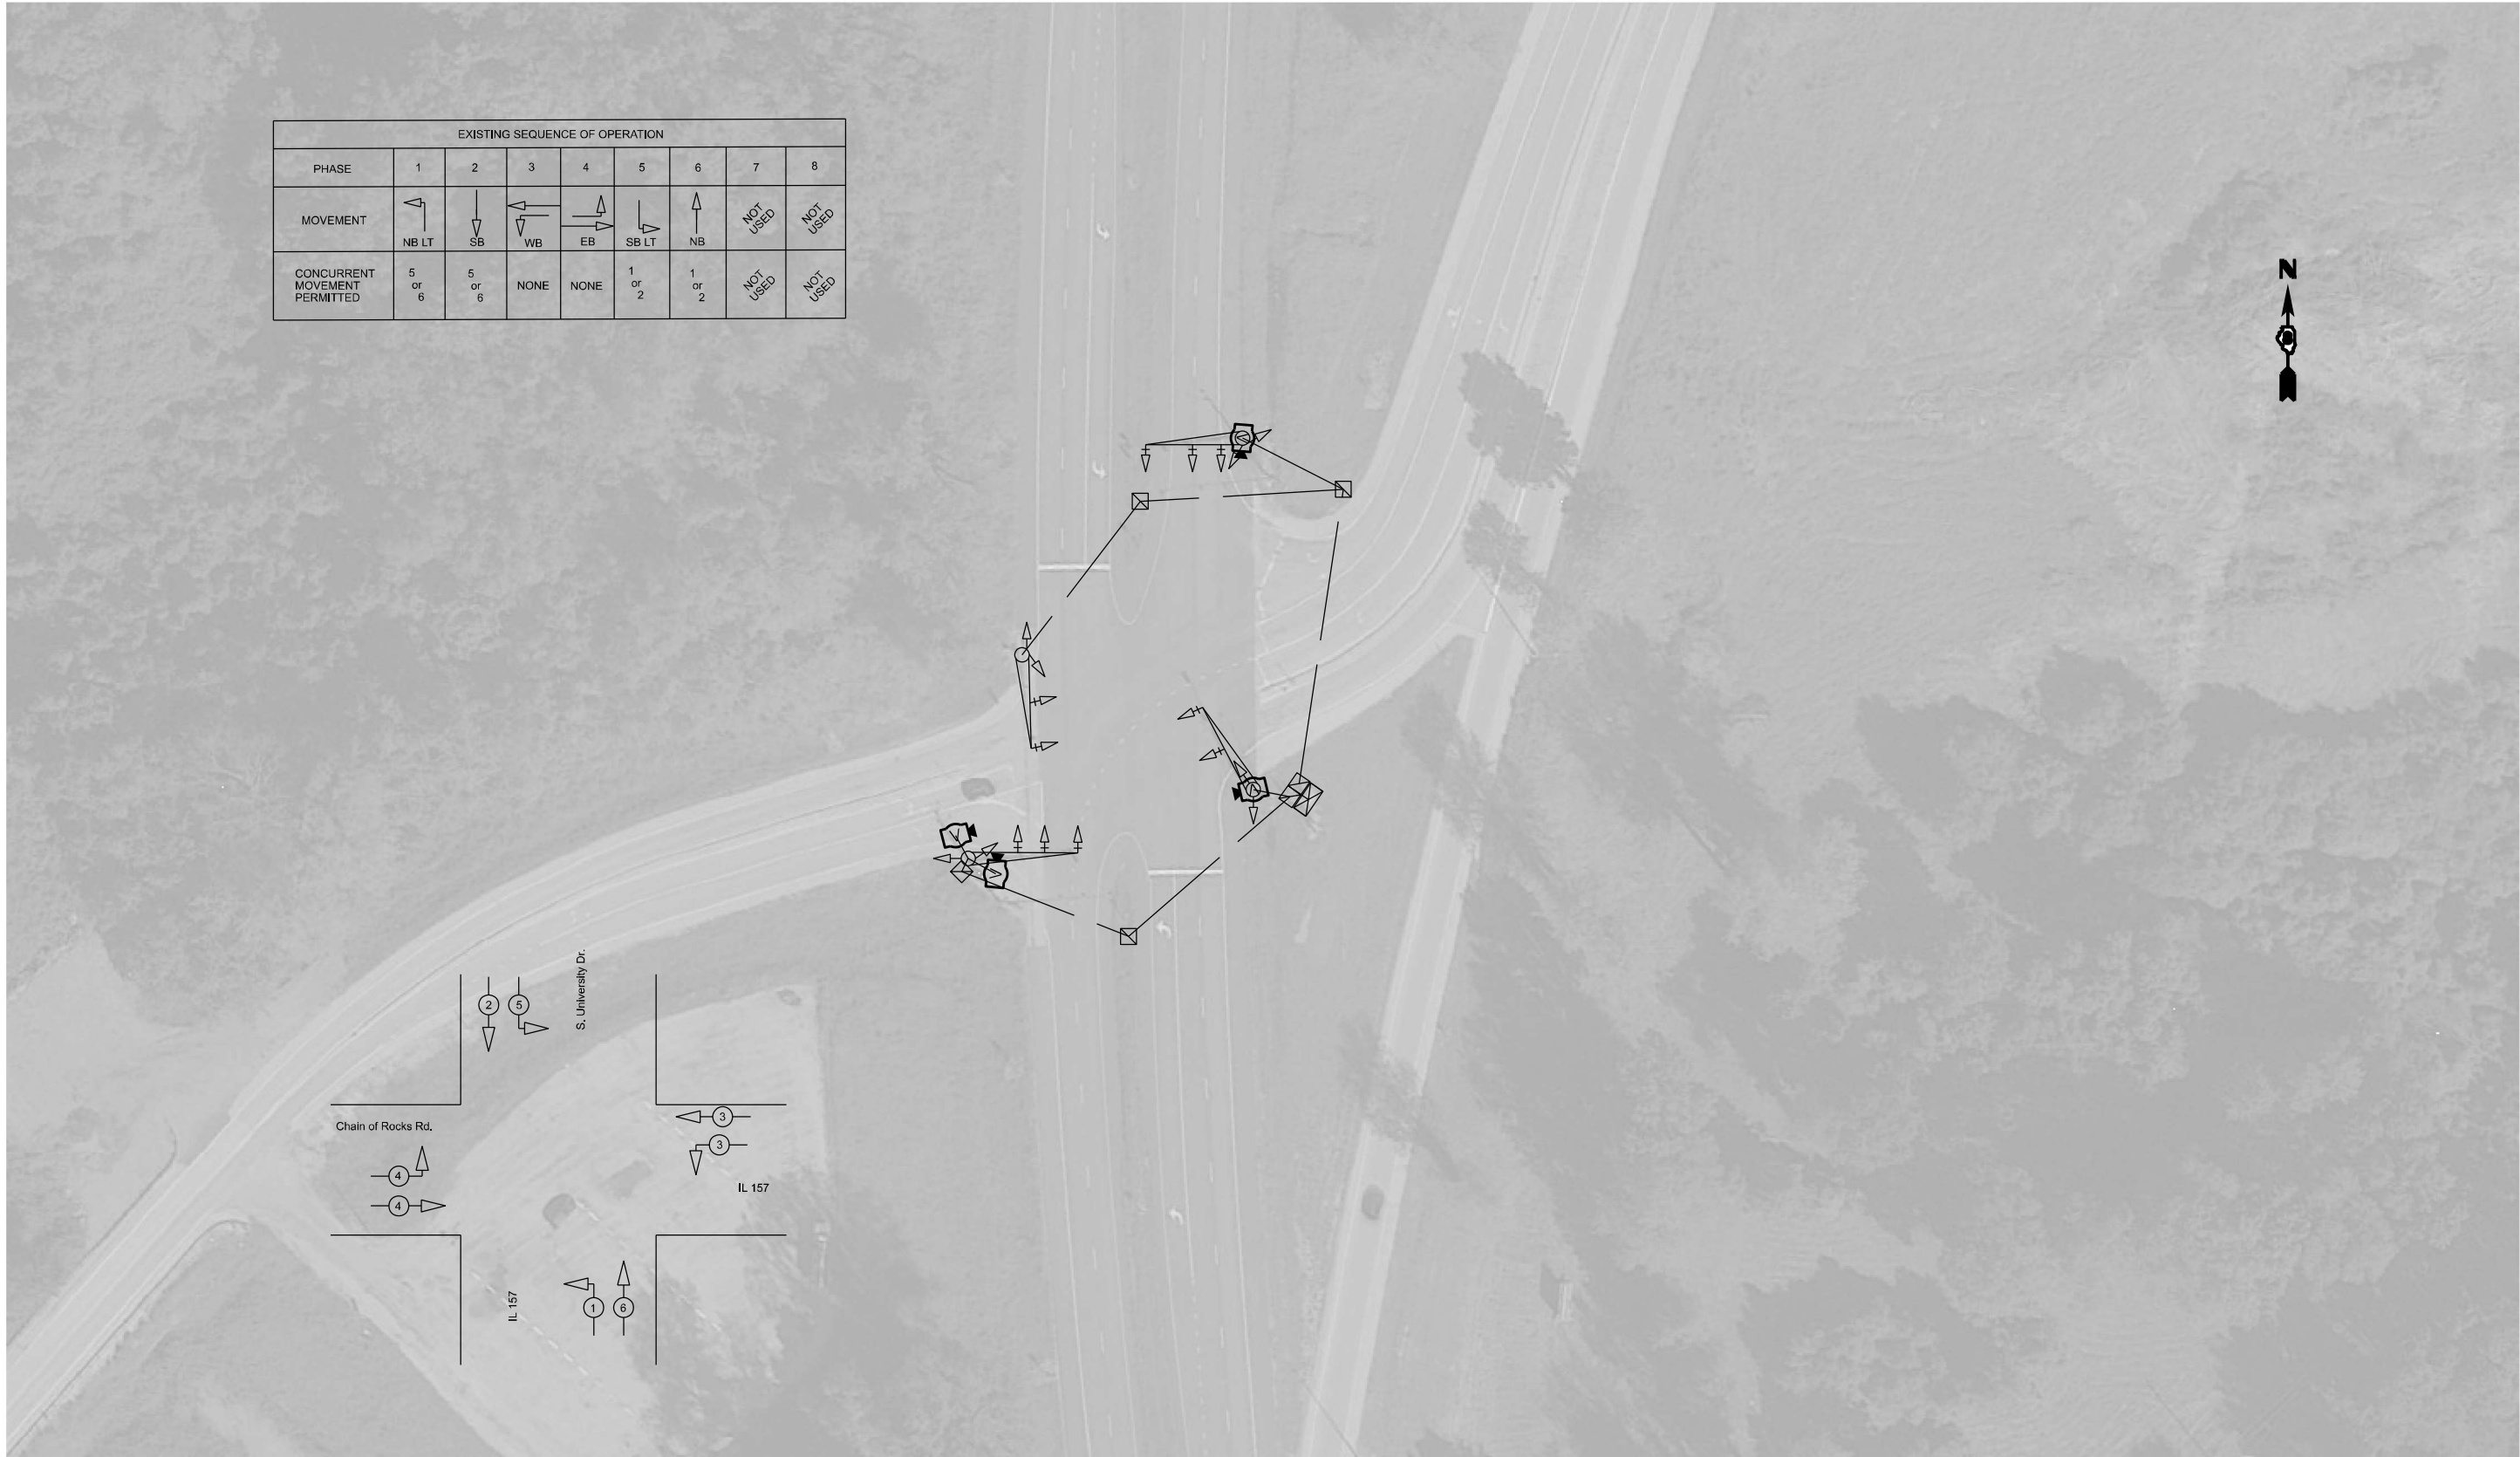

MODEL: chain of rocks_1 [Sheet]
 FILE NAME: c:\p\work\pav\tdaniel_hopkins@illinois.gov\09202080876745-sh1-clan.dgn

USER NAME = daniel_hopkins	DESIGNED -	REVISED -
	DRAWN -	REVISED -
PLOT SCALE = 0.16666833' / in.	CHECKED -	REVISED -
PLOT DATE = 1/23/2024	DATE -	REVISED -

STATE OF ILLINOIS
DEPARTMENT OF TRANSPORTATION

TRAFFIC SIGNAL MODIFICATION PLAN
IL 157 AT CHAIN OF ROCKS RD. / S. UNIVERSITY DR.

F.A. RTE.	SECTION	COUNTY	TOTAL SHEETS	SHEET NO.
VAR.	DIST 8 TS 2024-1	MADISON ST., CLAIR & MARION	17	4
CONTRACT NO. 76T45				
ILLINOIS FED. AID PROJECT				

SCALE: SHEET OF SHEETS STA. TO STA.


MODEL: Plan sheet [Sheet]
 FILE NAME: c:\pwworking\dwg\daniel_hopkins@illinois.gov\0902908\0876745-sh-dlan.dwg

Chain of Rocks Rd.

S. University Dr.

IL 157

IL 157

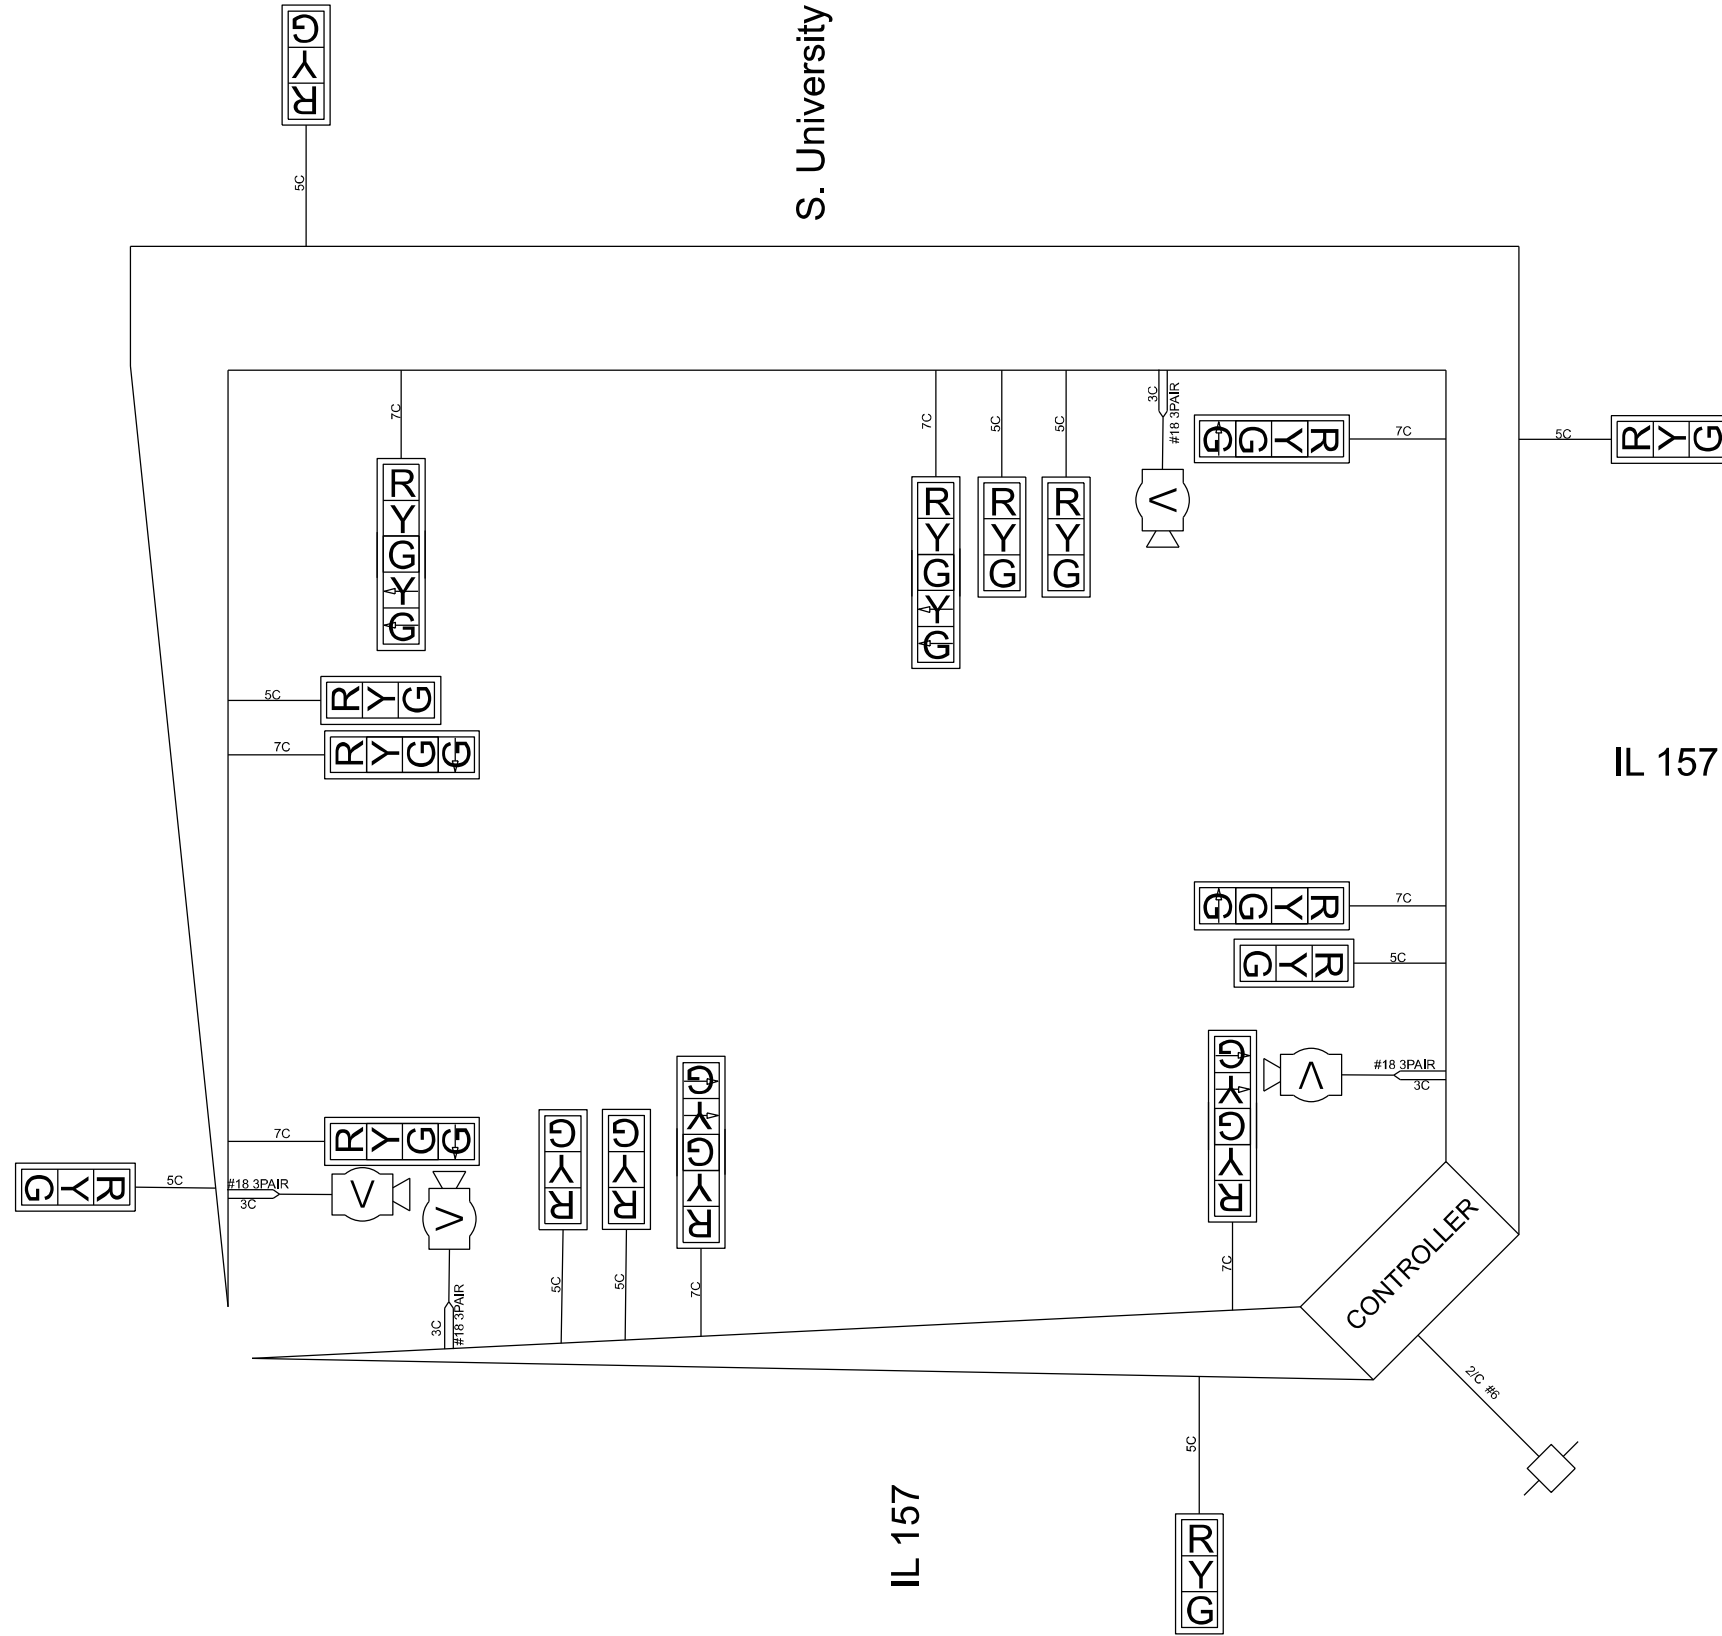

USER NAME = daniel.hopkins	DESIGNED -	REVISED -
DRAWN -	REVISED -	
PLOT SCALE = 0.16666633' / in.	CHECKED -	REVISED -
PLOT DATE = 1/23/2024	DATE -	REVISED -

STATE OF ILLINOIS
 DEPARTMENT OF TRANSPORTATION

CABLE DIAGRAM
 IL 157 AT CHAIN OF ROCKS RD. / S. UNIVERSITY DR.

SCALE: 1"=50' SHEET OF SHEETS STA. TO STA.

F.A. RTE.	SECTION	COUNTY	TOTAL SHEETS	SHEET NO.
VAR.	DIST 8 TS 2024-1	MADISON, ST. CLAIR, & MARION	17	5
CONTRACT NO. 76T45			ILLINOIS FED. AID PROJECT	

EXISTING SEQUENCE OF OPERATION								
PHASE	1	2	3	4	5	6	7	8
MOVEMENT	NB LT	SB	EB	WB	SB LT	NB	NOT USED	NOT USED
CONCURRENT MOVEMENT PERMITTED	5 or 6	5 or 6	NONE	NONE	1 or 2	1 or 2	NOT USED	NOT USED



MODEL: Plan sheet (Sheet)
 FILE NAME: c:\pwwork\w\tdaniel.hopkins@illinois.gov\0902080876145-shl-plan.dgn

USER NAME = daniel.hopkins	DESIGNED -	REVISED -
	DRAWN -	REVISED -
PLOT SCALE = 0.16666633' / in.	CHECKED -	REVISED -
PLOT DATE = 1/23/2024	DATE -	REVISED -


STATE OF ILLINOIS
DEPARTMENT OF TRANSPORTATION

TRAFFIC SIGNAL MODIFICATION PLAN
IL 157 AT CENTER GROVE RD.

SCALE: 1"=50' SHEET OF SHEETS STA. TO STA.

F.A. RTE.	SECTION	COUNTY	TOTAL SHEETS	SHEET NO.
VAR.	DIST 8 TS 2024-1	MADEIRA, ST. CLAIR, & MARION	17	6
CONTRACT NO. 76T45				
ILLINOIS FED. AID PROJECT				

MODEL: Plan sheet (Sheet)
 FILE NAME: c:\pwworking\dwg\daniel.hopkins@illinois.gov\0902908\0876745-sheet.dwg

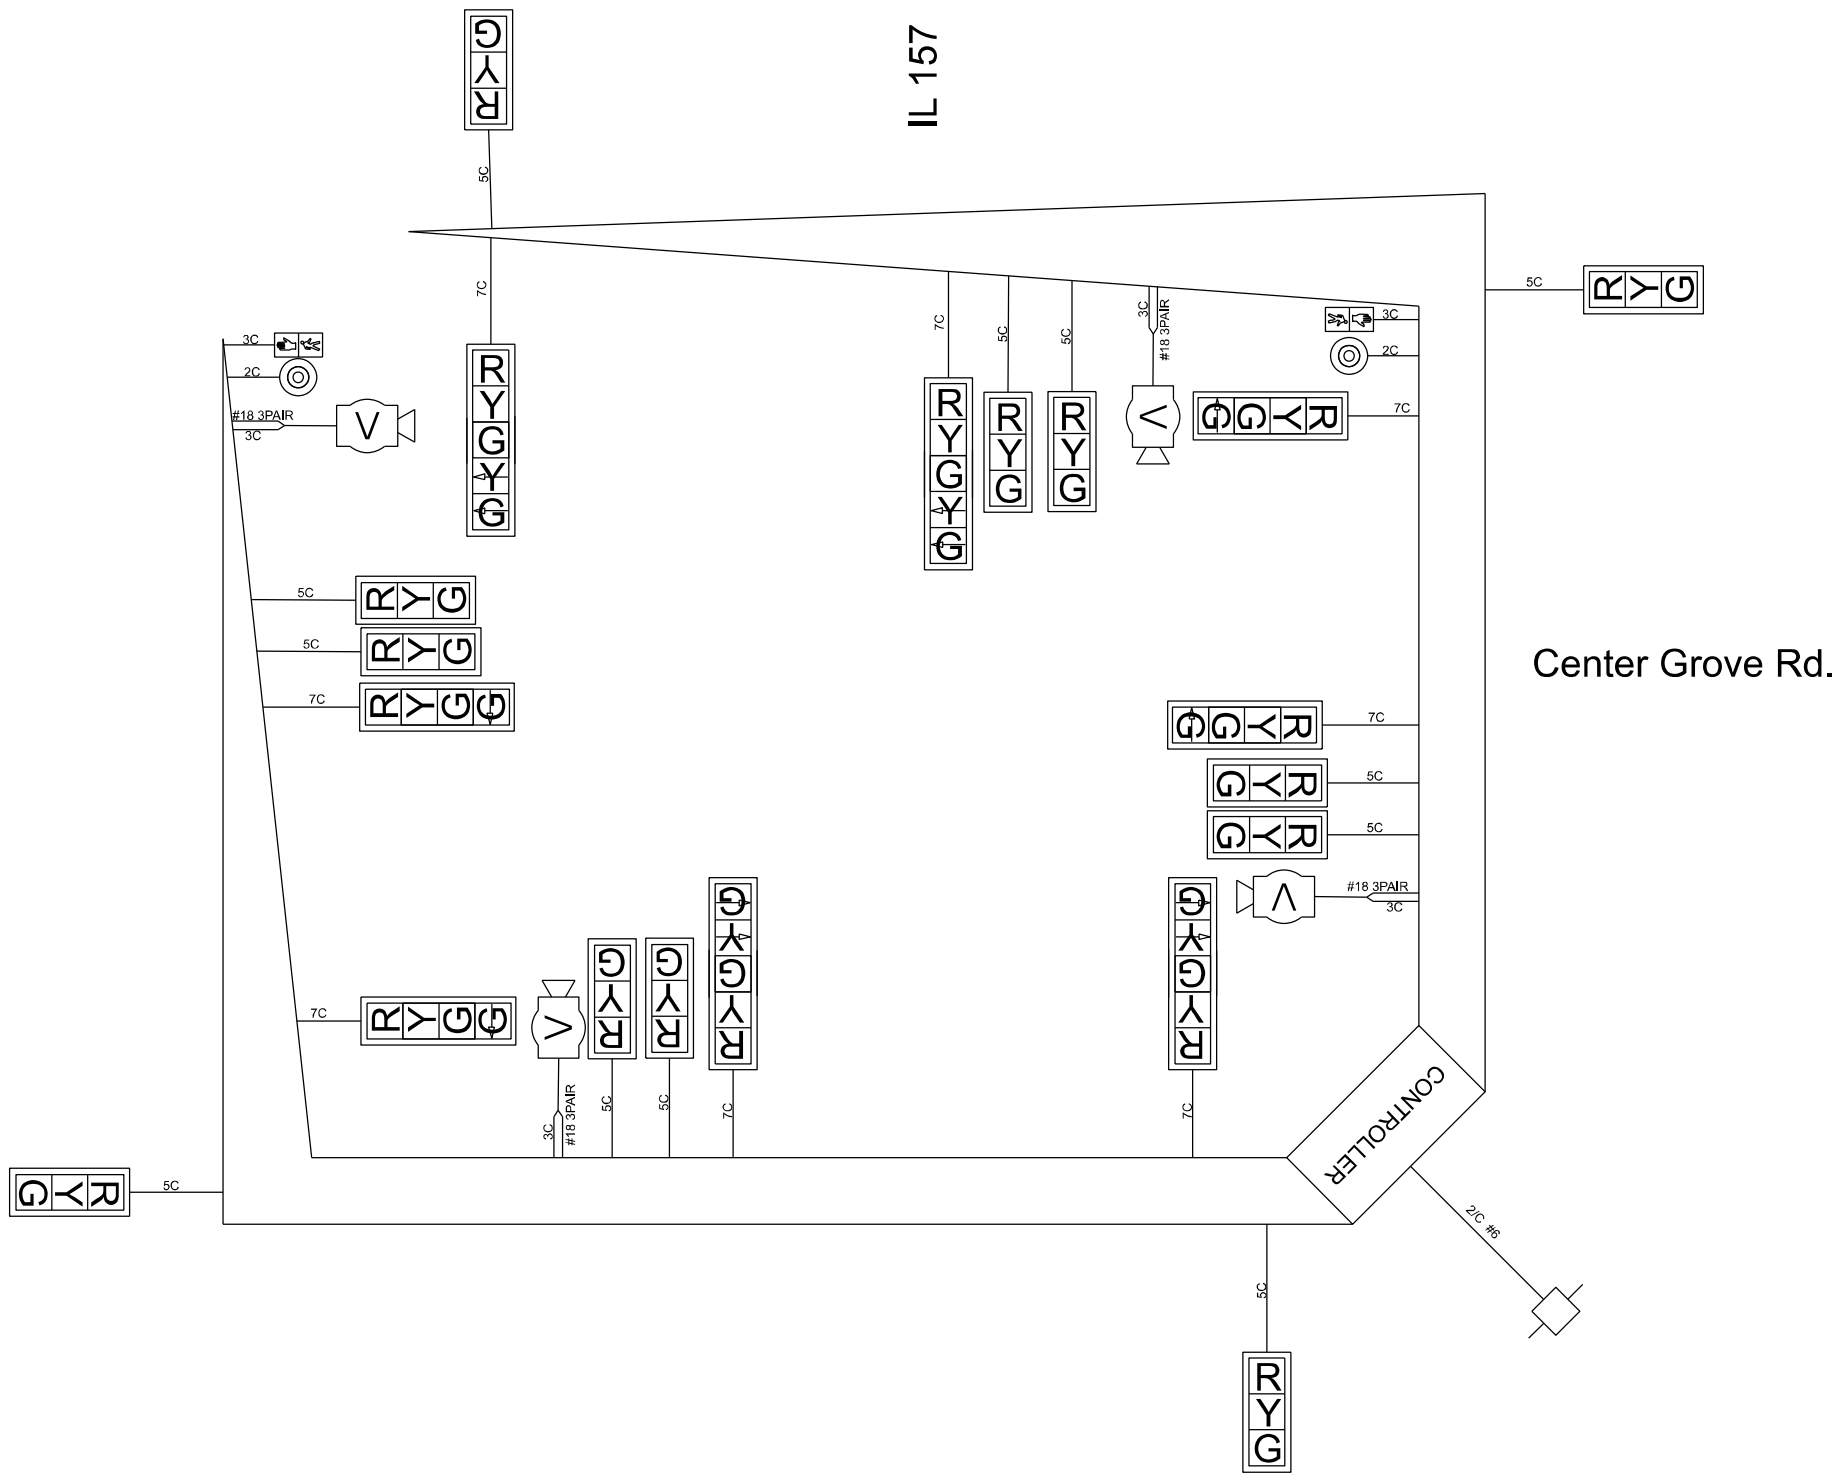

USER NAME = daniel.hopkins	DESIGNED -	REVISED -
	DRAWN -	REVISED -
PLOT SCALE = 0.16666833' / in.	CHECKED -	REVISED -
PLOT DATE = 1/23/2024	DATE -	REVISED -

**STATE OF ILLINOIS
 DEPARTMENT OF TRANSPORTATION**



**CABLE DIAGRAM
 IL 157 AT CENTER GROVE RD.**

SCALE: 1"=50' SHEET OF SHEETS STA. TO STA.

F.A. RTE.	SECTION	COUNTY	TOTAL SHEETS	SHEET NO.
VAR.	DIST 8 TS 2024-1	MADISON, ST. CLAIR, & MARION	17	7
CONTRACT NO. 76T45			ILLINOIS FED. AID PROJECT	



EXISTING SEQUENCE OF OPERATION								
PHASE	1	2	3	4	5	6	7	8
MOVEMENT								
	NB LT	SB	EB LT	WB	SB LT	NB	WB LT	EB
CONCURRENT MOVEMENT PERMITTED	5 or 6	5 or 6	7 or 8	7 or 8	1 or 2	1 or 2	3 or 4	3 or 4

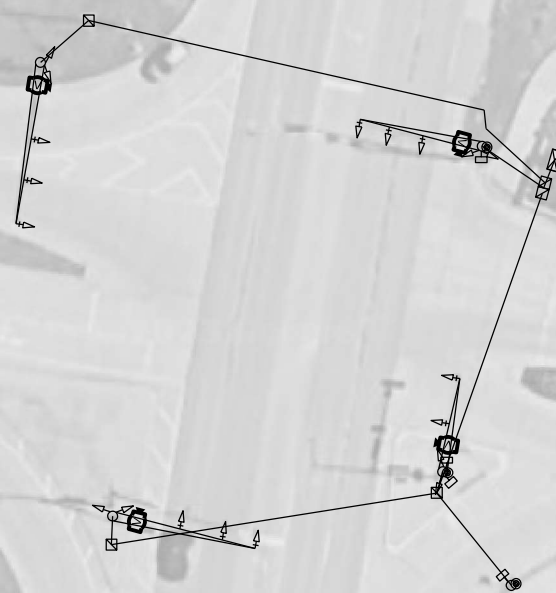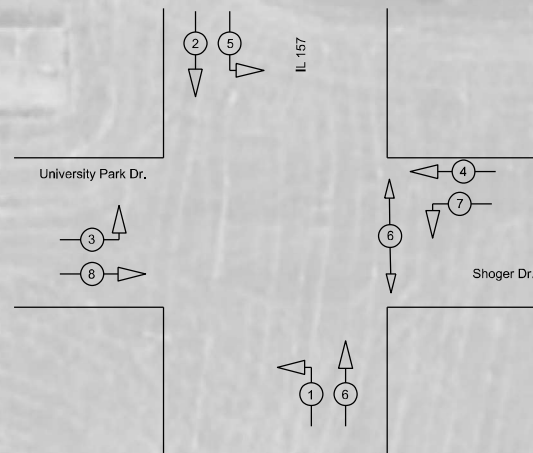

MODEL: Plan_sht8 (Sheet)
 FILE NAME: c:\pwworkspace\daniel_hopkins@illinois.gov\090290808\08761745-sht-plan.dgn

USER NAME = daniel_hopkins	DESIGNED -	REVISED -
	DRAWN -	REVISED -
PLOT SCALE = 0.16666633' / in.	CHECKED -	REVISED -
PLOT DATE = 1/23/2024	DATE -	REVISED -

STATE OF ILLINOIS
DEPARTMENT OF TRANSPORTATION

TRAFFIC SIGNAL MODIFICATION PLAN
IL 157 AT SHOGER DR. / UNIVERSITY PARK DR.

SCALE: 1"=50' SHEET OF SHEETS STA. TO STA.


F.A. RTE.	SECTION	COUNTY	TOTAL SHEETS	SHEET NO.
VAR.	DIST 8 TS 2024-1	MADISON ST., CLAIR, & MARION	17	8
CONTRACT NO. 76T45			ILLINOIS FED. AID PROJECT	



University Park Dr.

IL 157

Shoger Dr.

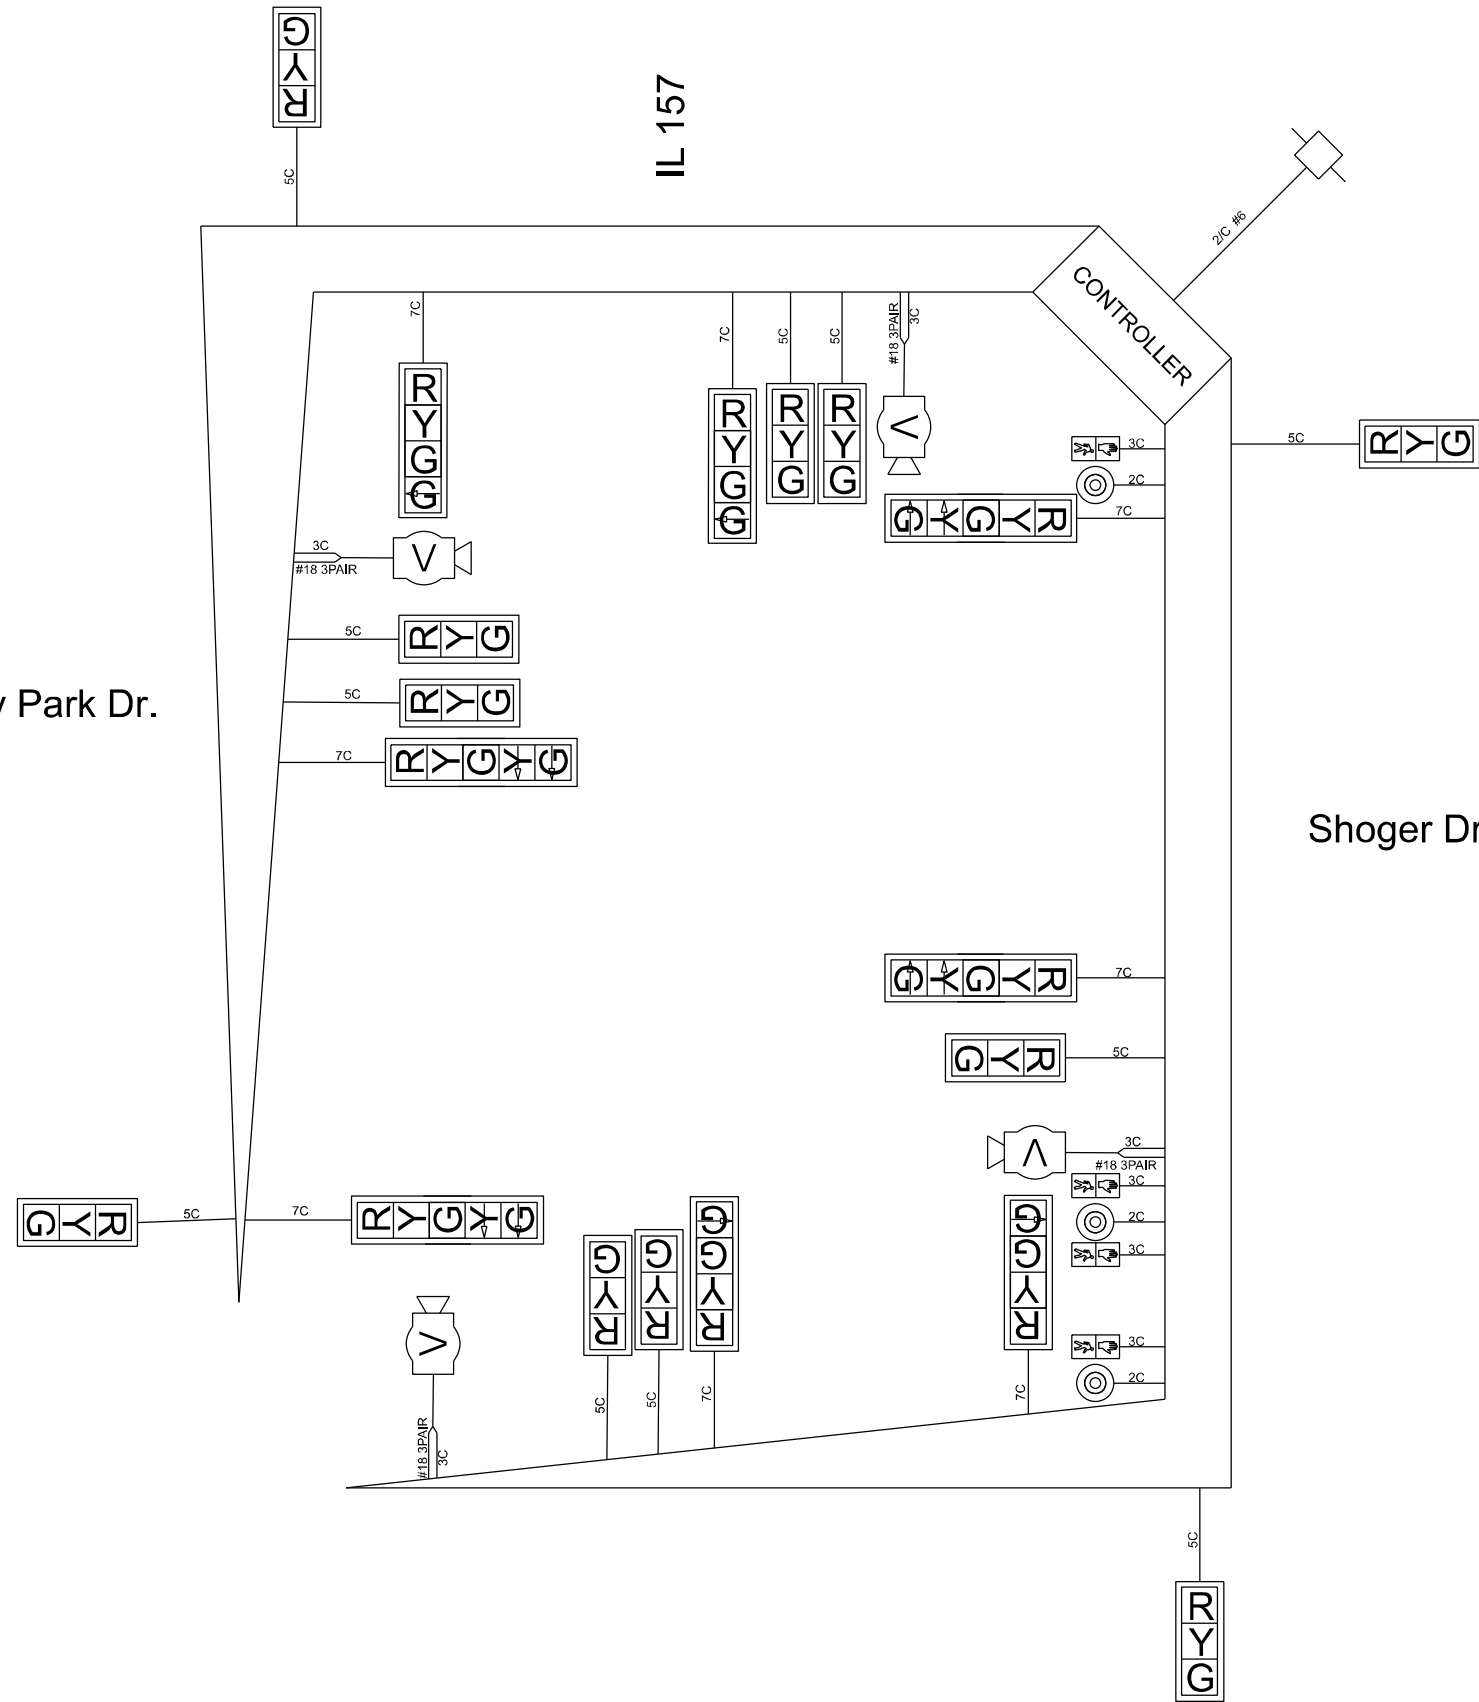

MODEL: Plan sheet (Sheet)
FILE NAME: c:\pwworking\daniel.hopkins@illinois.gov\d0902908\0876745-sh-dlan.dgn

USER NAME = daniel.hopkins	DESIGNED -	REVISED -
	DRAWN -	REVISED -
PLOT SCALE = 0.16666633' / in.	CHECKED -	REVISED -
PLOT DATE = 1/23/2024	DATE -	REVISED -

STATE OF ILLINOIS
DEPARTMENT OF TRANSPORTATION

CABLE DIAGRAM
IL 157 AT SHOGER DR. / UNIVERSITY PARK DR.

SCALE: 1"=50' SHEET OF SHEETS STA. TO STA.

F.A. RTE.	SECTION	COUNTY	TOTAL SHEETS	SHEET NO.
VAR.	DIST 8 TS 2024-1	MADISON, ST. CLAIR, & MARION	17	9
CONTRACT NO. 76T45				
ILLINOIS FED. AID PROJECT				

EXISTING SEQUENCE OF OPERATION								
PHASE	1	2	3	4	5	6	7	8
MOVEMENT								
	NB LT	SB	WB LT	EB	SB LT	NB	EB LT	WB
CONCURRENT MOVEMENT PERMITTED	5 or 6	5 or 6	7 or 8	7 or 8	1 or 2	1 or 2	3 or 4	3 or 4

* PEDSTRIAN MOVEMENT ON ACTUATION ONLY



MODEL: Plan sheet10 (Sheet)
FILE NAME: c:\p\work\wv\10\daniel_hopkins@illinois.gov\090208080876745-sh1-clan.dgn

USER NAME = daniel_hopkins	DESIGNED -	REVISED -
	DRAWN -	REVISED -
PLOT SCALE = 0.16666633' / in.	CHECKED -	REVISED -
PLOT DATE = 1/23/2024	DATE -	REVISED -

**STATE OF ILLINOIS
DEPARTMENT OF TRANSPORTATION**


**TRAFFIC SIGNAL MODIFICATION PLAN
IL 157 AT GOVERNORS PKWY. / E. UNIVERSITY DR.**

SCALE: 1"=50' SHEET OF SHEETS STA. TO STA.

F.A. RTE.	SECTION	COUNTY	TOTAL SHEETS	SHEET NO.
VAR.	DIST 8 TS 2024-1	MADISON ST., CLAIR & MARION	17	10
CONTRACT NO. 76T45				
ILLINOIS FED. AID PROJECT				

MODEL: Plan sheet11 (Sheet)
 FILE NAME: c:\p\work\project\daniel.hopkins@illinois.gov\0902908\0876745-sheet11.dgn

E. University Dr.

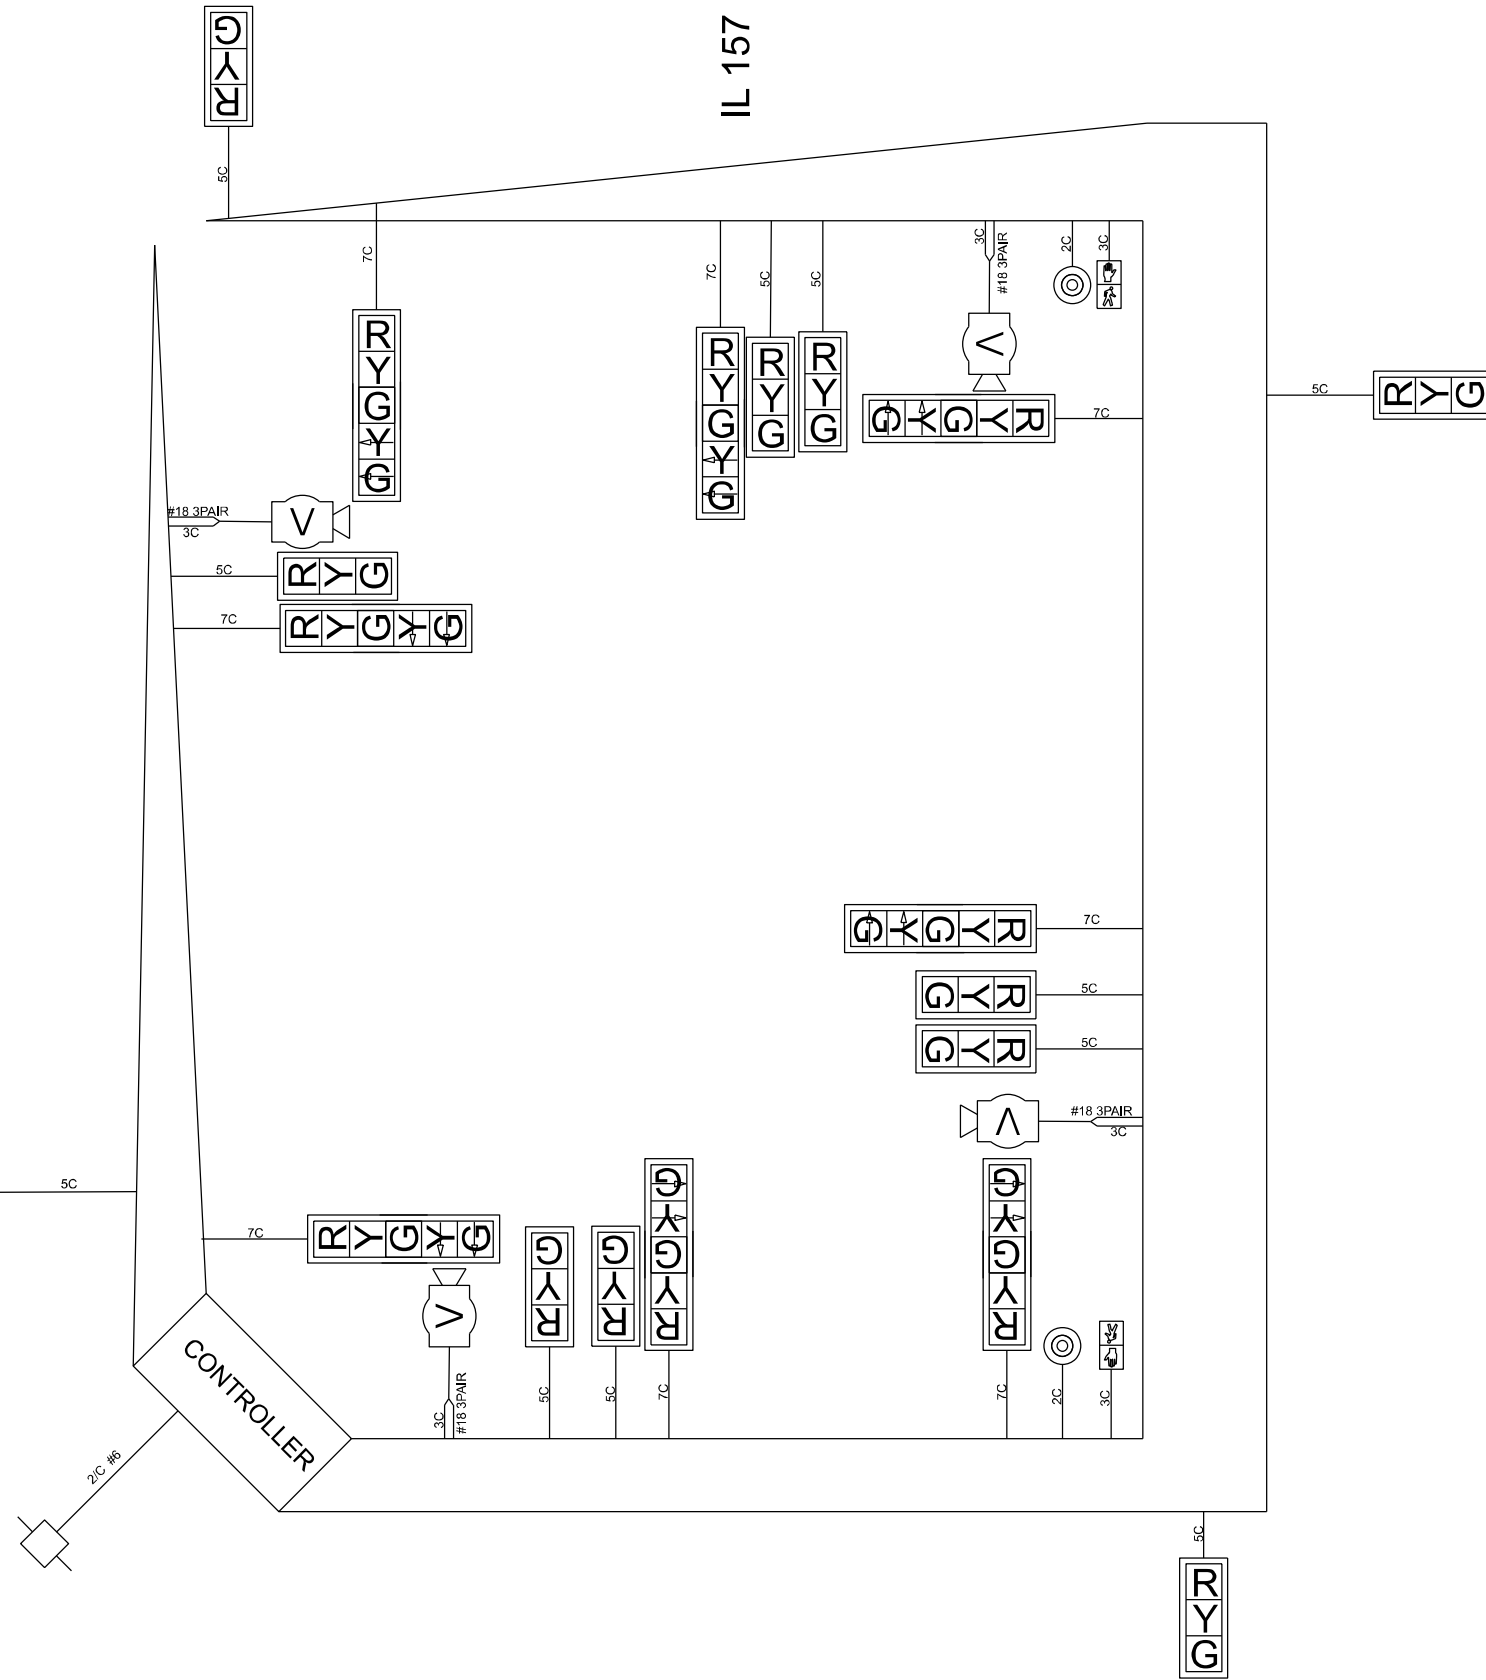

Governors Pkwy.


USER NAME = daniel.hopkins	DESIGNED -	REVISED -
	DRAWN -	REVISED -
PLOT SCALE = 0.16666633' / in.	CHECKED -	REVISED -
PLOT DATE = 1/23/2024	DATE -	REVISED -

STATE OF ILLINOIS
 DEPARTMENT OF TRANSPORTATION

CABLE DIAGRAM
 IL 157 AT GOVERNORS PKWY. / E. UNIVERSITY DR.

SCALE: 1"=50' SHEET OF SHEETS STA. TO STA.

F.A. RTE.	SECTION	COUNTY	TOTAL SHEETS	SHEET NO.
VAR.	DIST 8 TS 2024-1	MADISON ST., CLAIR, & MARION	17	11
CONTRACT NO. 76T45			ILLINOIS FED. AID PROJECT	

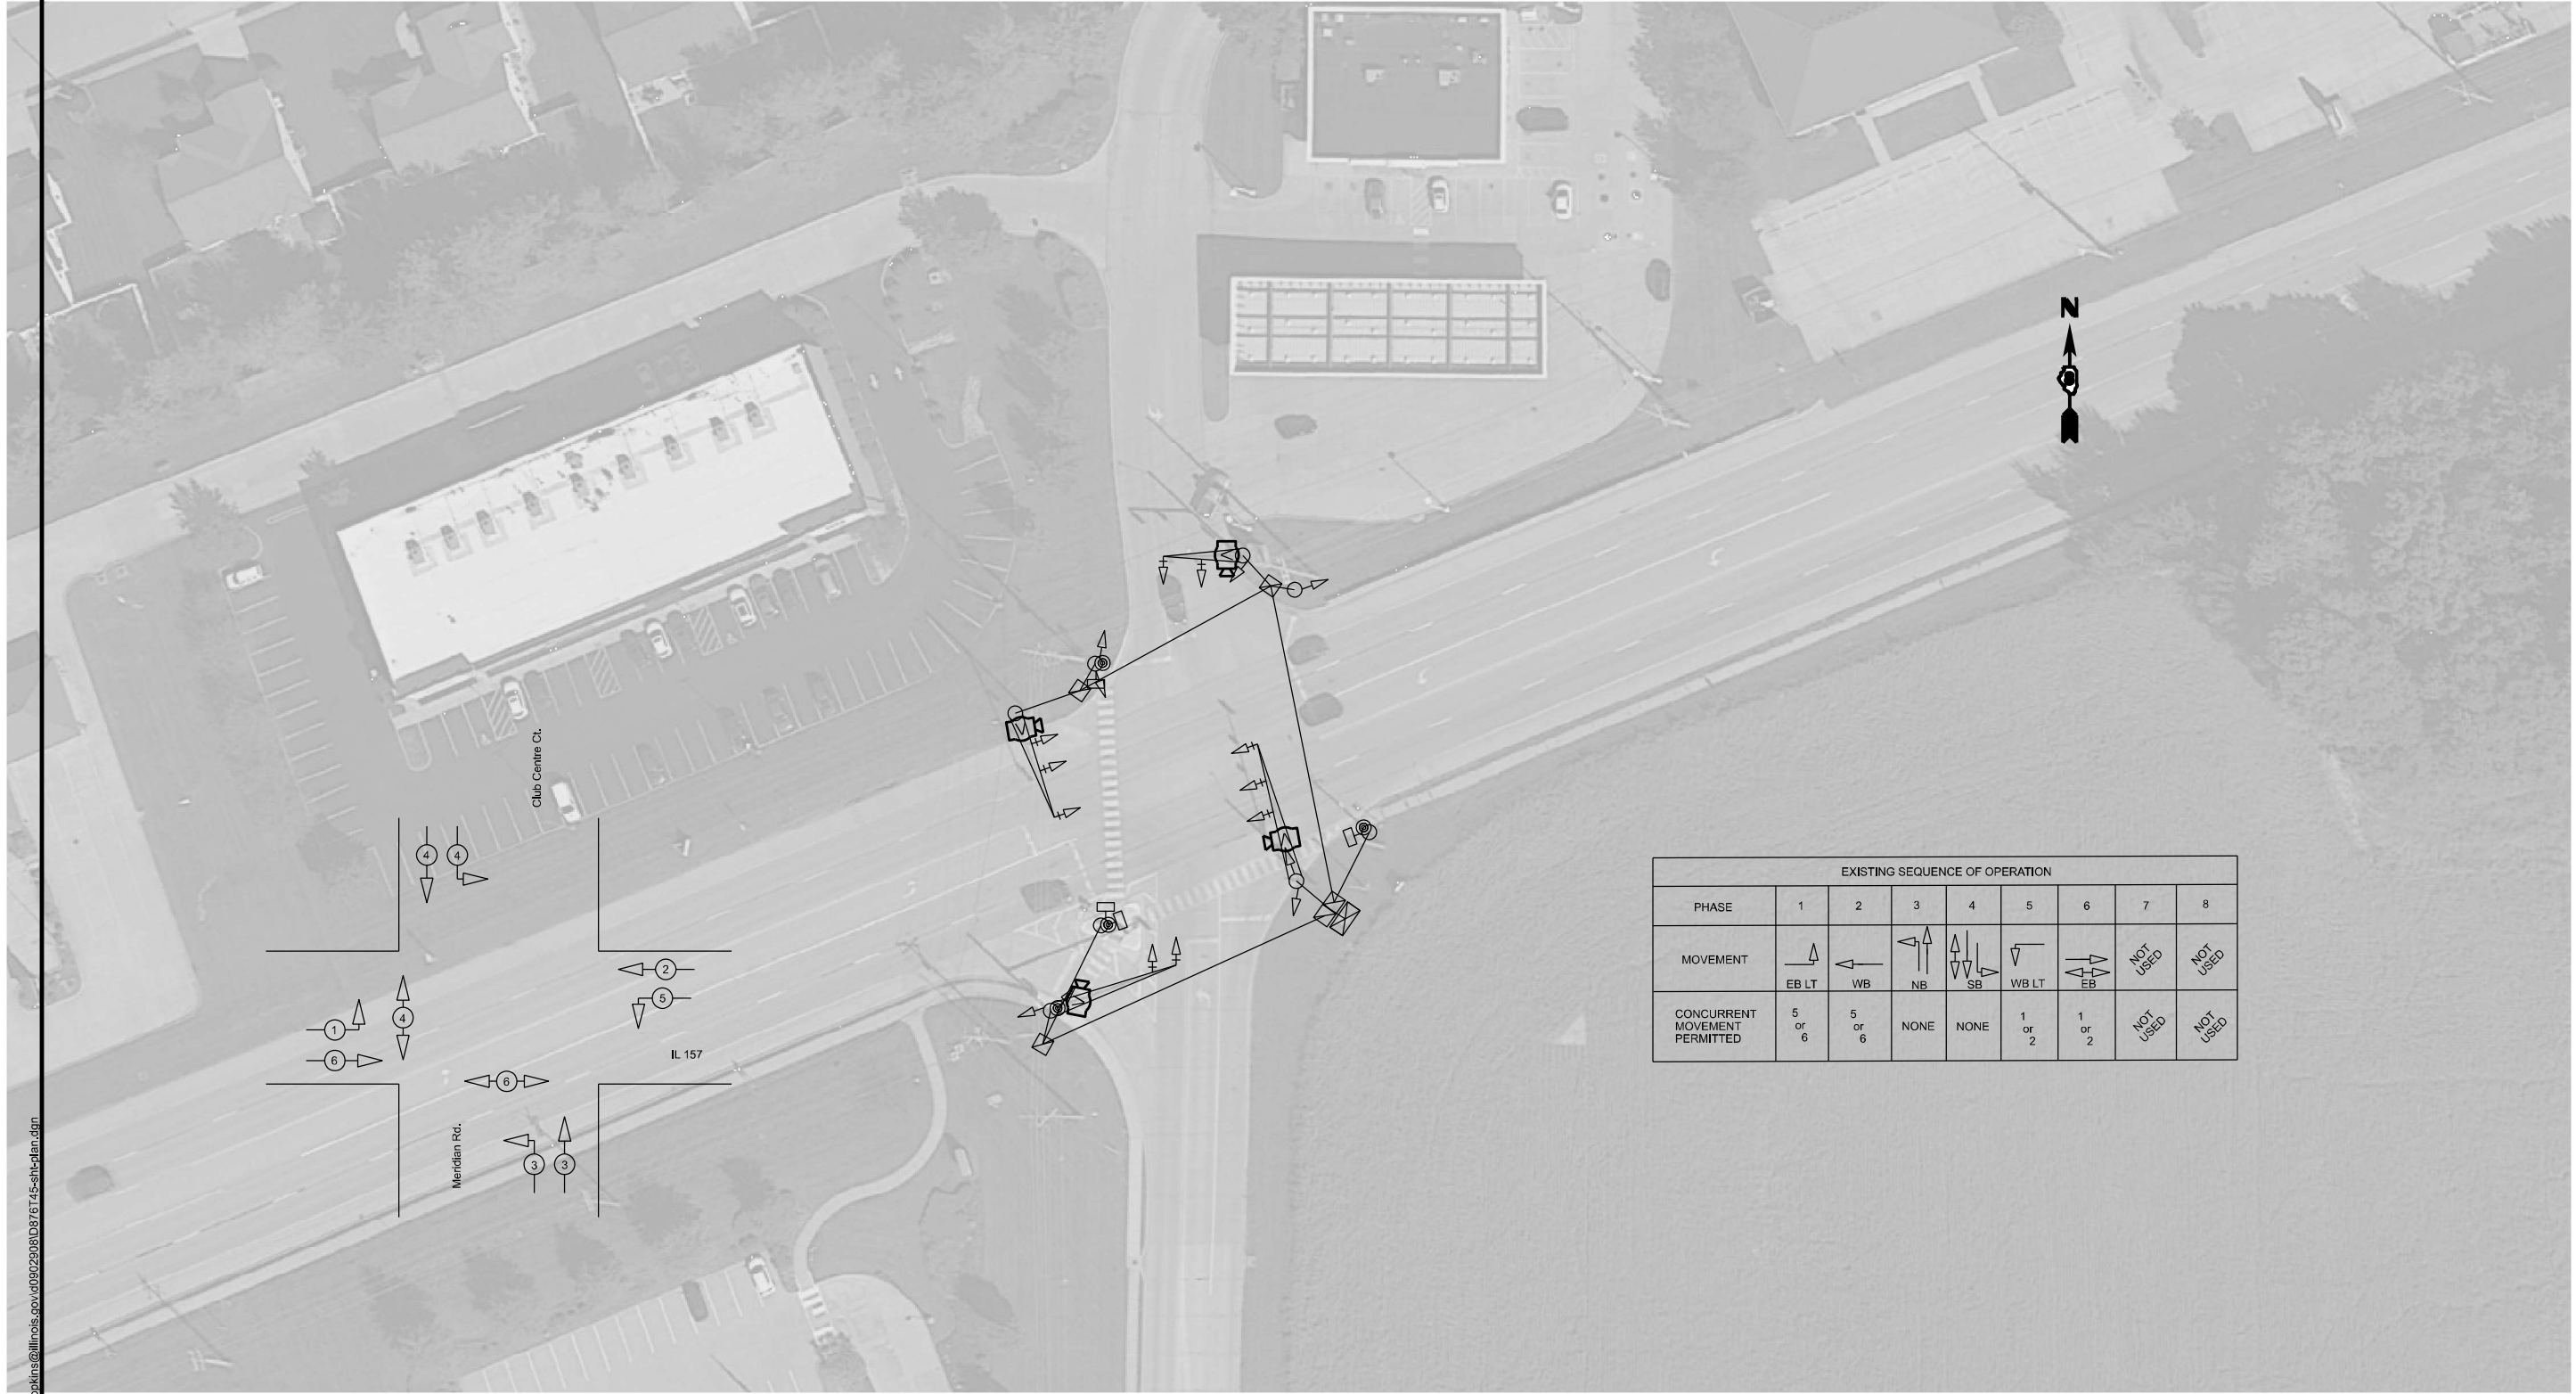

EXISTING SEQUENCE OF OPERATION								
PHASE	1	2	3	4	5	6	7	8
MOVEMENT	EB LT	WB	NB	SB	WB LT	EB	NOT USED	NOT USED
CONCURRENT MOVEMENT PERMITTED	5 or 6	5 or 6	NONE	NONE	1 or 2	1 or 2	NOT USED	NOT USED

MODEL: Plan sheet (Sheet)
 FILE NAME: c:\pwworking\dwg\daniel.hopkins@illinois.gov\090290808\0876145-sh-1-plan.dwg

USER NAME = daniel.hopkins	DESIGNED -	REVISED -
	DRAWN -	REVISED -
PLOT SCALE = 0.16666633' / in.	CHECKED -	REVISED -
PLOT DATE = 1/23/2024	DATE -	REVISED -


STATE OF ILLINOIS
DEPARTMENT OF TRANSPORTATION

TRAFFIC SIGNAL MODIFICATION PLAN
IL 157 AT MERIDIAN RD. / CLUB CENTER CT.

SCALE: 1"=50' SHEET OF SHEETS STA. TO STA.

F.A. RTE.	SECTION	COUNTY	TOTAL SHEETS	SHEET NO.
VAR.	DIST 8 TS 2024-1	MADISON, ST. CLAIR, & MARION	17	12
CONTRACT NO. 76T45				
ILLINOIS FED. AID PROJECT				

MODEL: Plan sheet (Sheet)
 FILE NAME: c:\pwworking\daniel.hopkins@illinois.gov\0902908\0876745-sh-ct-dia.dwg

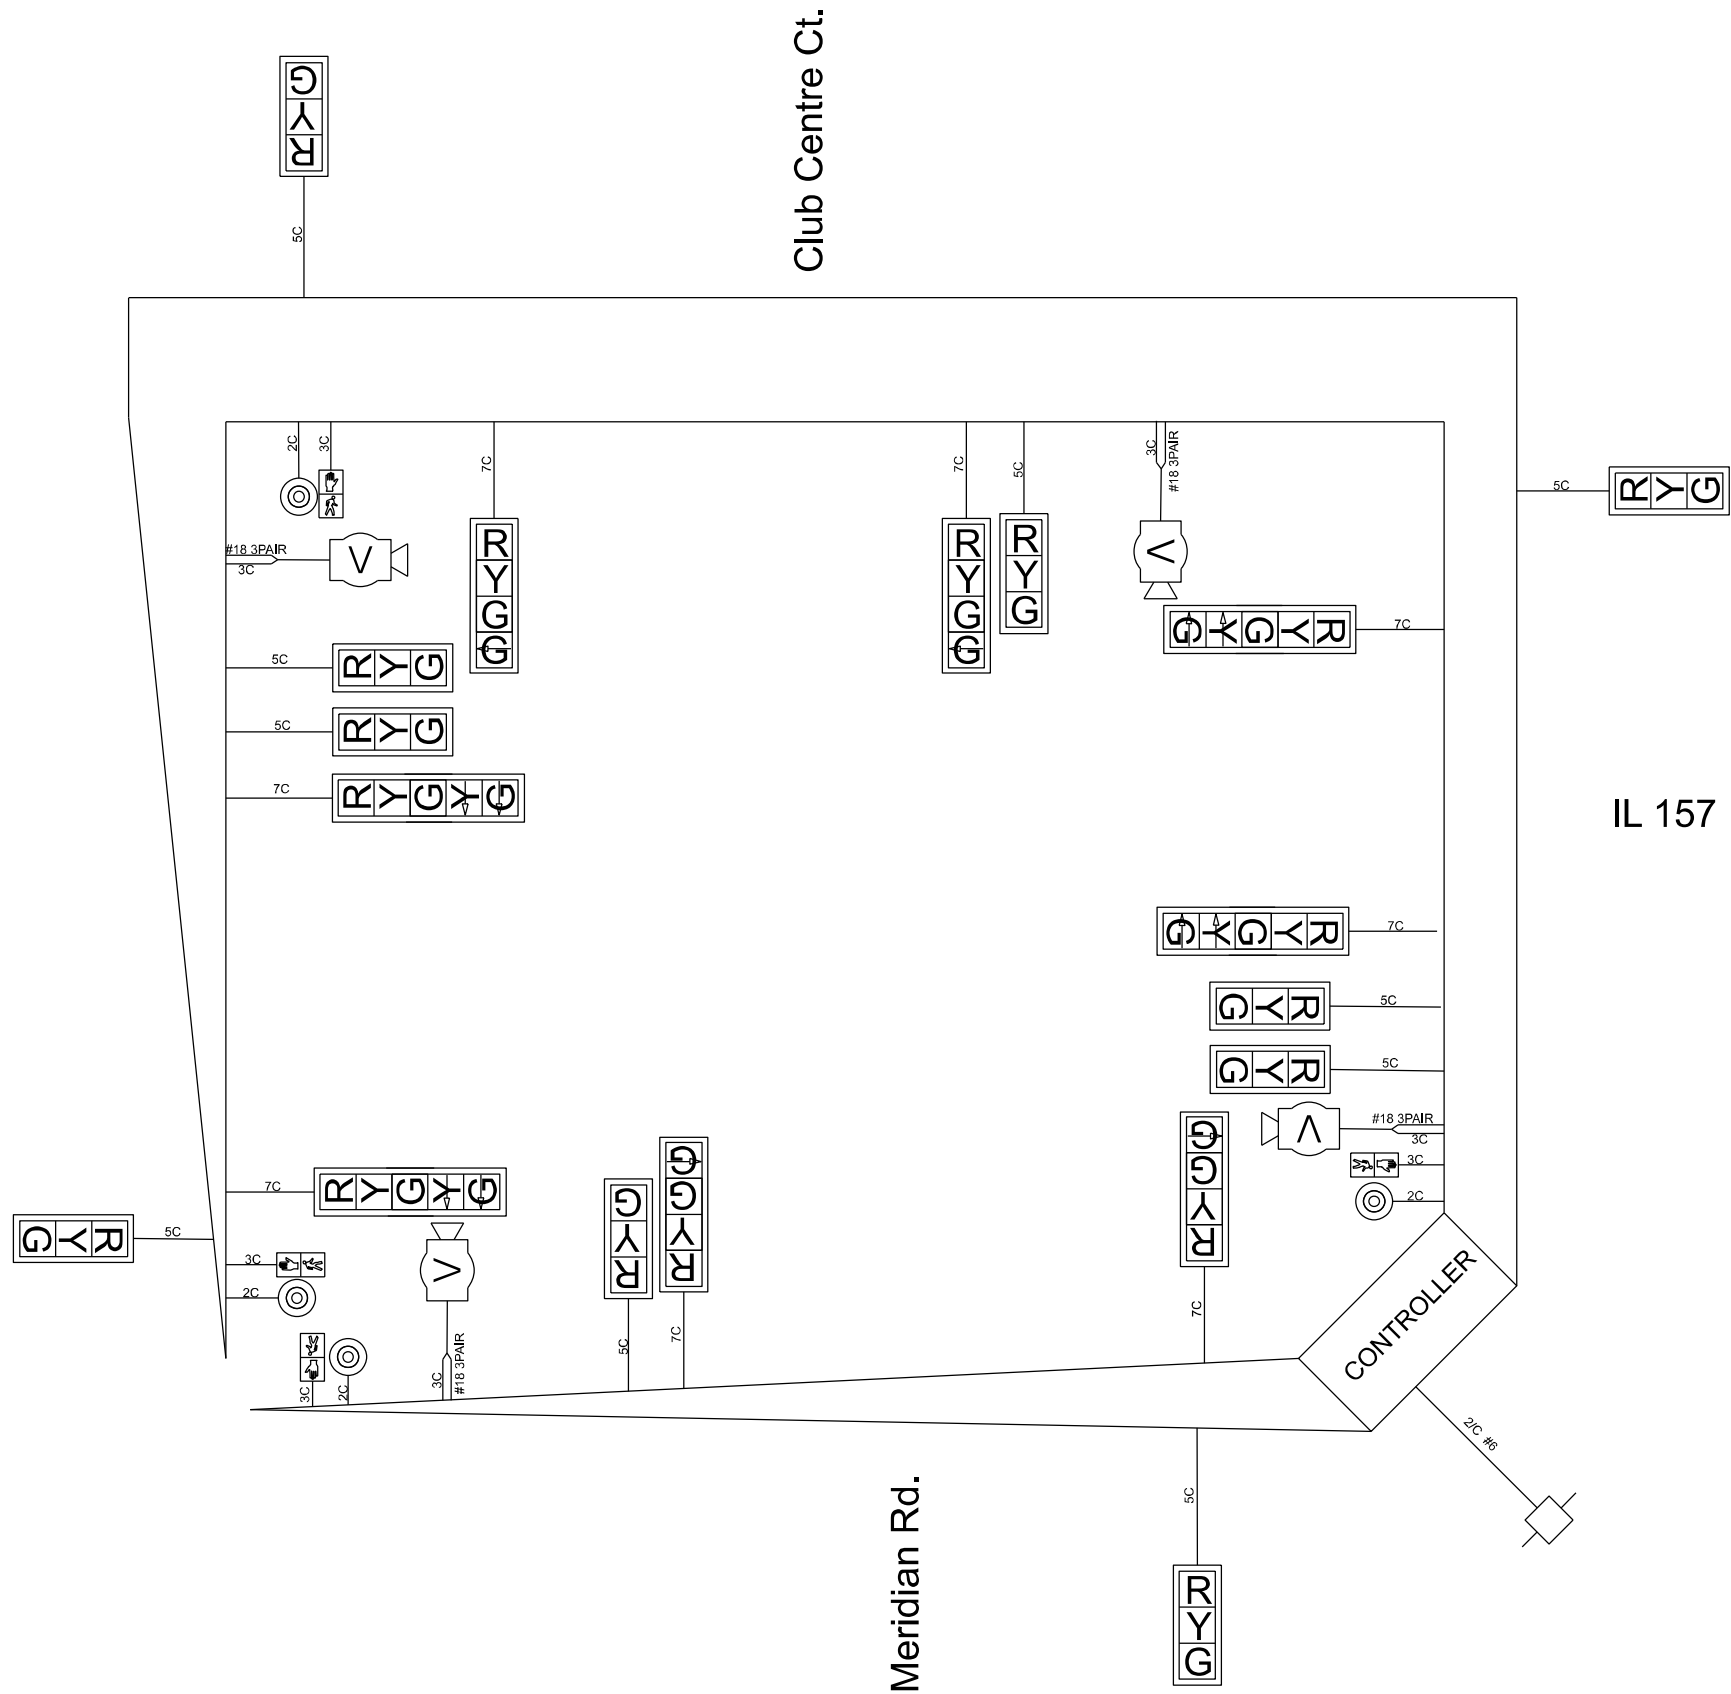

USER NAME = daniel.hopkins	DESIGNED -	REVISED -
	DRAWN -	REVISED -
PLOT SCALE = 0.16666633' / in.	CHECKED -	REVISED -
PLOT DATE = 1/23/2024	DATE -	REVISED -


STATE OF ILLINOIS
 DEPARTMENT OF TRANSPORTATION

CABLE DIAGRAM
 IL 157 AT MERIDIAN RD. / CLUB CENTER CT.

SCALE: 1"=50' SHEET OF SHEETS STA. TO STA.

F.A. RTE.	SECTION	COUNTY	TOTAL SHEETS	SHEET NO.
VAR.	DIST 8 TS 2024-1	MADISON ST. CLAIR & MARION	17	13
CONTRACT NO. 76T45				
ILLINOIS FED. AID PROJECT				

EXISTING SEQUENCE OF OPERATION								
PHASE	1	2	3	4	5	6	7	8
MOVEMENT	SB LT	NB	EB	WB	NB LT	SB	NOT USED	NOT USED
CONCURRENT MOVEMENT PERMITTED	5 or 6	5 or 6	NONE	NONE	1 or 2	1 or 2	NOT USED	NOT USED

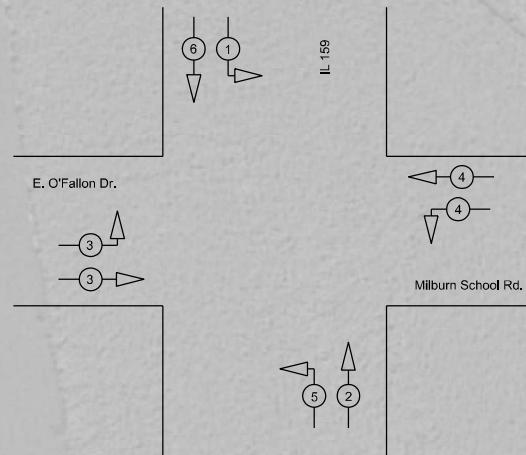

MODEL: Plan sheet (Sheet)
 FILE NAME: c:\p\work\wv\tdaniel_hopkins@illinois.gov\0902208\0876745-sh-ctlan.dgn

USER NAME = daniel_hopkins	DESIGNED -	REVISED -
	DRAWN -	REVISED -
PLOT SCALE = 0.16666633' / in.	CHECKED -	REVISED -
PLOT DATE = 1/23/2024	DATE -	REVISED -

STATE OF ILLINOIS
DEPARTMENT OF TRANSPORTATION

TRAFFIC SIGNAL MODIFICATION PLAN
IL 159 AT MILBURN SCHOOL RD. / E. O'FALLON DR.


SCALE: 1"=50' SHEET OF SHEETS STA. TO STA.

F.A. RTE.	SECTION	COUNTY	TOTAL SHEETS	SHEET NO.
VAR.	DIST 8 TS 2024-1	MADISON, ST. CLAIR, & MARION	17	14
CONTRACT NO. 76T45				
ILLINOIS FED. AID PROJECT				

E. O'Fallon Dr.

IL 159

Milburn School Rd.

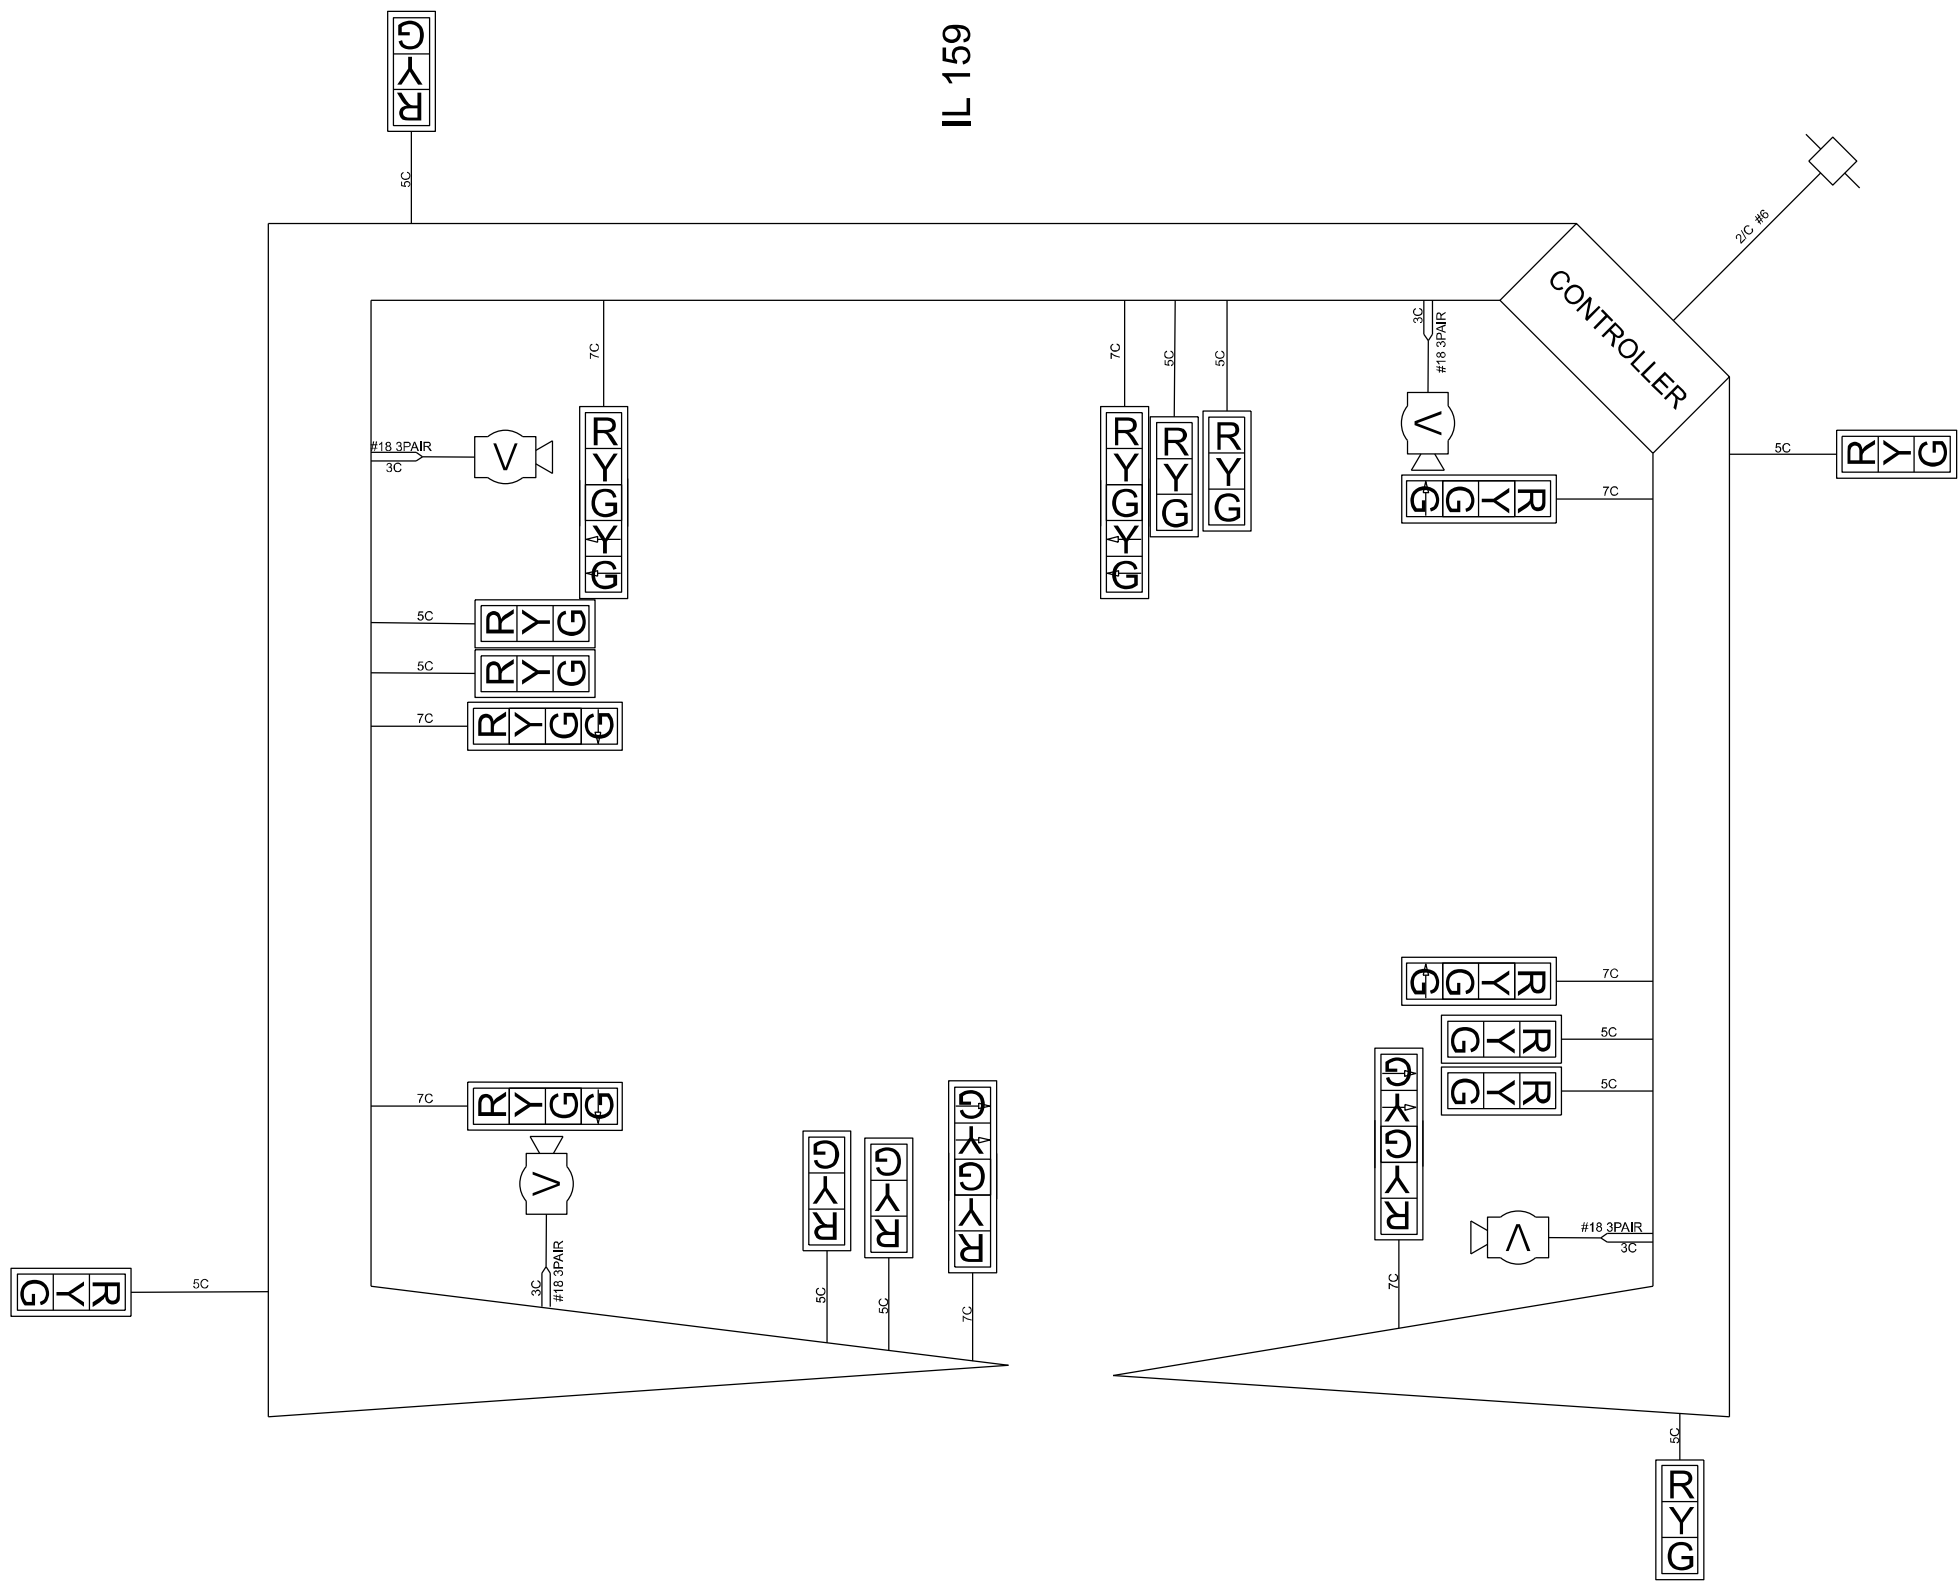

MODEL: Plan sheet19 (Sheet)
 FILE NAME: c:\p\work\wvictor\daniel_hopkins@illinois.gov\0902908\0876745-sh1-clan.dgn

USER NAME = daniel.hopkins	DESIGNED -	REVISED -
	DRAWN -	REVISED -
PLOT SCALE = 0.16666633' / in.	CHECKED -	REVISED -
PLOT DATE = 1/23/2024	DATE -	REVISED -

STATE OF ILLINOIS
DEPARTMENT OF TRANSPORTATION

CABLE DIAGRAM IL 159 AT MILBURN SCHOOL RD. / E. O'FALLON DR.			
SCALE: 1"=50'	SHEET	OF SHEETS	STA. TO STA.

F.A. RTE.	SECTION	COUNTY	TOTAL SHEETS	SHEET NO.
VAR.	DIST 8 TS 2024-1	MADISON ST., CLAIR, & MARION	17	15
ILLINOIS FED. AID PROJECT			CONTRACT NO. 76T45	



EXISTING SEQUENCE OF OPERATION								
PHASE	1	2	3	4	5	6	7	8
MOVEMENT	WB LT	EB	NOT USED	SB	EB LT	WB	NOT USED	NB
CONCURRENT MOVEMENT PERMITTED	5 or 6	5 or 6	NOT USED	NONE	1 or 2	1 or 2	NOT USED	NONE

Overlap D = Phases 1,5,8

MODEL: Plan sht20 (Sheet)
 FILE NAME: c:\p\work\wtd\daniel_hopkins@illinois.gov\0902208\08761745-sht-plan.dgn

USER NAME = daniel.hopkins	DESIGNED -	REVISED -
	DRAWN -	REVISED -
PLOT SCALE = 0.16666633' / in.	CHECKED -	REVISED -
PLOT DATE = 1/23/2024	DATE -	REVISED -


STATE OF ILLINOIS
DEPARTMENT OF TRANSPORTATION

TRAFFIC SIGNAL MODIFICATION PLAN
US 50 AT SELMAVILLE RD.

SCALE: 1"=50' SHEET OF SHEETS STA. TO STA.

F.A. RTE.	SECTION	COUNTY	TOTAL SHEETS	SHEET NO.
VAR.	DIST 8 TS 2024-1	MADISON ST., CLAIR, & MARION	17	16
CONTRACT NO. 76T45				
ILLINOIS FED. AID PROJECT				

MODEL: Plan_sht21 (Sheet)
 FILE NAME: c:\pwworking\daniel.hopkins@illinois.gov\d09290808761745-sht-clan.dgn

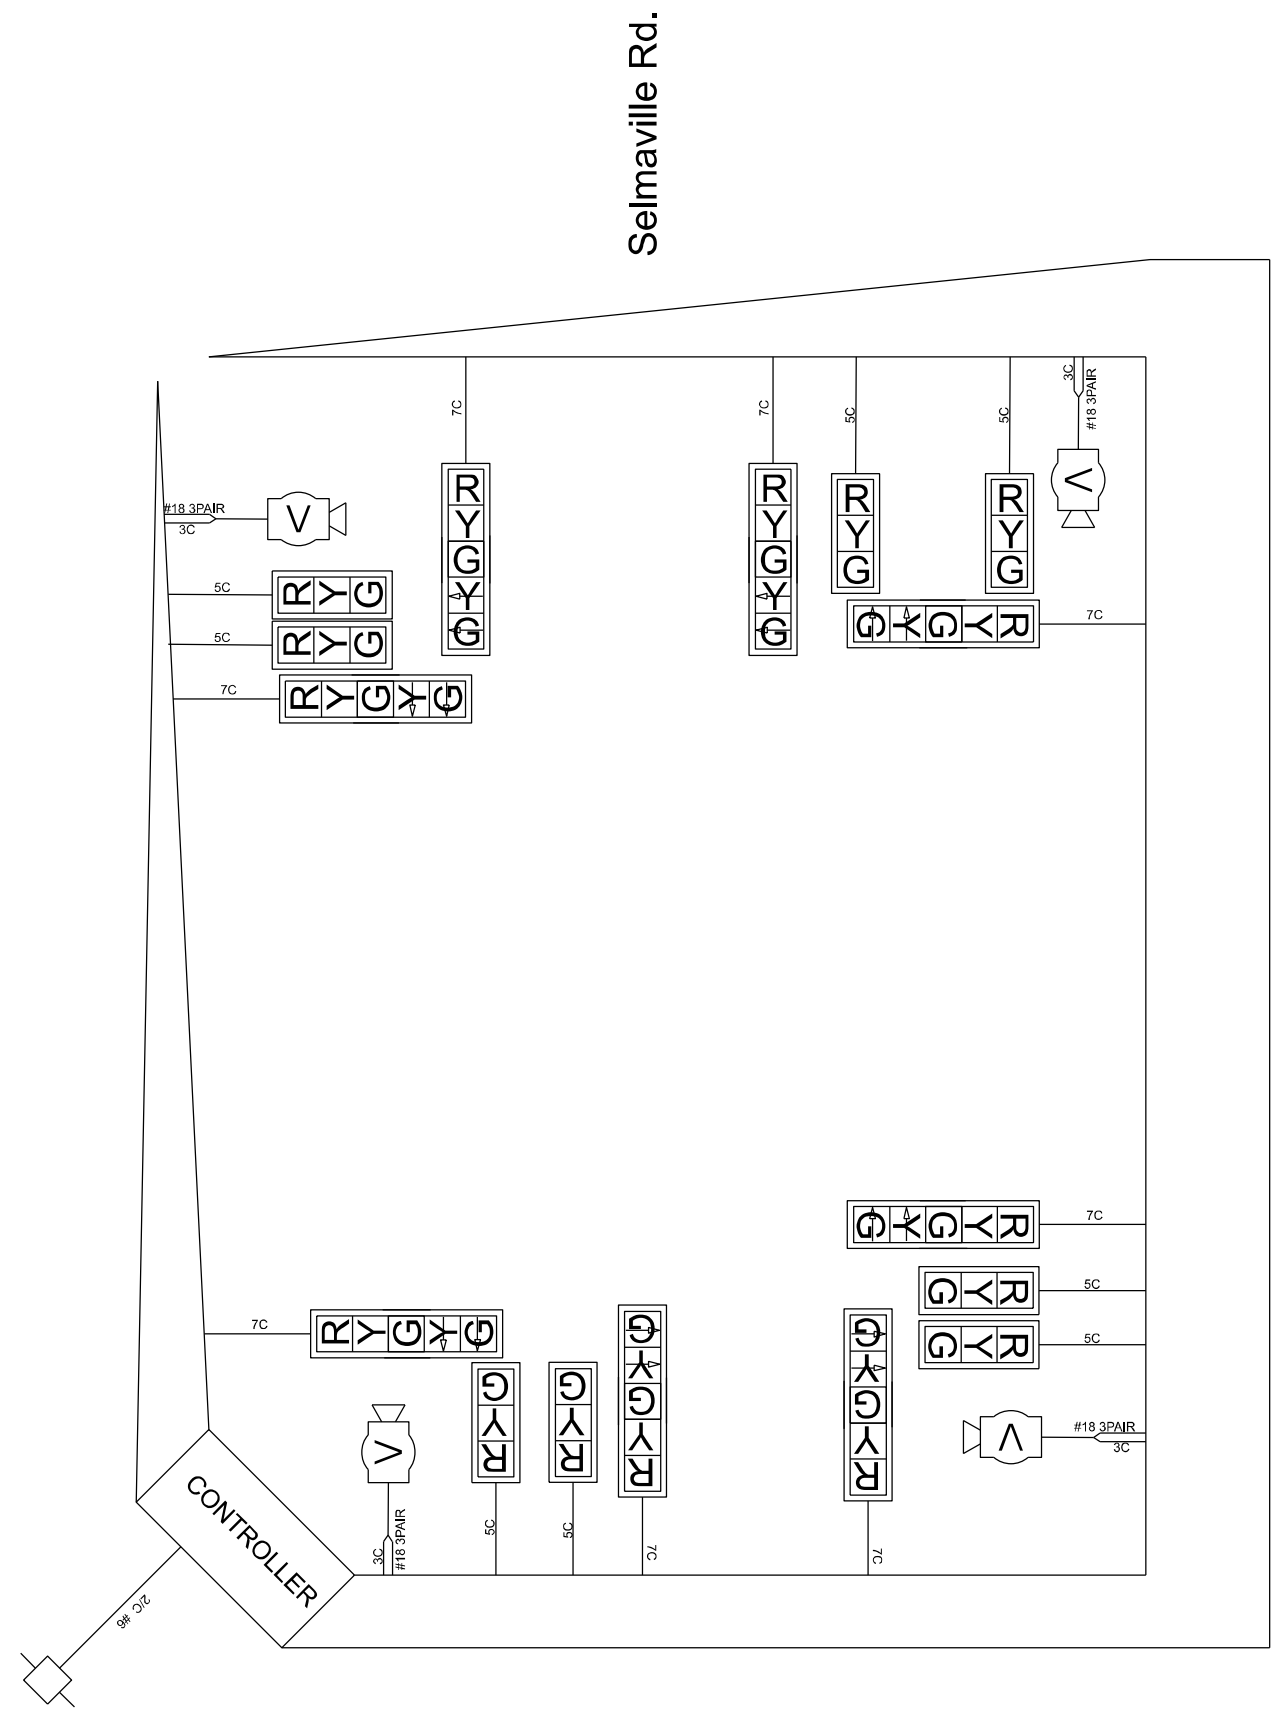

USER NAME = daniel.hopkins	DESIGNED -	REVISED -
	DRAWN -	REVISED -
PLOT SCALE = 0.16666633' / in.	CHECKED -	REVISED -
PLOT DATE = 1/23/2024	DATE -	REVISED -

**STATE OF ILLINOIS
 DEPARTMENT OF TRANSPORTATION**

**CABLE DIAGRAM
 US 50 AT SELMAVILLE RD.**

SCALE: 1"=50' SHEET OF SHEETS STA. TO STA.

F.A. RTE.	SECTION	COUNTY	TOTAL SHEETS	SHEET NO.
VAR.	DIST 8 TS 2024-1	MADISON ST., CLAIR, & MARION	17	17
CONTRACT NO. 76T45				
ILLINOIS FED. AID PROJECT				