
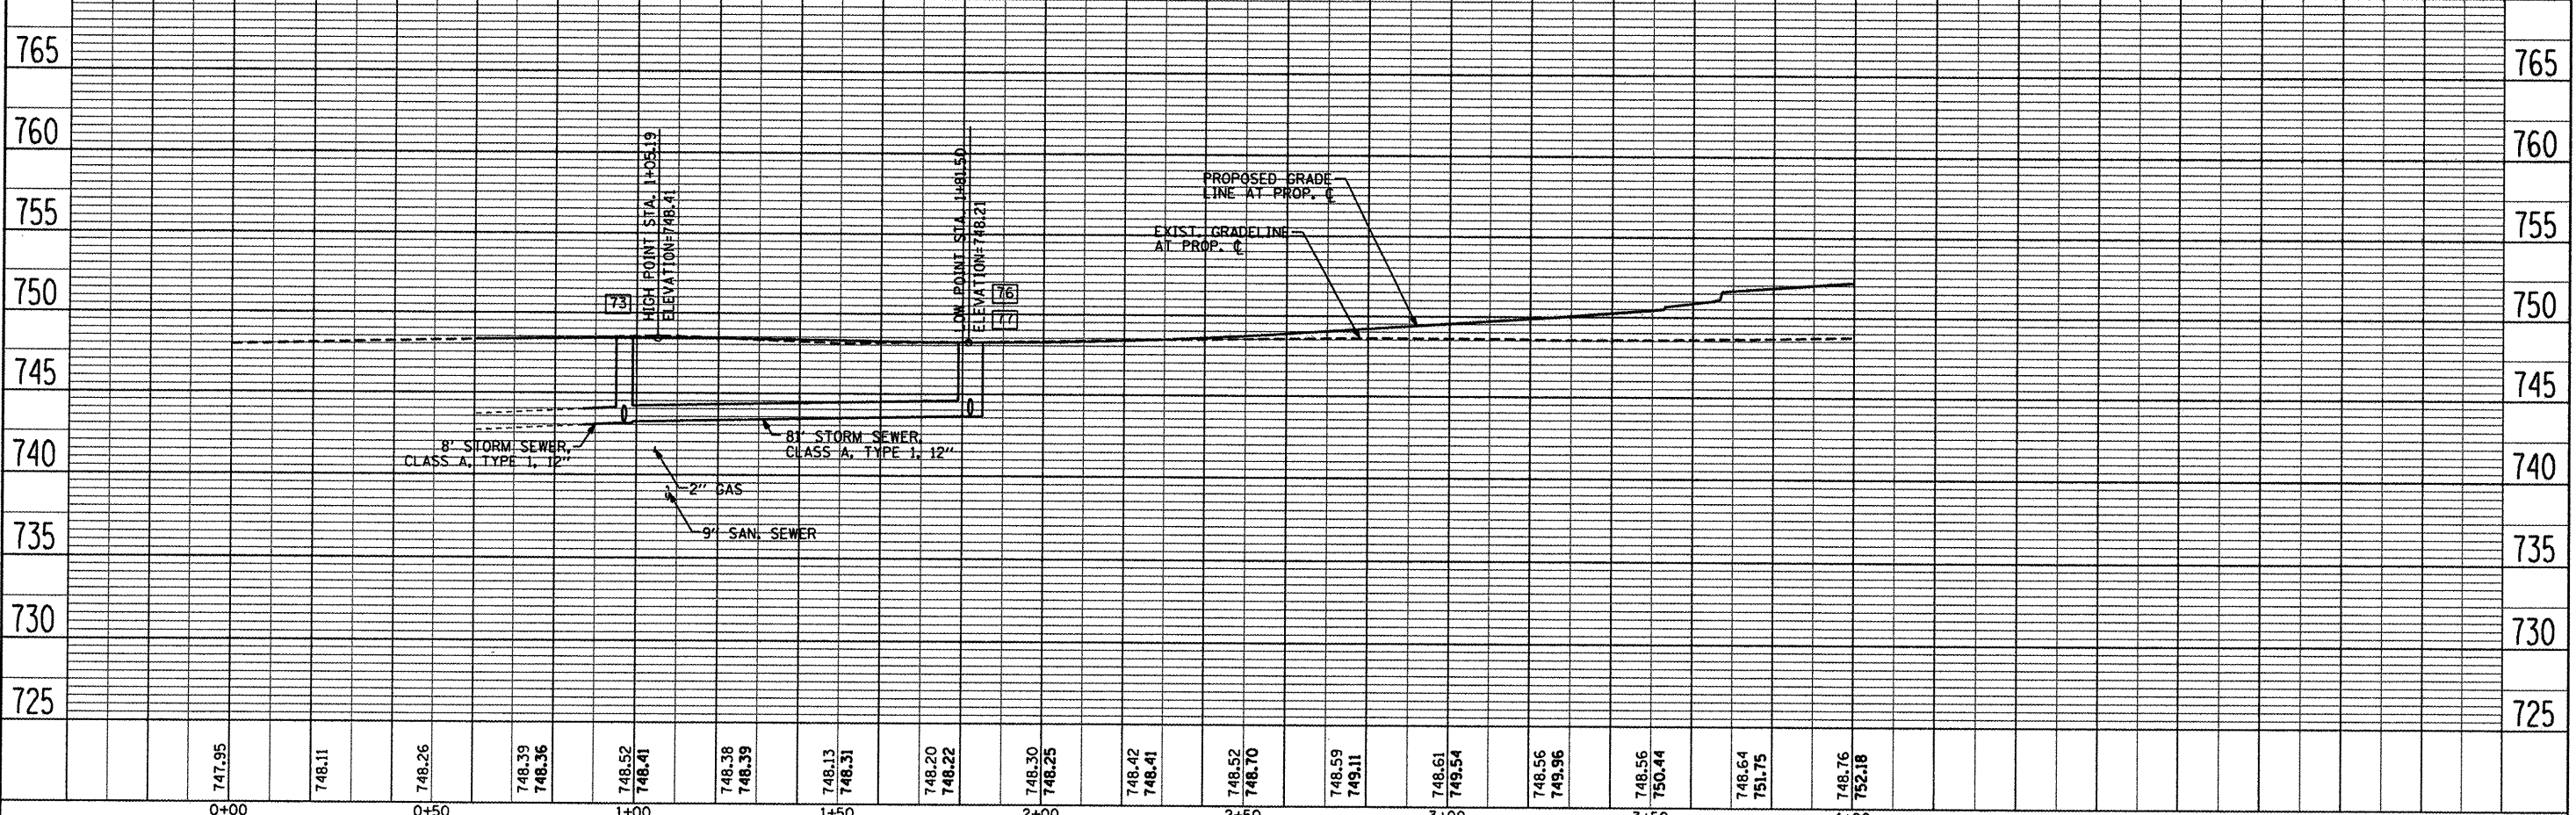


DATE	
BY	
DESIGNED	
CHECKED	
PLANNED	
APPROVED	
PROJECT NO.	
FILE NAME	

DATE	
BY	
DESIGNED	
CHECKED	
PLANNED	
APPROVED	
PROJECT NO.	
FILE NAME	

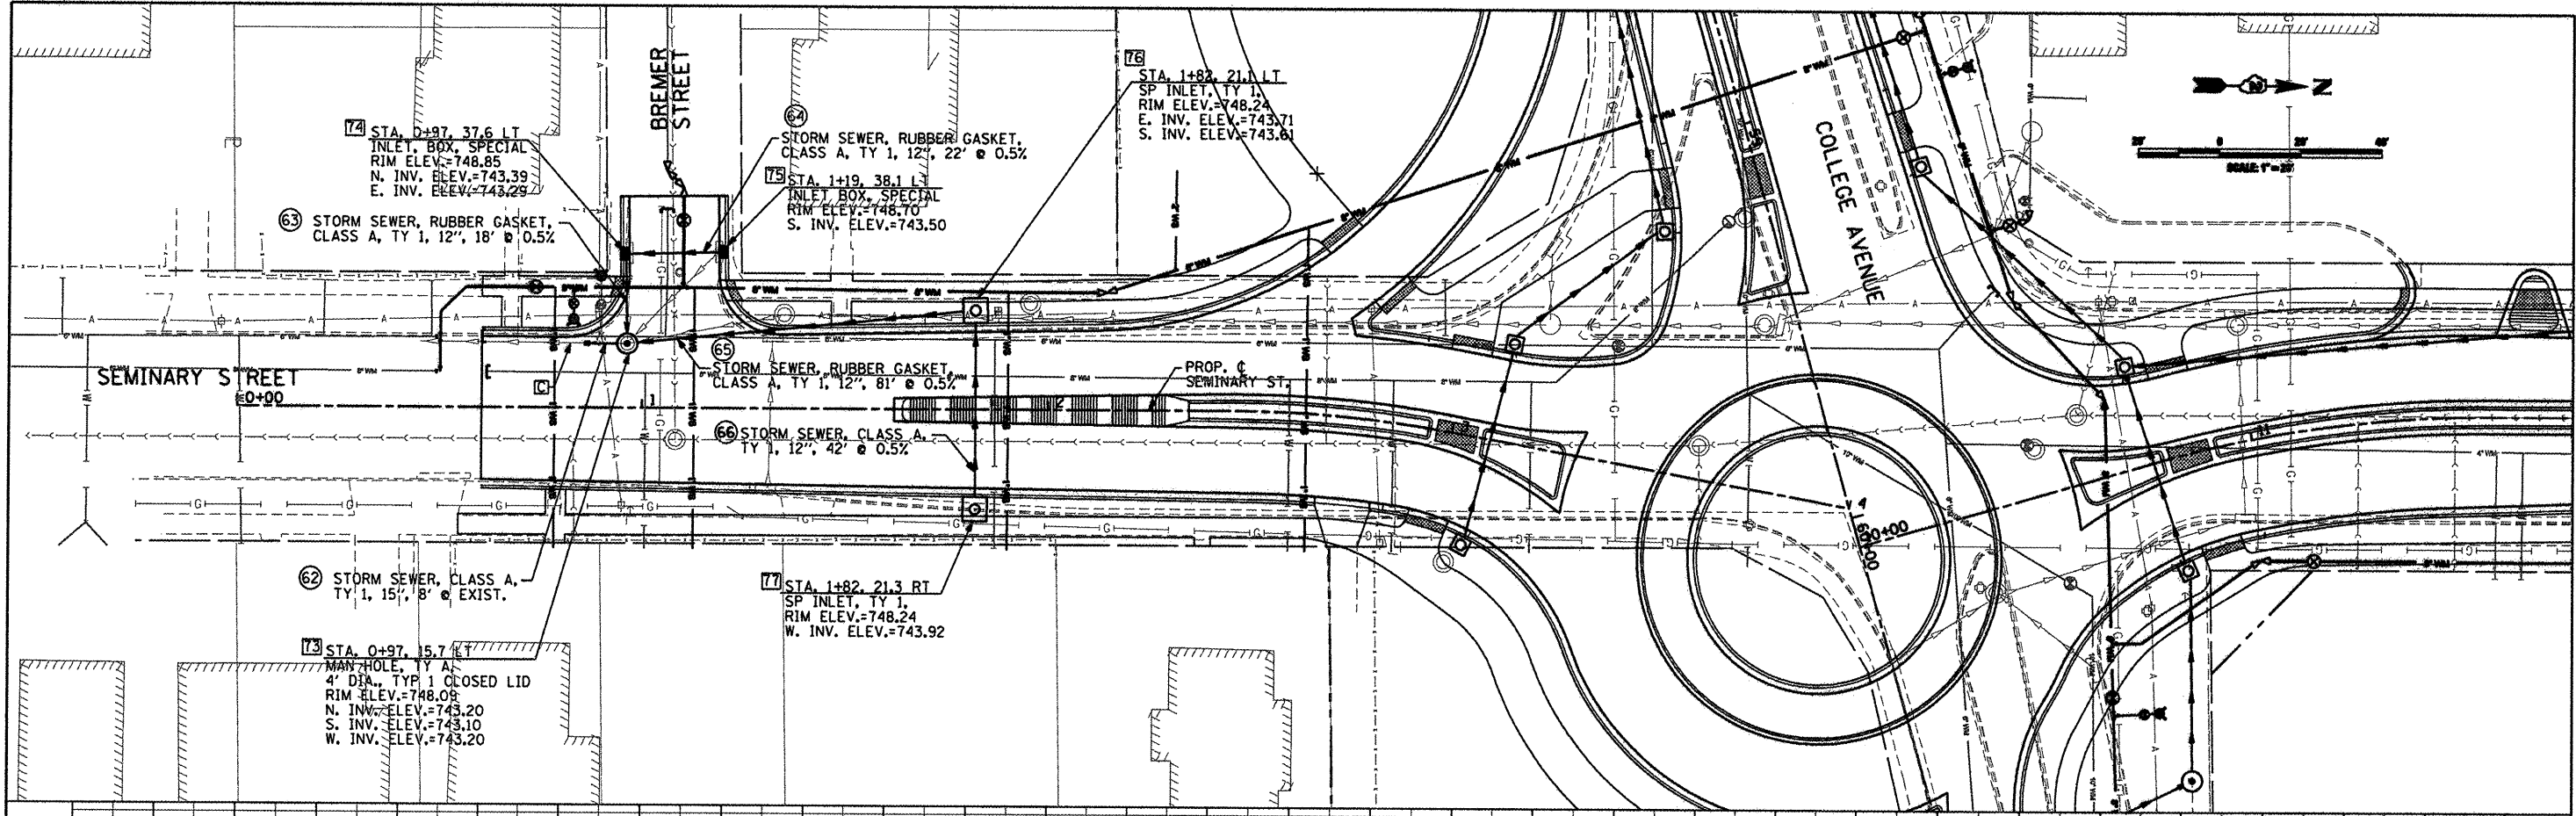

747.95	748.11	748.26	748.39 748.36	748.52 748.41	748.38 748.39	748.13 748.31	748.20 748.22	748.30 748.25	748.42 748.41	748.52 748.70	748.59 749.11	748.61 749.54	748.56 749.96	748.56 750.44	748.64 751.75	748.76 752.18
0+00	0+50	1+00	1+50	2+00	2+50	3+00	3+50	4+00								

CMT
CRAWFORD, MURPHY & TULLY, INC.
CONSULTING ENGINEERS
License No. 04-00063

USER NAME = Steve Prange	DESIGNED SJP / MNB	REVISED -
DRAWN ERD	CHECKED SJP	REVISED -
DATE 02/04/11		REVISED -

CITY OF ROCKFORD
MORGAN STREET BRIDGE

PROPOSED DRAINAGE PLAN & PROFILE
SEMINARY STREET

SCALE: 1" = 20' SHEET NO. 7 OF 11 SHEETS STA. 0+00 TO STA. 4+00

F.A. RTE. 5077	SECTION 99-00493-00-BR	COUNTY WINNEBAGO	TOTAL SHEETS 253	SHEET NO. 48
CONTRACT NO. 85529			FED. AID PROJECT BRN-509965J	