


END CONTRACT 60R30 STA. 3982+08  
 BEGIN CONTRACT 60R31 STA. 3982+08 NOTE 2

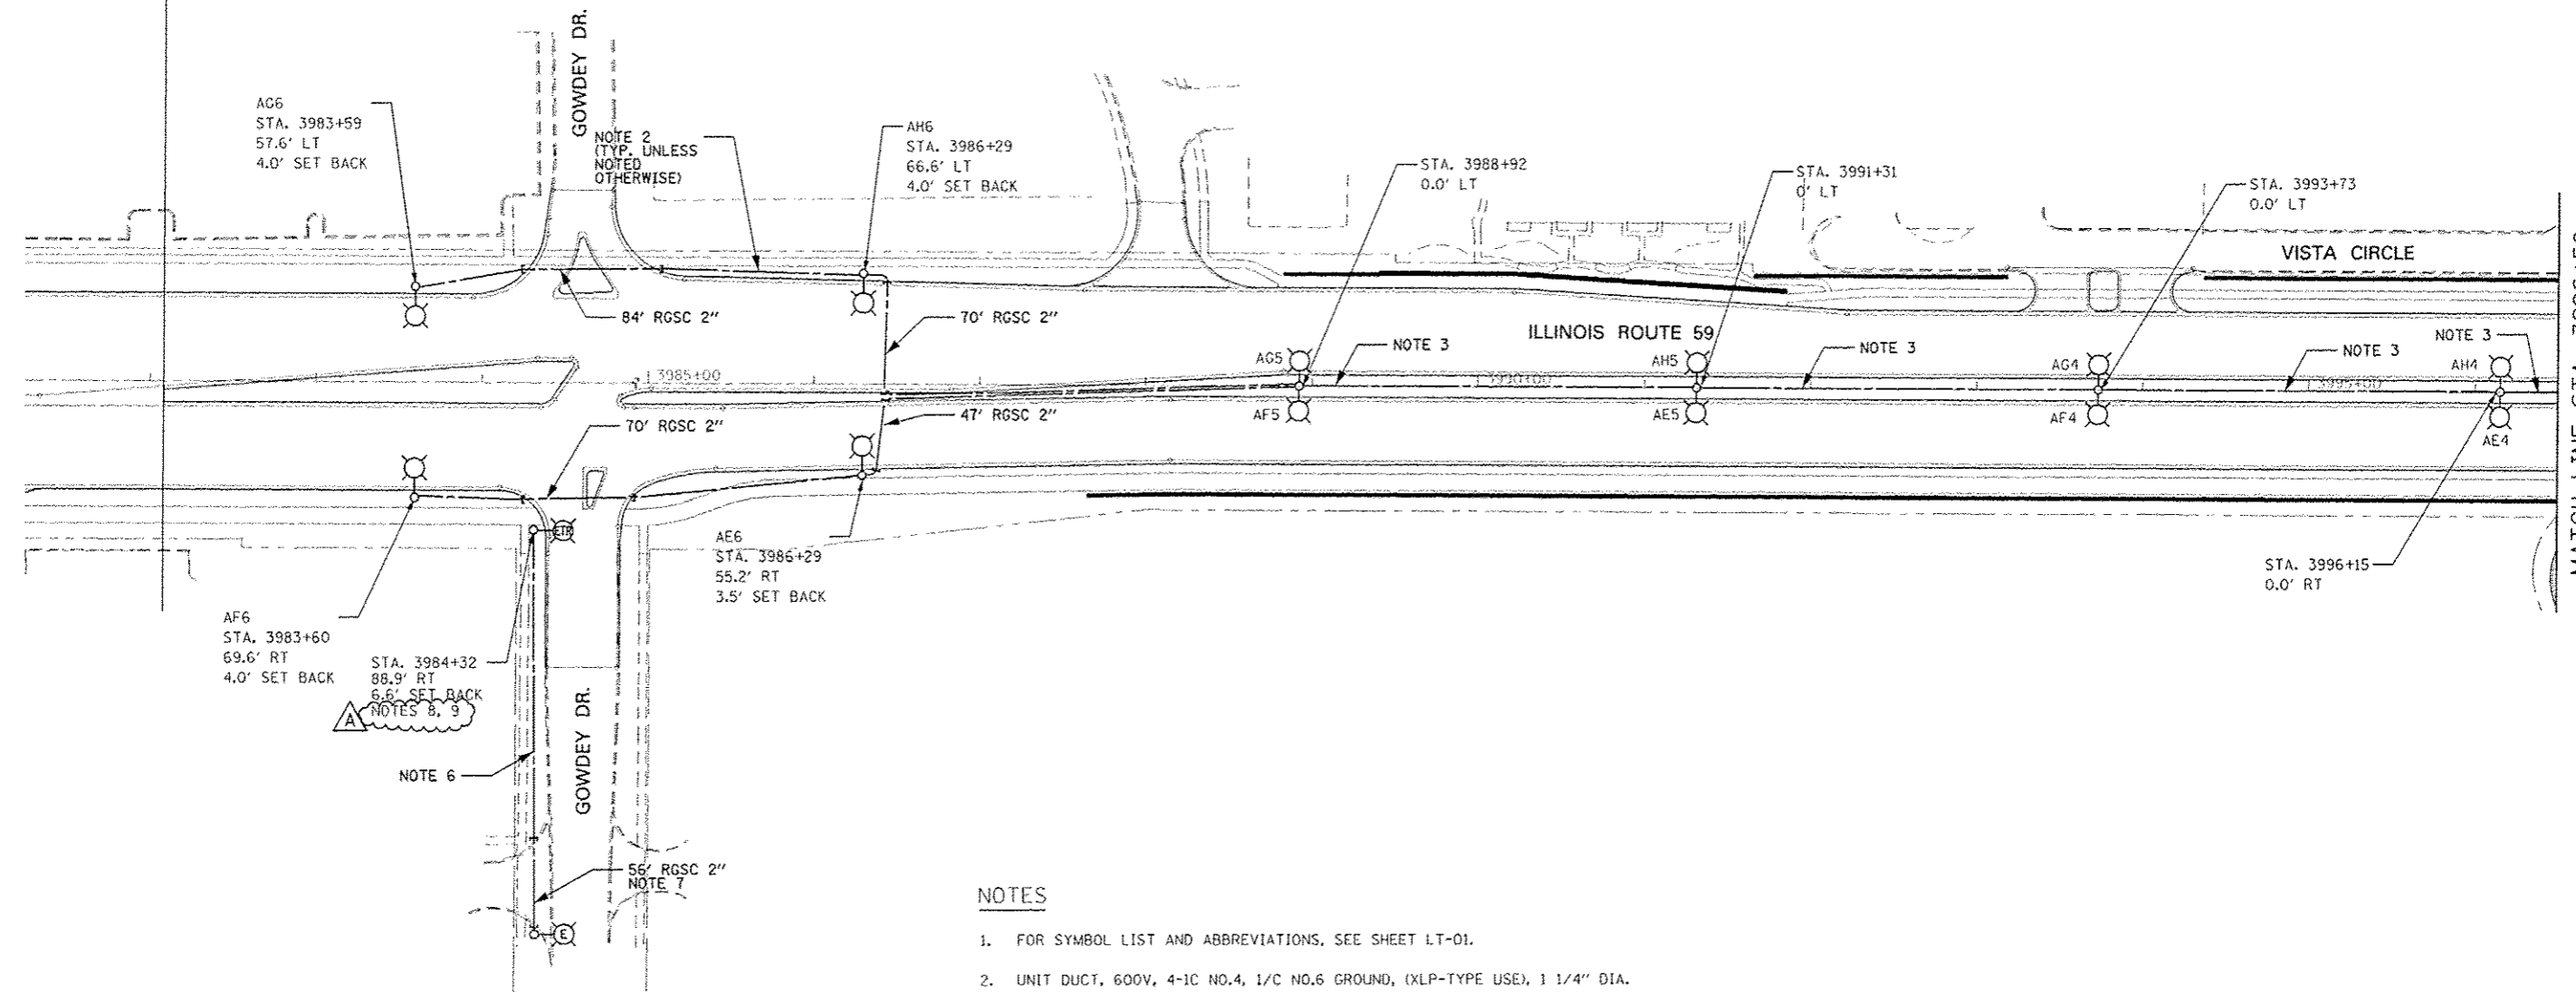


**NOTES**

- FOR SYMBOL LIST AND ABBREVIATIONS, SEE SHEET LT-01.
- UNIT DUCT, 600V, 4-1C NO.4, 1/C NO.6 GROUND, (XLP-TYPE USE), 1 1/4" DIA. POLYETHYLENE.
- UNIT DUCT, 600V, 8-1C NO.4, 1/C NO.6 GROUND, (XLP-TYPE USE), 1 1/2" DIA. POLYETHYLENE.
- POLE SET-BACK SHALL BE MEASURED FROM THE BACK OF THE CURB TO THE CENTER OF THE POLE/BASE.
- COORDINATE LIGHTING WORK WITH CONTRACT 60R30.
- UNIT DUCT, 600V, 4-1C NO.6, 1/C NO.6 GROUND, (XLP-TYPE USE), 1 1/4" DIA. POLYETHYLENE.
- CONDUIT SHALL BE INSTALLED PUSHED.

**A** POLE SHALL BE WIRED TO CITY OF NAPERVILLE CONTROLLER.

**A** BOLT CIRCLE AND ANCHOR BOLTS NUMBER AND LAYOUT OF THE FOUNDATION SHALL MATCH THE RE-INSTALLED POLE.

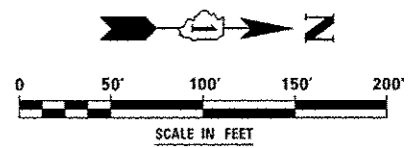

DESIGNED MCP	REVISED - ADDENDUM A 02/22/2013	<b>STATE OF ILLINOIS DEPARTMENT OF TRANSPORTATION</b>	<b>LIGHTING PLANS - ILLINOIS ROUTE 59</b>		F.A.P. RTE. 338	SECTION (112 & 113) WRS-6	COUNTY DUPAGE	TOTAL SHEETS 734	SHEET NO. 477	
DRAWN MLE	REVISED -		SCALE: AS SHOWN	SHEET NO. 1 OF 8 SHEETS	STA. TO STA.	<b>LT-06</b>		CONTRACT NO. 60R31		
CHECKED MCP	REVISED -		ILLINOIS FED. AID PROJECT							
DATE 09/07/2012	REVISED -									