
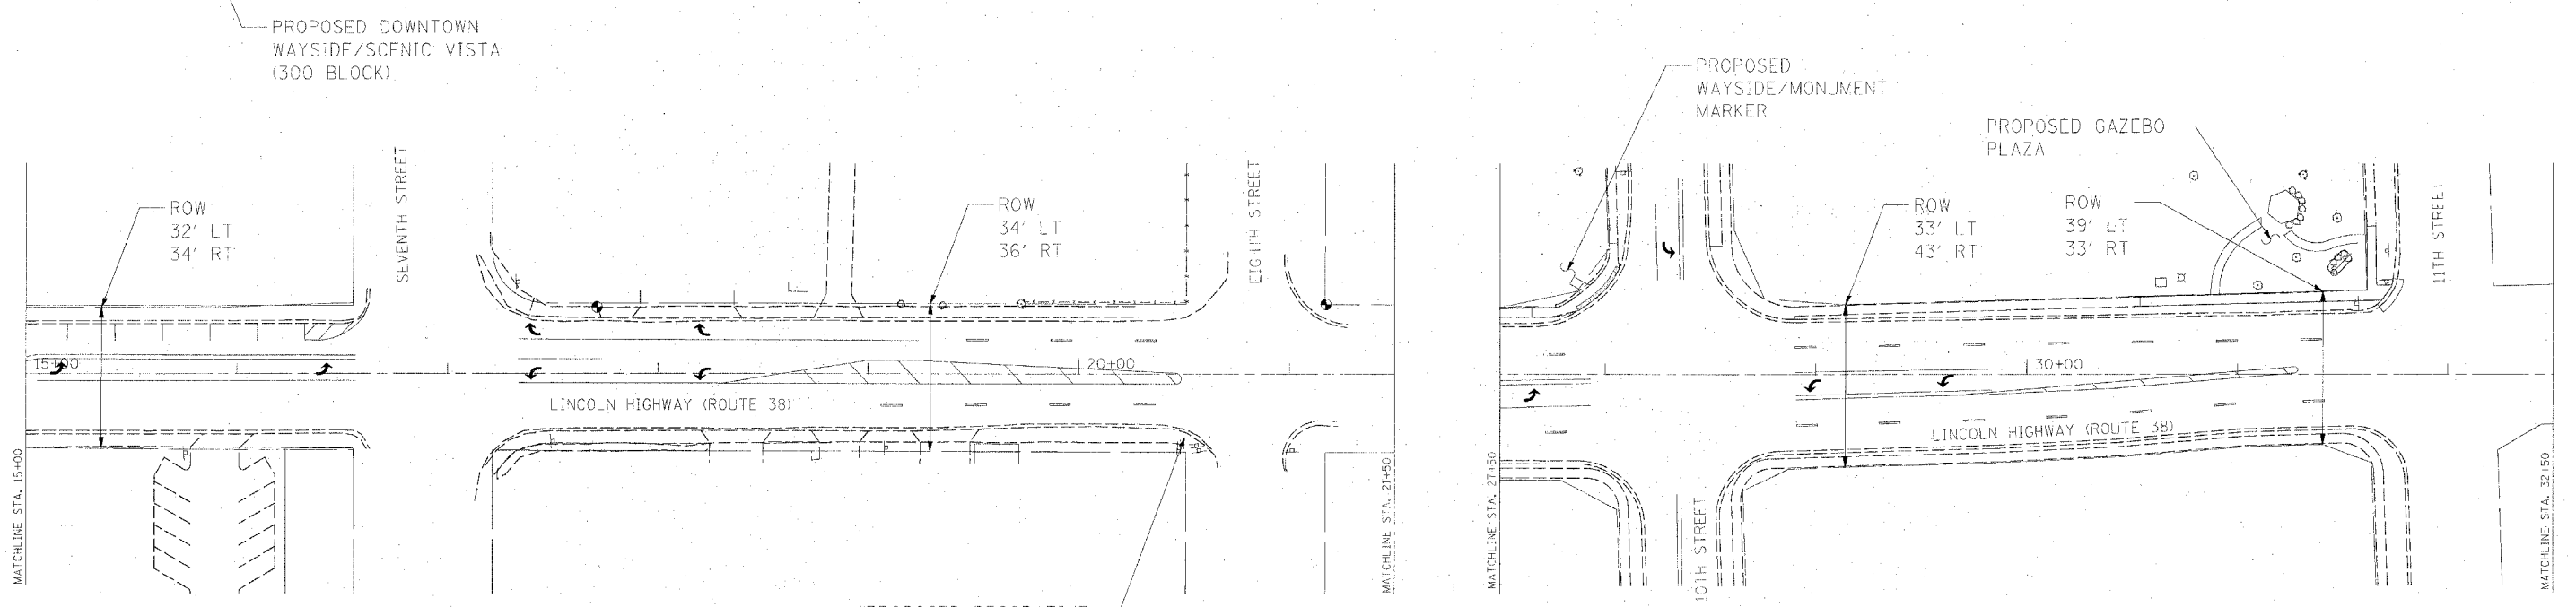


NOTE: SEE LANDSCAPE & LIGHTING PLANS FOR ADDITIONAL INFORMATION

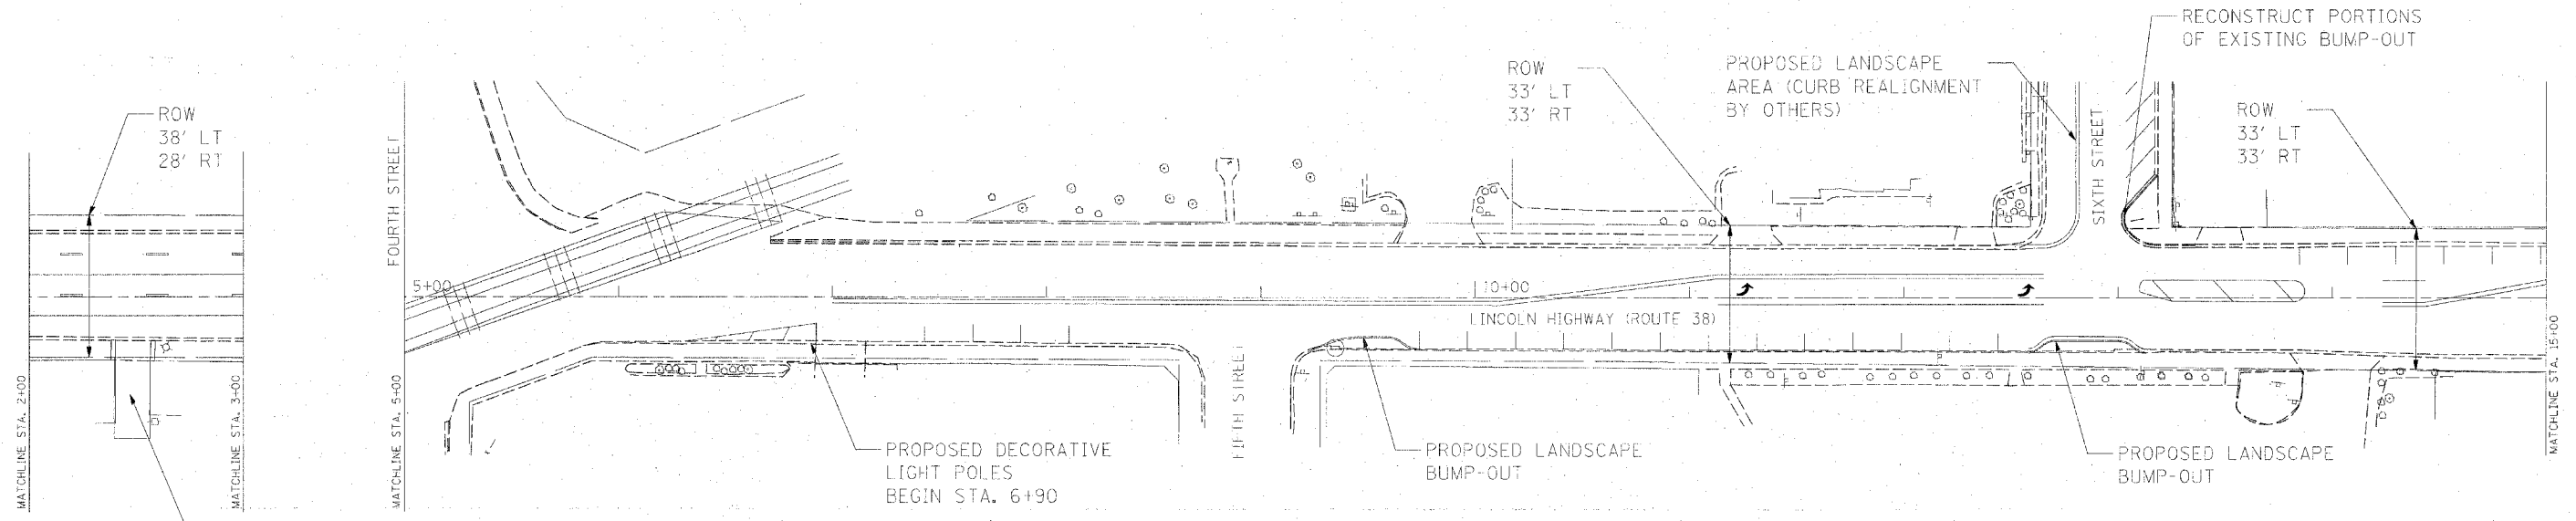

Hanson Professional Services Inc.
© Copyright Hanson Professional Services Inc. 2008

FILE NAME = USER NAME = MWH
DESIGNED - CPS
DRAWN - MWH
CHECKED - CPS
DATE - 04/10/08

**STATE OF ILLINOIS
DEPARTMENT OF TRANSPORTATION**

**ROADWAY PLAN
EAST LINCOLN HIGHWAY
LIGHTING AND STREETScape
DEKALB, IL**

F.A.P. RTE.	SECTION	COUNTY	TOTAL SHEETS	SHEET NO.
567	06-00173-00-LT	DEKALB	41	9
CONTRACT NO.			87337	
SCALE: AS SHOWN			SHEET NO. OF SHEETS STA. 2+00 TO STA. 32+50	
FAP 567			ILLINOIS ISEP 32025	

