



© Copyright Hanson Professional Services Inc. 2012
HANSON
 Hanson Professional Services Inc.

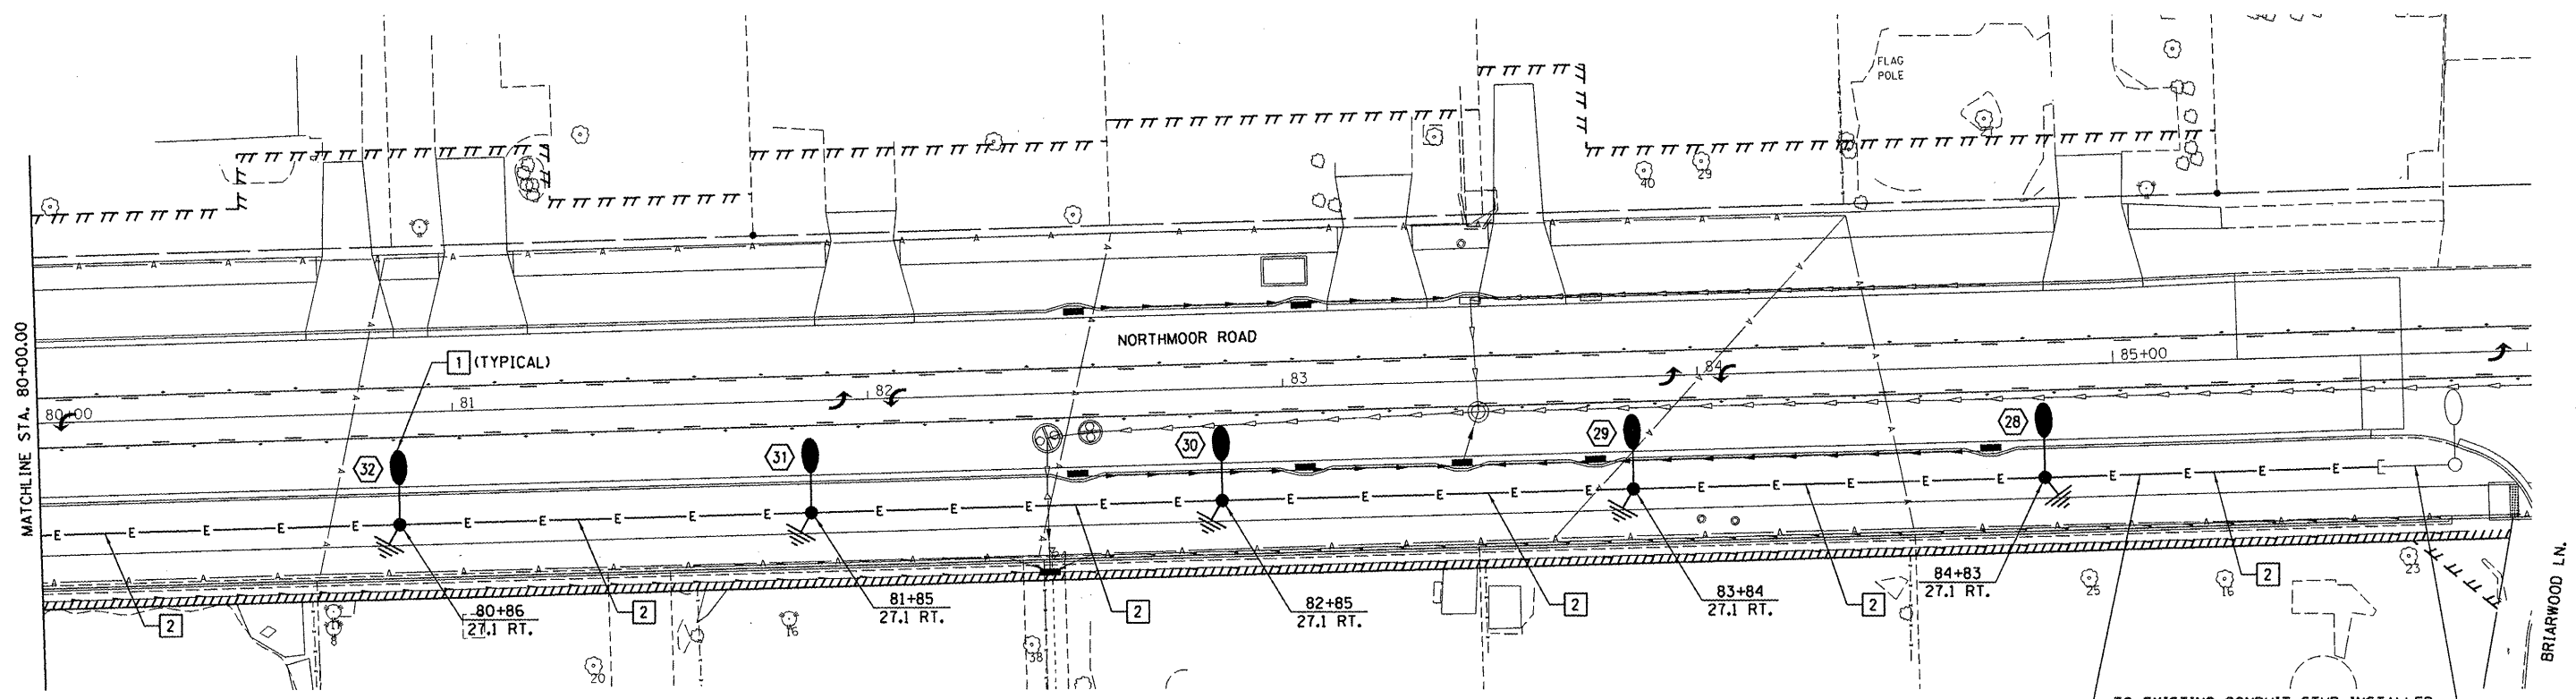

TO EXISTING CONDUIT STUB INSTALLED UNDER STAGE 1 WORK. 2*6, *6G. INSTALLED BACK TO CONTROLLER UNDER STAGE 1 FOR CIRCUIT F

KEYED NOTES:

- 1 NEW 250W HPS LUMINAIRE MOUNTED ON NEW 40 FT. POLE.
- 2 2-1/2" NO. 6, 600V XLP, 1-1/2" NO. 6G, 600V XLP, 1 1/2" PVC CONDUIT.

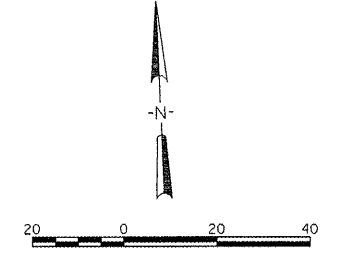

FILE NAME = I:\09Jobs\09L0027A\CADD\Elec\Sheet\04.dgn	USER NAME = mansh01398	DESIGNED - RDN	REVISED -	STATE OF ILLINOIS DEPARTMENT OF TRANSPORTATION	NORTHMOOR ROAD STAGE 2 IMPROVEMENT LIGHTING PLAN	F.A.U. RTE. 6647	SECTION 05-00302-01-PV	COUNTY PEORIA	TOTAL SHEETS 125	SHEET NO. 55	
PLOT SCALE = 40.0000' / in.	CHECKED - RDN	DESIGNED - RDN	REVISED -			STA. 80+00 TO STA. 86+00	FED. ROAD DIST. NO. 11-00047-03-PV	CONTRACT NO. 89526		M-50931137	
PLOT DATE = 04/10/2012	DATE - 02/02/12	DESIGNED - RDN	REVISED -				ILLINOIS FED. AID PROJECT				