


APR 10, 2006 1:16 PM BAK
 I:\AIRPORTS\DEKALB\803-05TXVAIRPORT\SHEETS\TWY-C\R-142ELE.DWG

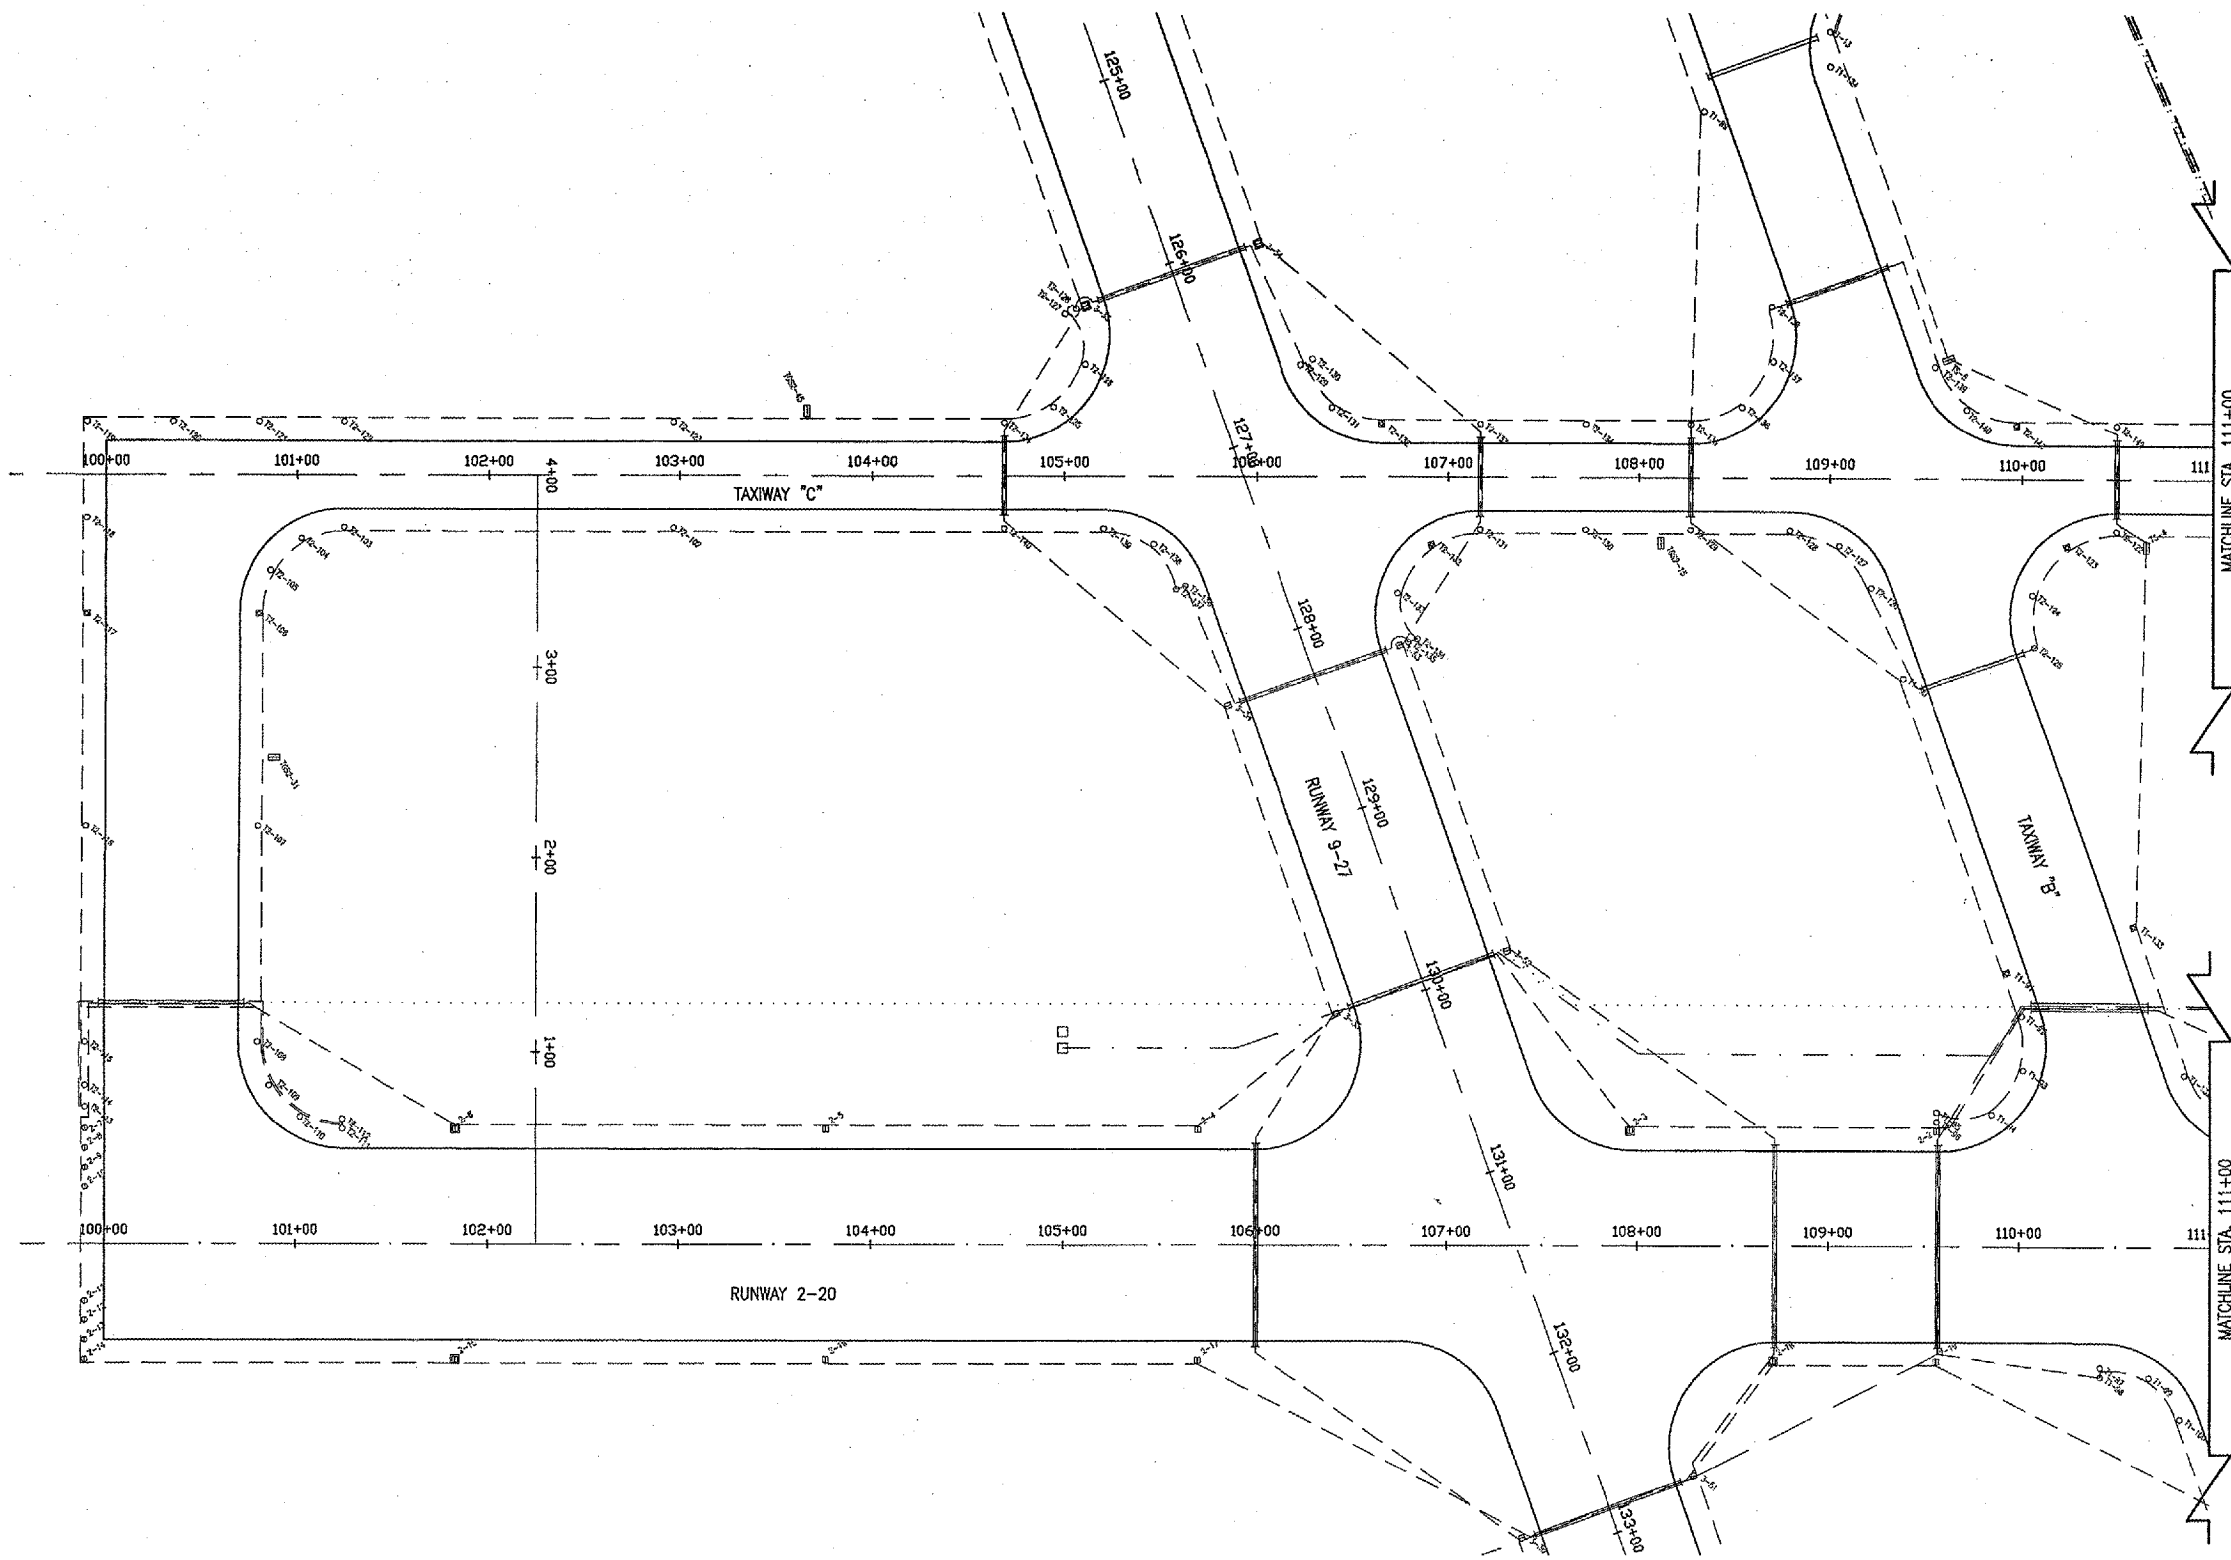

LEGEND

- EXISTING PAVEMENT
- EXISTING NO. 8, 5 KV. 1/C., TYPE C CABLE IN U.D.
- EXISTING RUNWAY END 02 REIL CABLE
- EXISTING RUNWAY END 02 PAPI CABLE
- EXISTING CONCRETE ENCASED DUCT
- EXISTING STAKE MOUNTED RUNWAY LIGHT
- EXISTING BASE MOUNTED RUNWAY LIGHT
- EXISTING STAKE MOUNTED RUNWAY THRESHOLD LIGHT
- EXISTING STAKE MOUNTED TAXIWAY LIGHT
- EXISTING BASE MOUNTED TAXIWAY LIGHT
- EXISTING TAXI GUIDANCE SIGN

DK050

| DATE | REVISION | BY |
|------|----------|----|
| | | |
| | | |
| | | |

DTMAX
 DEKALB TAYLOR MUNICIPAL AIRPORT
 ILL. PROJ.: DKB-3448 AIP PROJ.: 3-17-0139-042

| | |
|--|---|
| IPIE Project No. 803051X1AD_0800 File Name: R-142ELE.DWG Scale: 1" = 50' Date: 01/05/05 | LAYOUT: JMB 01/05/05 DRAWN: JMB 01/05/05 REVIEWED: CAH 02/22/06 |
|--|---|

HANSON
 Hanson Professional Services Inc.
 1325 Shiloh Road, Suite 200
 Spring Hill, TN 37073-2886
 Offices Nationwide

WIDEN TAXIWAYS A & C
 FROM 35' TO 50'
 EXISTING ELECTRICAL PLAN
 STA. 100+00 TO STA. 111+00

