



F.A.P. RTE.	SECTION	COUNTY	TOTAL SHEETS	SHEET NO.
337	202-5	LAKE	562	400
STA. 101+180		TO STA. 101+510		
FED. ROAD DIST. NO.		ILLINOIS FED. AID PROJECT		
D-91-552-99		CONTRACT #60881		

FINAL SURVEY	BY	DATE
SCOTTED		
NOTE BOOK		
TEMPLATE		
AREAS CHECKED		
NO.		

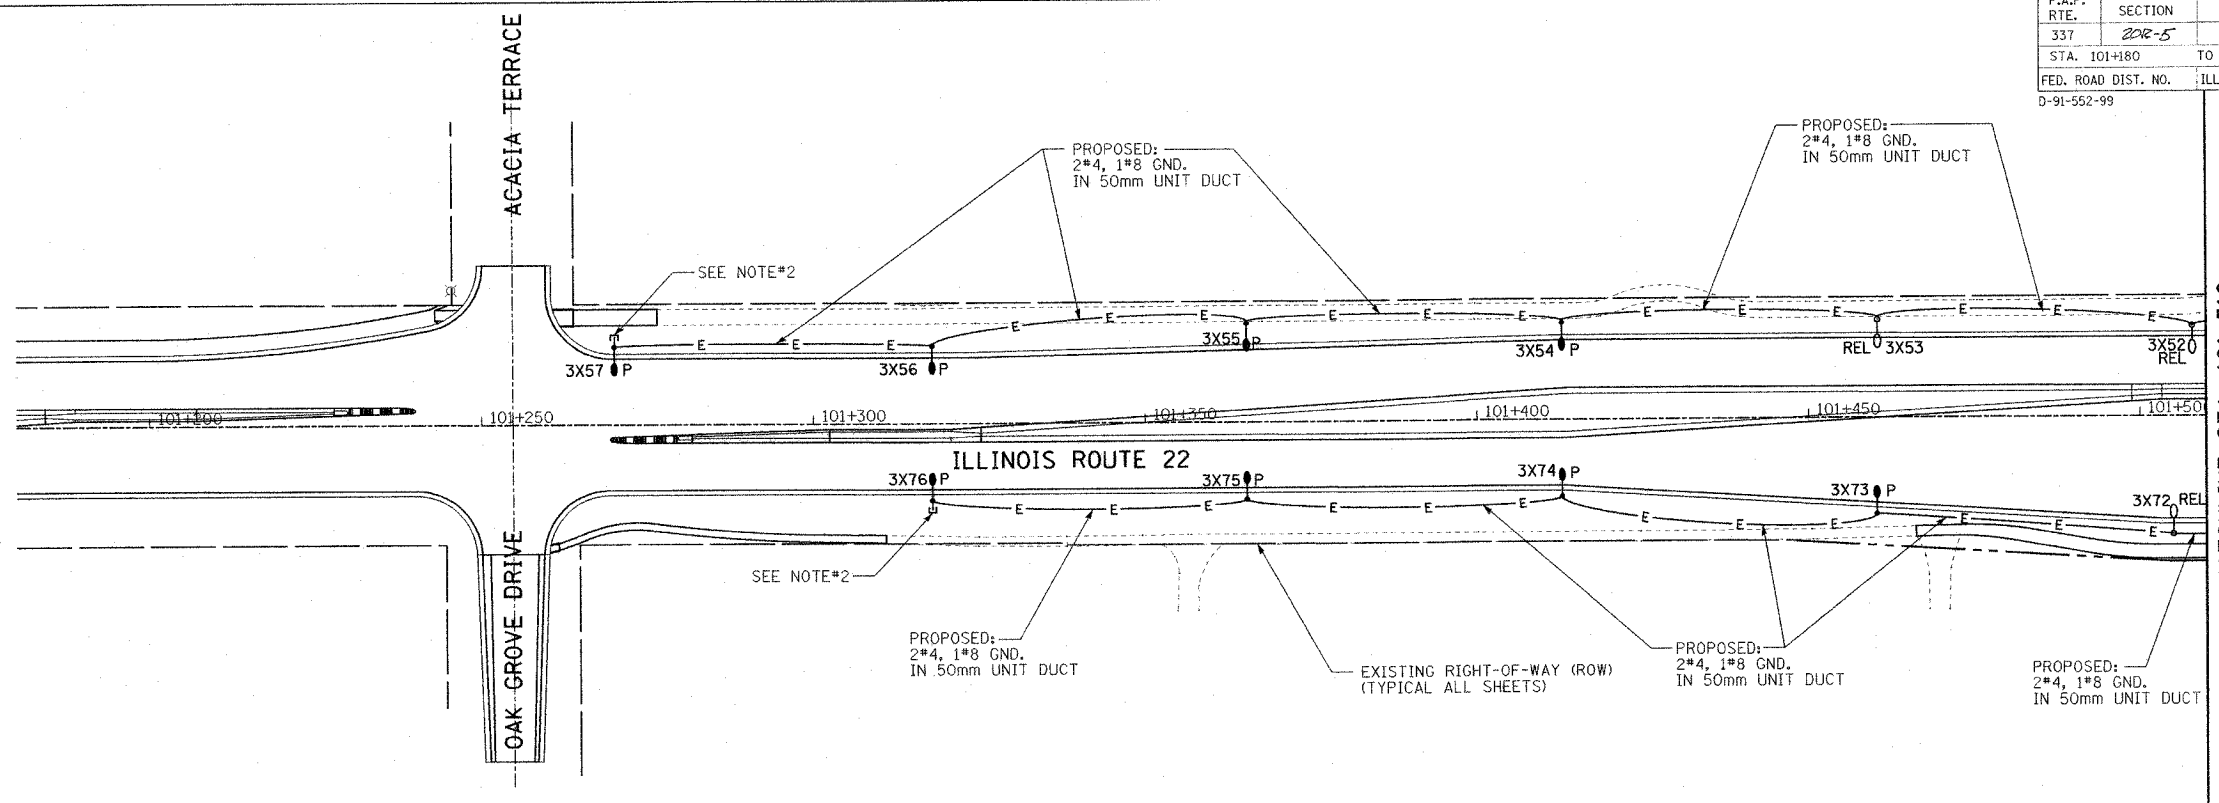

- NOTES:
1. EXACT LOCATIONS OF RELOCATED AND PROPOSED POLES AND CONDUIT/CABLE ROUTINGS SHALL BE COORDINATED WITH UNDERGROUND UTILITIES, OWNER AND ENGINEER. LOCATIONS AND ROUTINGS SHOWN ON PLANS ARE APPROXIMATE.
 2. PROVIDE 1-50mm CONDUIT STUBBED OUT 1.0m BEYOND LIGHT POLE FOUNDATION FOR FUTURE USE. CAP CONDUIT AT END.

ORIGINAL SURVEY	BY	DATE
FLOTTED		
NOTE BOOK		
TEMPLATE		
AREAS CHECKED		
NO.		

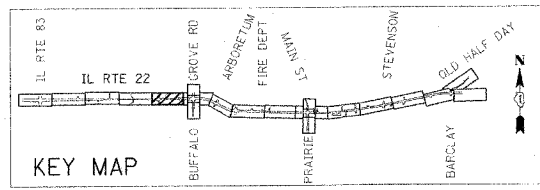

REVISIONS	
NAME	DATE

ILLINOIS DEPARTMENT OF TRANSPORTATION
 IL RTE 22 (FAP 337)
 IL RTE 83 TO US 45 / IL 21 (MILWAUKEE AVE)
 PROPOSED LIGHTING PLAN (1 OF 10)
 OAK GROVE DRIVE TO STA. 101+510
 SCALE: 1:500
 DATE: 03-22-2004
 DRAWN BY: CMW
 CHECKED BY: MAR