


F.A.I. RTE.	SECTION	COUNTY	TOTAL SHEETS	SHEET NO.
94	*	COOK	907	1679
STA.		TO STA.		
FED. ROAD DIST. NO.		ILLINOIS FED. AID PROJECT		
*(1516.1, 1717 & 1818) R-9		62695		

\* For c(E), d(E), and d<sub>1</sub>(E) - Deck to Sidewalk/Parapet Bars see DWG. S-11

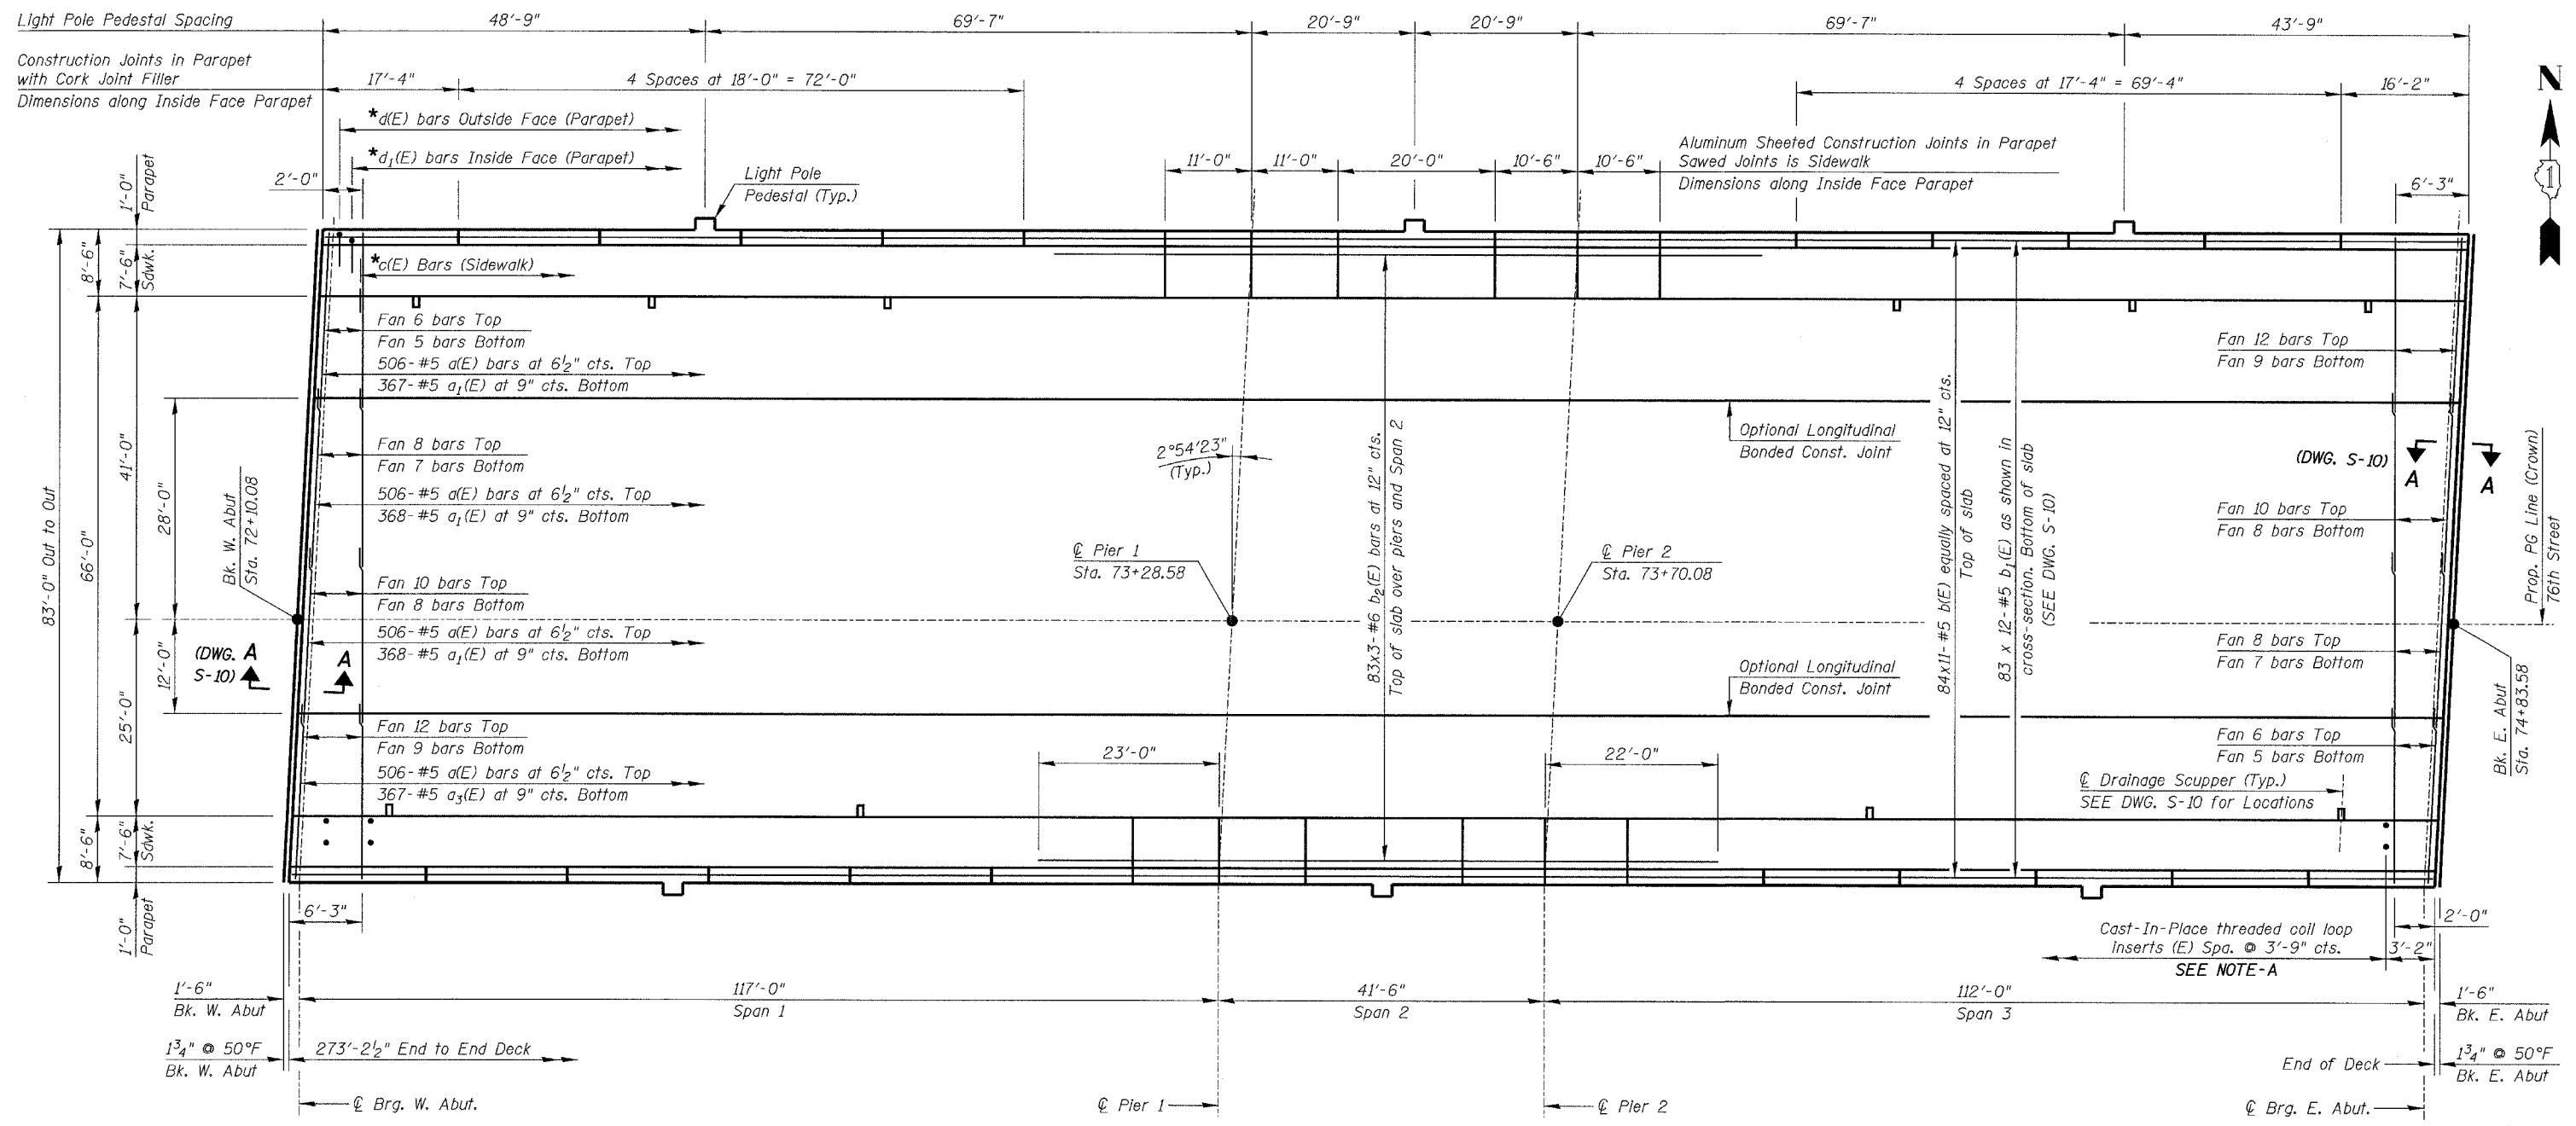

**DECK PLAN**

**NOTE - A**

Coordinate threaded coil loop inserts with Electrical Contractor. Cost shall be included with "Concrete Superstructures".

**Notes:**

- Reinforcement Bars designated (E) shall be epoxy coated.
- Bars indicated thus 20 x 3-#5 etc. indicates 20 lines of bars with 3 lengths per line.
- SEE DWG. S-10 for Deck Cross Section Details.
- SEE DWG. S-11 for Sidewalk & Parapet Details
- SEE DWG. S-12 for Light Pole Pedestal Details

- SEE DWG. S-13 for Deck Misc. Details and Bill of Material.
- SEE DWGS. S-16 & S-17 for Scupper & Drainage Details.
- For Under-Deck Lighting and Luminaire Hanger Details SEE UNDERPASS LIGHTING PLANS.
- Work this DWG. with DWGS. S-10 thru S-13.

**MIN. BAR LAPS:**  
 #5 = 1'-8"  
 #6 = 2'-0"

REVISIONS	
NAME	DATE

ILLINOIS DEPARTMENT OF TRANSPORTATION  
**DECK PLAN**  
 76TH STREET OVER FAI-94  
 FAP ROUTE 1541 SECTION 1818 R-9  
 COOK COUNTY  
 STATION 73+49.33  
 STRUCTURE NUMBER 016-2850  
 SCALE: NONE DESIGNED BY: TB DRAWN BY: TL  
 DATE: March 25, 2005 CHECKED BY: WPM CHECKED BY: WPM

DWG. S-09 of 42



FILE: L:\16592.021\Cad\Sheets\Roadway Structures\16592-2850-0101.dgn