


120 VAC, 20 AMP SPEC GRADE, NEMA 5-20R, DUPLEX CONVENIENCE RECEPTACLE IN A DIE CAST CONSTRUCTION HUBBELL/RACO/BELL, APPLETON, CROUSE-HINDS, OR APPROVED EQUAL WEATHERPROOF OUTLET BOX WITH STAINLESS STEEL COVER PLATE (TYP.)



NOTES

- 15 AMP & 20 AMP BRANCH CIRCUITS FOR LIGHTING & RECEPTACLES SHALL USE #12 AWG THWN (MIN.). EMT MAY BE USED FOR LIGHTING AND RECEPTACLE BRANCH CIRCUITS.
- LIGHT FIXTURES SHALL BE MANUFACTURED IN THE UNITED STATES TO COMPLY WITH THE AIRPORT IMPROVEMENT PROGRAM BUY AMERICAN REQUIREMENTS. PROVIDE CERTIFICATION OF MANUFACTURE IN THE UNITED STATES WITH SHOP DRAWINGS SUBMITTAL.
- ADJUST RECEPTACLE LOCATIONS WHERE NECESSARY TO ACCOMMODATE EQUIPMENT LAYOUT.
- TEST EMERGENCY LIGHTING AND CONFIRM PROPER OPERATION.
- "USPOM" SUFFIX ON LITHONIA LIGHT FIXTURE CATALOG NUMBERS INDICATES UNITED STATES POINT OF MANUFACTURE.

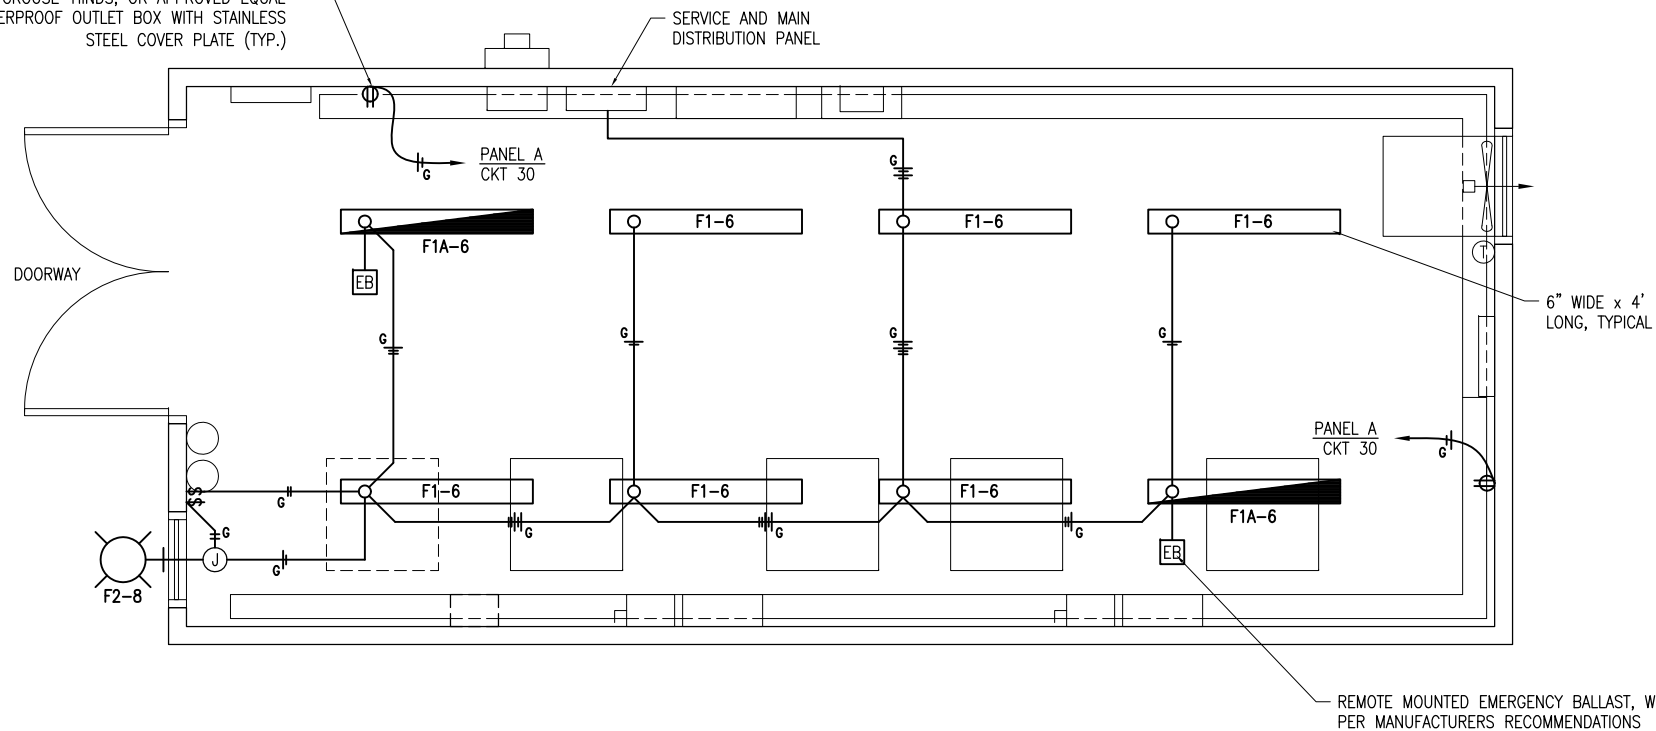

VAULT LIGHTING AND RECEPTACLE PLAN

SCALE 1/2"=1'-0"
 1 0 2 4 FEET

LIGHTING FIXTURE SCHEDULE						
FIXT. TYPE	DESCRIPTION	MANUFACTURER & CATALOG NO.	LAMPS/WATTS	VOLTS	MOUNTING	REMARKS
F1	4 FT. WET LOCATION LISTED ENCLOSED AND GASKETED INDUSTRIAL FLUORESCENT LIGHT FIXTURE, IMPACT RESISTANT, UV RESISTANT REINFORCED POLYESTER FIBERGLASS HOUSING, HIGH IMPACT ACRYLIC DIFFUSER, RAPID START COLD WEATHER 0 DEG. F. ELECTRONIC BALLAST WITH LESS THAN OR EQUAL TO 10% THD.	LITHONIA: DMW-2-32-AR-120- CW-GEB10RS-WLF -USPOM	2-32W T8 4100K 59 TOTAL INPUT WATTS	120	SURFACE TO HARD CEILING	PROVIDE WET LOCATION FITTINGS INSTALLED IN TOP OF FIXTURE.
F1A	SAME AS F1 EXCEPT PROVIDE AN EMERGENCY BALLAST CAPABLE OF OPERATING 2 LAMPS FOR 90 MINUTES AT 1100-1400 TOTAL LUMENS, BODINE #B50ST. NOTE BALLAST MIGHT REQUIRE TO BE REMOTE MOUNTED NEAR FIXTURE AS INDICATED ON THE PLANS.	LITHONIA: DMW-2-32-AR-120- CW-GEB10RS-WLF -USPOM	2-32W T8 4100K 59 TOTAL INPUT WATTS	120	SURFACE TO HARD CEILING	PROVIDE WET LOCATION FITTINGS INSTALLED IN TOP OF FIXTURE.
F2	COMPACT FLUORESCENT WALL-PAK, ONE PIECE INJECTION MOLDED UV STABILIZED POLYCARBONATE HOUSING, HIGH PERFORMANCE SPECULAR ANODIZED SEGMENTED REFLECTOR, ONE PIECE HIGH TEMPERATURE SILICONE GASKET, MEDIUM BRONZE FINISH, HIGH POWERFACTOR ELECTRONIC BALLAST WITH LESS THAN OR EQUAL TO 10% THD, UL LISTED FOR WET LOCATIONS, FUSED.	LITHONIA: TWA-42TRT-120-SF- CR-DMB-LPI -USPOM	1-42W TRT 4100K 47 TOTAL INPUT WATTS	120	SURFACE TO WALL ABOVE AND TO THE LEFT OF EXTERIOR DOOR APPROXIMATELY 4 INCHES ABOVE TOP OF DOOR FRAME. ADJUST LOCATION TO ACCOMMODATE DOORWAY OVERHANG.	CONNECT TO WALL SWITCH LOCATED ON THE INSIDE OF THE BUILDING.

REVISION
DATE

MACOMB MUNICIPAL AIRPORT
MACOMB, ILLINOIS

IL PROJ.: MGB-4206 BLOCK GRANT PROJ.: 3-17-0064-B21

Hanson Proj. No. 12A0053
Filename: E-102-VLT-LTG.dwg
AS SHOWN
Scale
Date 06/17/13

LAYOUT	KNL	01/24/13
DRAWN	MLH	01/24/13
REVIEWED	KNL/CAH	02/04/13



© Copyright Hanson Professional Services Inc. 2013
 Hanson Professional Services Inc.
 1525 South Main Street
 Springfield, Illinois 62703-2886

REPLACE VAULT, AIRFIELD
LIGHTING AND GUIDANCE SIGNS

PROPOSED VAULT LIGHTING
AND RECEPTACLE PLAN