




F.A. RTE.	SECTION	COUNTY	TOTAL SHEETS	SHEET NO.
55	2007-0031	WILL	44	44
STA.		TO STA.		
FED. ROAD DIST. NO.		ILLINOIS FED. AID PROJECT		

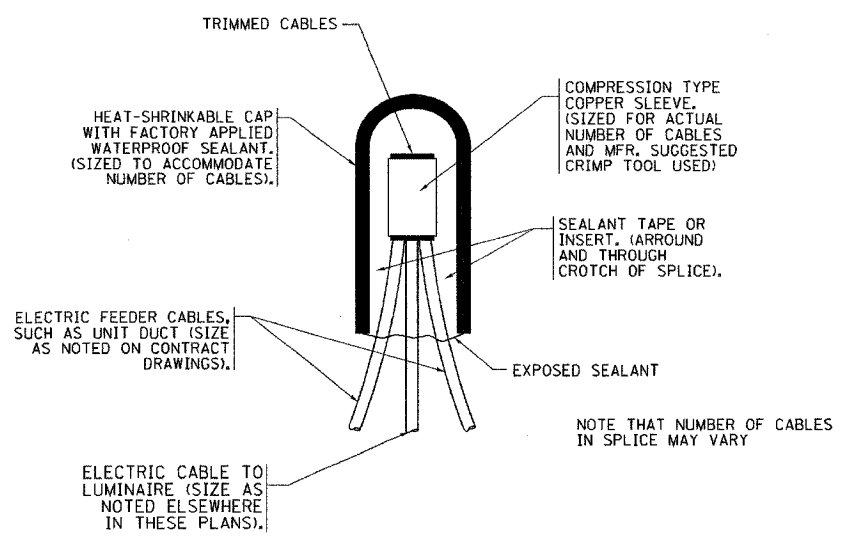

TYPICAL SPLICE DETAIL
N.T.S.

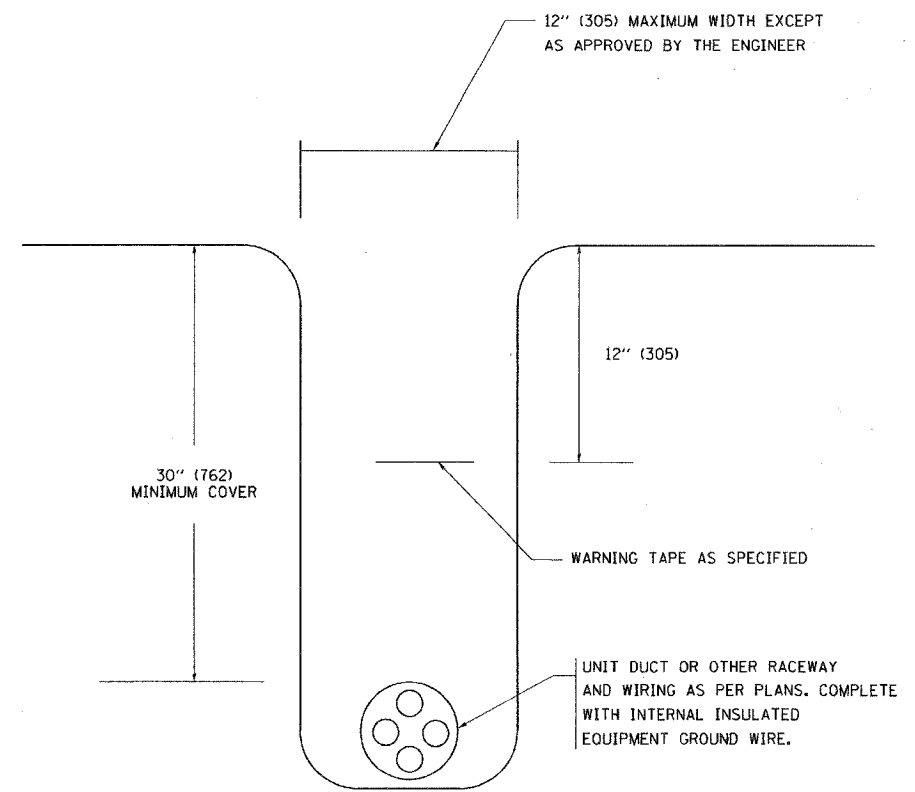

TYPICAL WIRING IN TRENCH DETAIL
N.T.S.

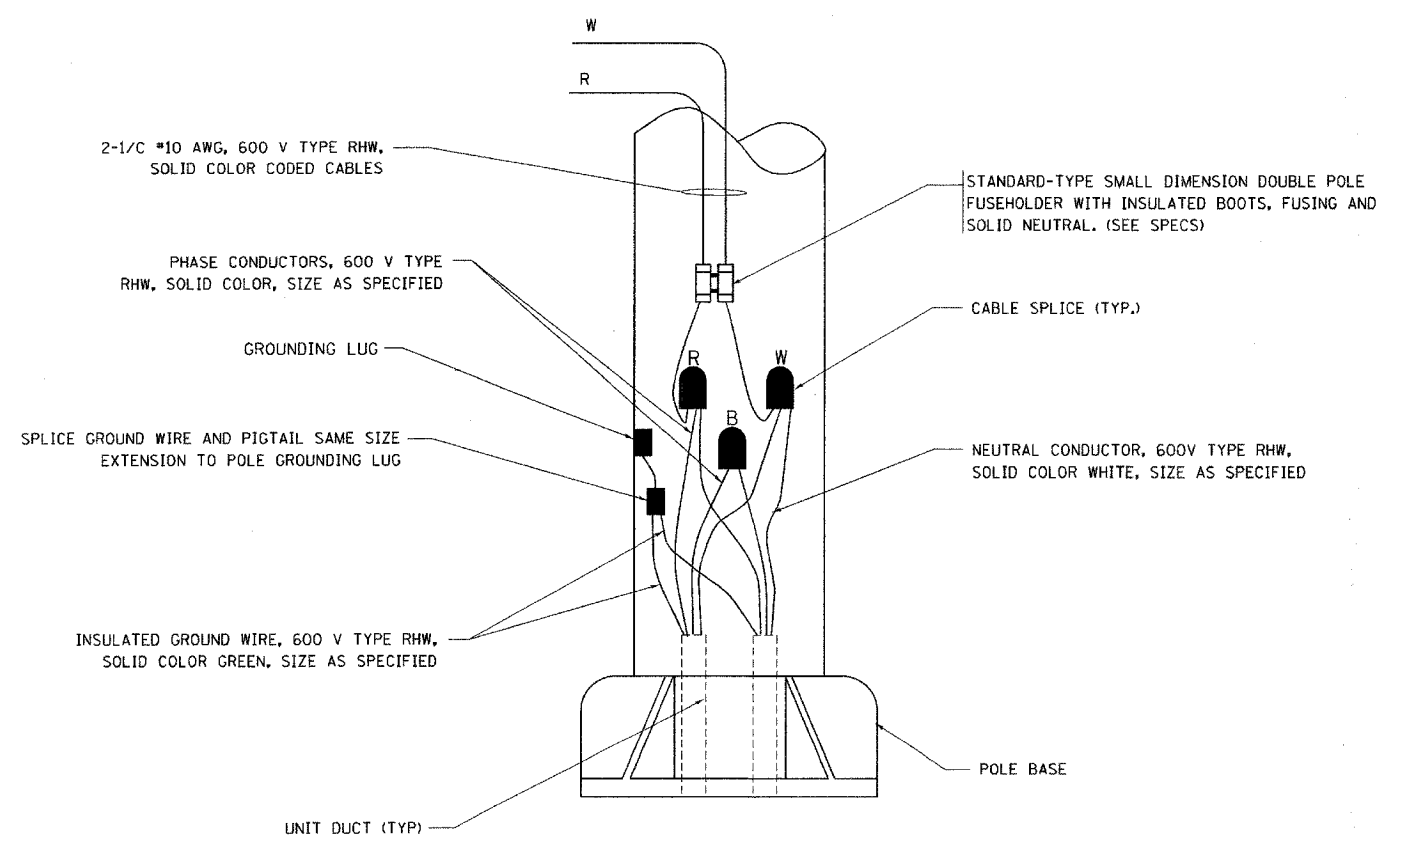

POLE WIRING DETAIL
N.T.S.

PLT DATE = 1/18/2007
 PLOT NAME = c:\projects\adstsd\be7e2.dgn
 PLOT NUMBER = 11
 USER NAME = gregjames

REVISIONS	
NAME	DATE

ILLINOIS DEPARTMENT OF TRANSPORTATION

MISC. ELECTRICAL DETAILS
SHEET A

SCALE: VERT.
HORIZ.
DATE: 1/18/2007

DRAWN BY
CHECKED BY
BE-702
REVISION DATE: 01/01/07