



OPERATION 5

- ⑨ RESURFACING WITH SMA SURFACE COURSE 2" ON LANE 2.
- ⑩ RESURFACING WITH HOT-MIX ASPHALT SURFACE COURSE 1 1/2" ON THE OUTER SHOULDER.
- ⑪ PAVEMENT MARKING TAPE, TYPE III

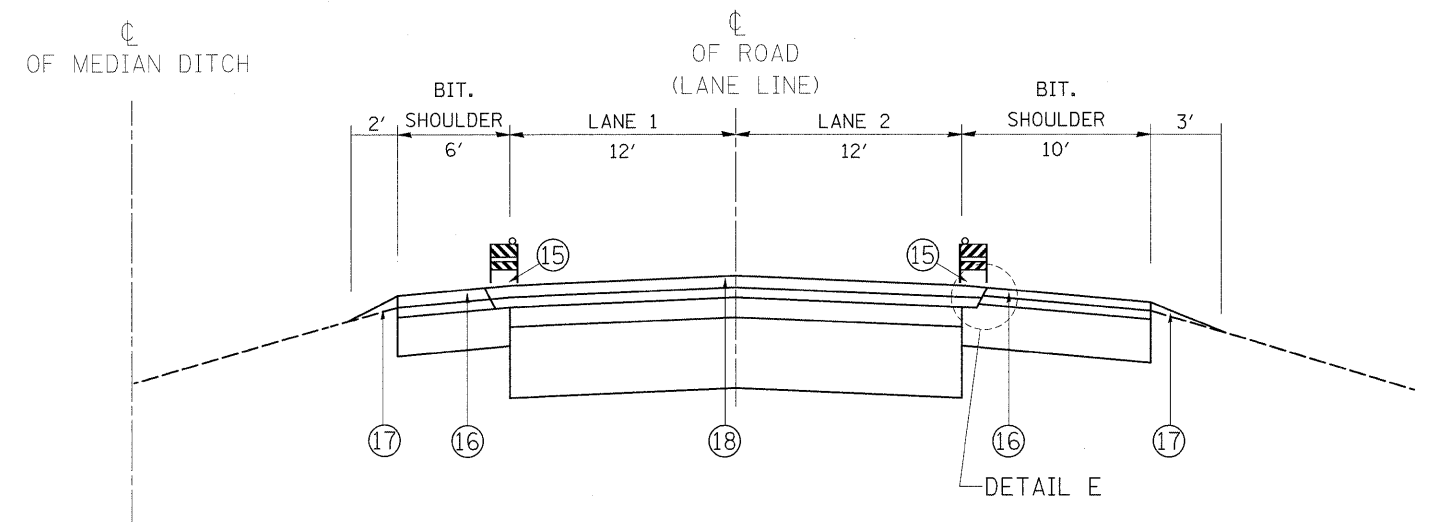

OPERATION 7

- ⑮ FINAL PAVEMENT MARKING WITH THERMOPLASTIC PAVEMENT MARKING, LINE 4"
- ⑯ INSTALL RUMBLE STRIPS ON INNER AND OUTER SHOULDER AS PER DETAIL ON PLAN.
- ⑰ PLACE AGGREGATE WEDGE SHOULDER, TYPE B.
- ⑱ PLACE RAISED REFLECTIVE PAVEMENT MARKERS AT LANE LINE AND RAMPS.

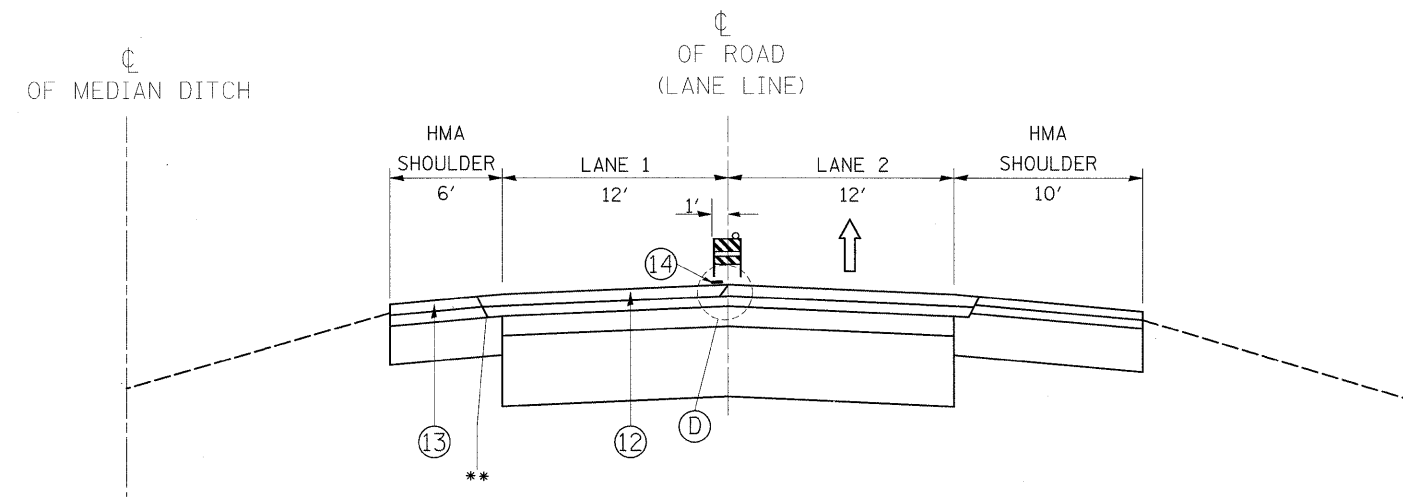

OPERATION 6

- ⑫ RESURFACING WITH SMA SURFACE COURSE 2" ON LANE 1
- ⑬ RESURFACING WITH SMA SURFACE COURSE 2" ON INNER SHOULDER
- ⑭ FINAL PAVEMENT MARKING WITH PREFORMED PLASTIC PAVEMENT MARKING TYPE B- INLAID-LINE 5"

NOTE:
BARRICADES/DRUMS TO BE PLACED ON THE SHOULDER WITHIN 2' OF THE EDGE OF THE PAVEMENT DURING NON-WORKING HOURS

FILE NAME =	USER NAME = abebawa	DESIGNED -	REVISED -	STATE OF ILLINOIS DEPARTMENT OF TRANSPORTATION	IL. ROUTE 57 SUGGESTED SEQUENCE OF OPERATIONS		F.A.I. RTE.	SECTION	COUNTY	TOTAL SHEETS	SHEET NO.		
ct:\pw\work\p\w\DOT\ABEBAWA\142330\017509-shr-plan.dgn		DRAWN -	REVISED -		SCALE:	SHEET NO. 1 OF 1 SHEETS	STA.	TO STA.	57	2009-064 RS	COOK	63	9
		CHECKED -	REVISED -		CONTRACT NO. 60H57								
		DATE -	REVISED -		ILLINOIS FED. AID PROJECT								