
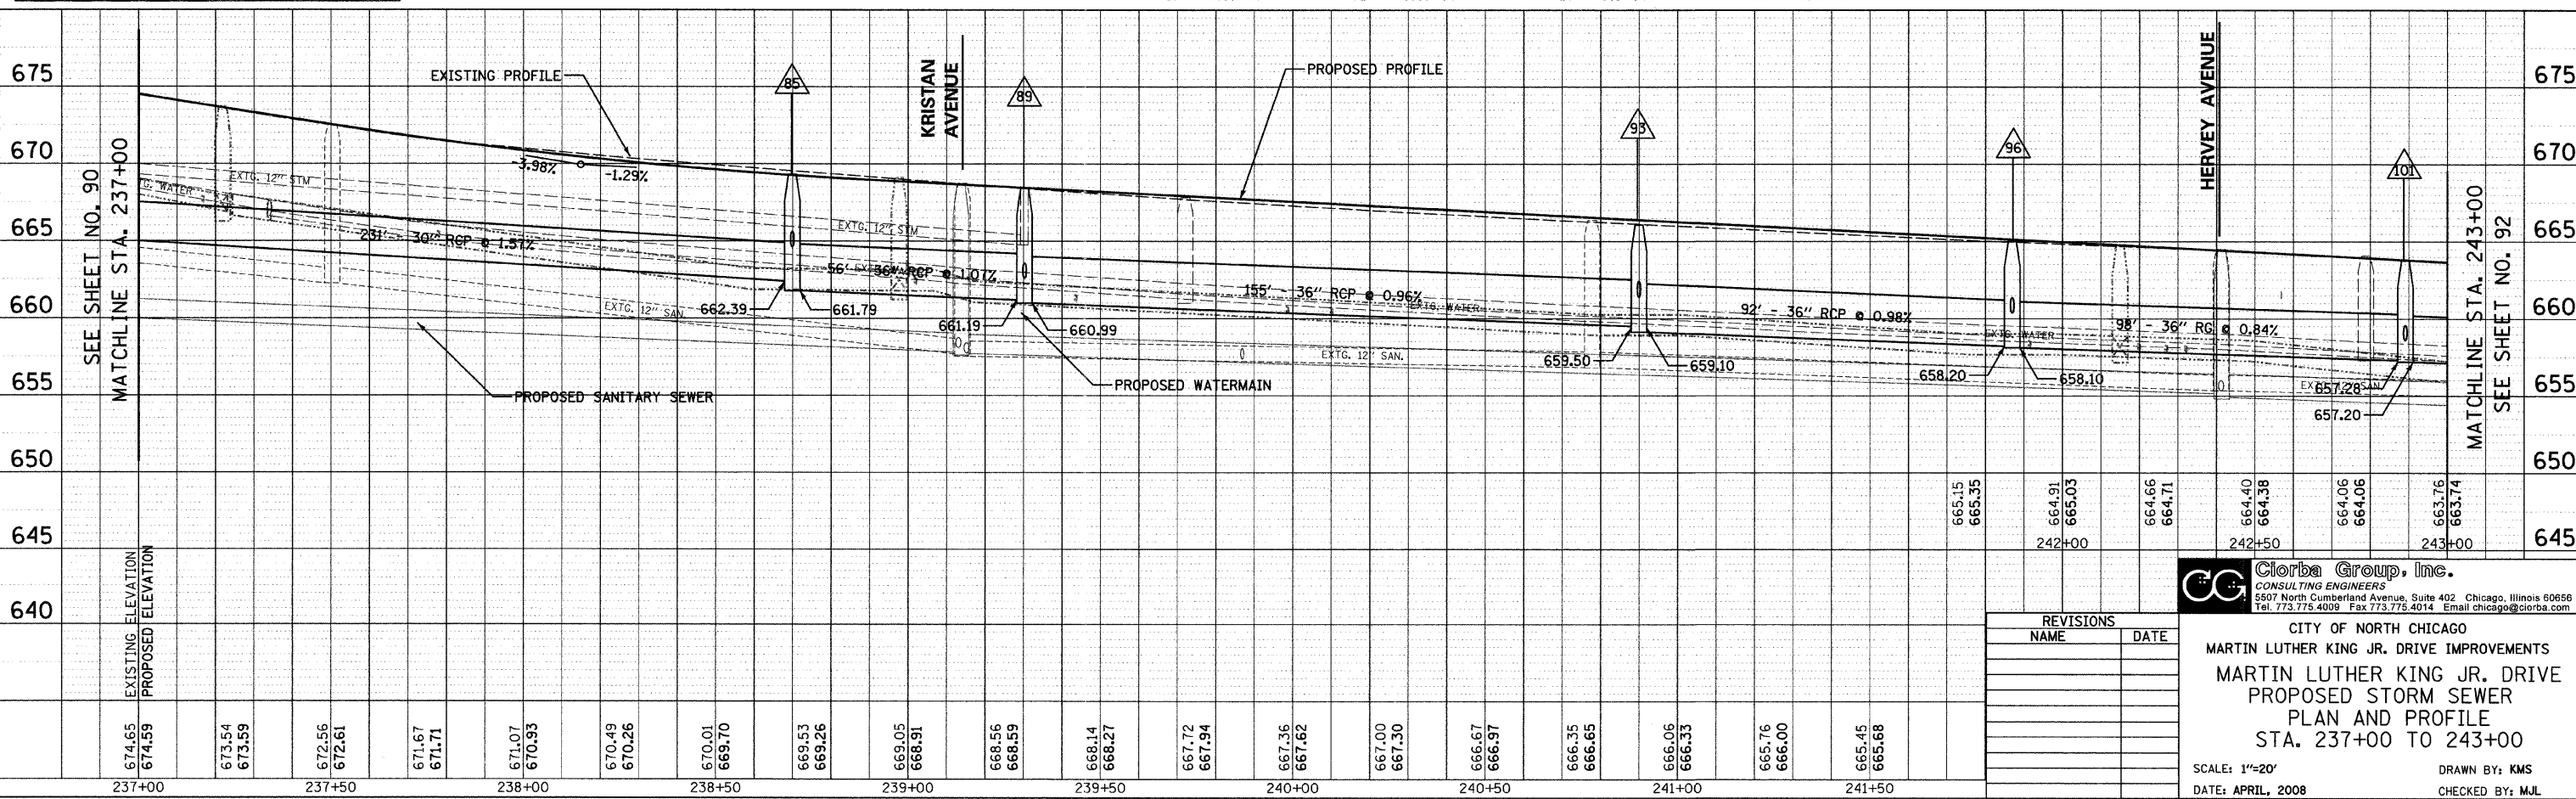


F.A.U. RITE.	SECTION	COUNTY	TOTAL SHEETS	SHEET NO.
1230 03-00159-00-PV	LAKE	262	91	
STA. 237+00 TO STA. 243+00		FED. ROAD DIST. NO. 1 ILLINOIS FED. AID PROJECT		
CONTRACT: 83828				

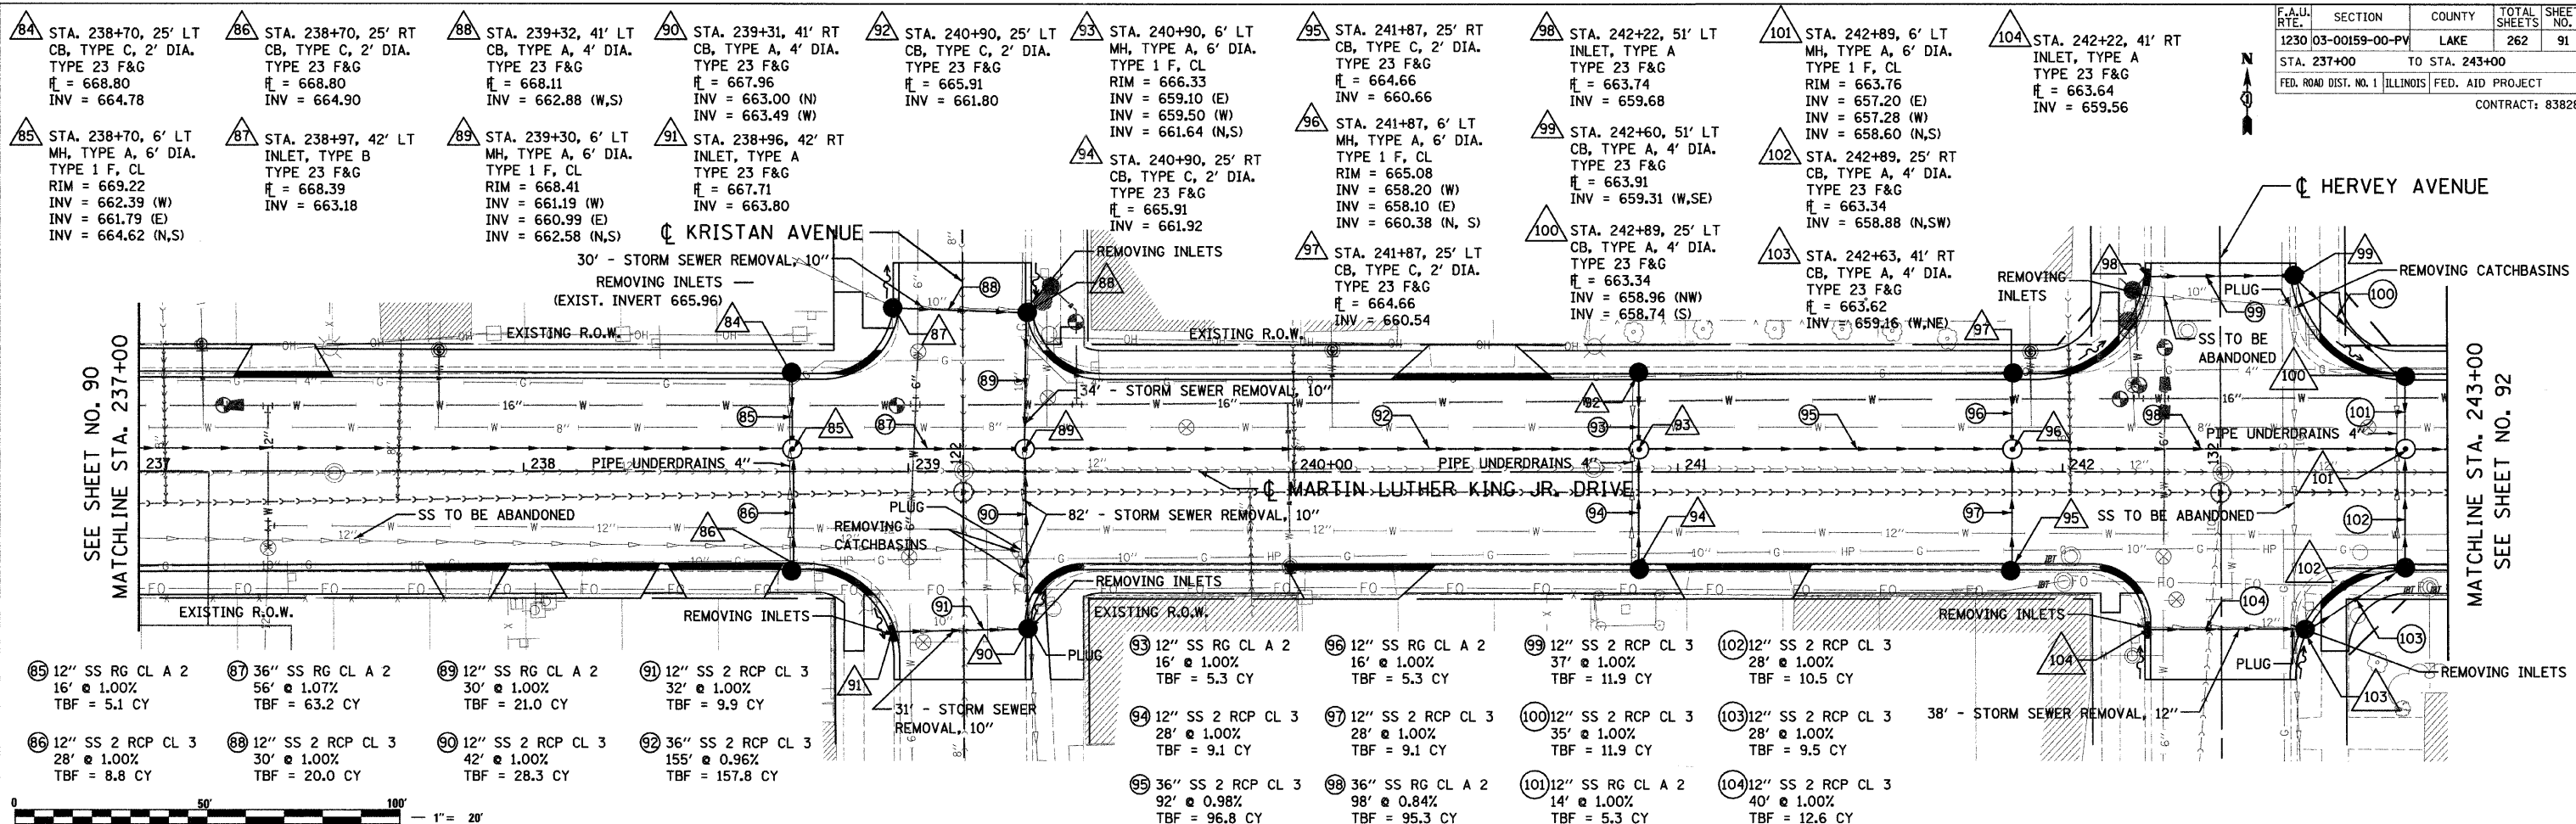

DATE	BY
7/1/2008	MJM
FILENAME: N:\PROJ\05161\Design\Drawings\61-CRN\07.dgn	

DATE	BY
7/1/2008	MJM
FILENAME: N:\PROJ\05161\Design\Drawings\61-CRN\07.dgn	

DATE	BY
7/1/2008	MJM
FILENAME: N:\PROJ\05161\Design\Drawings\61-CRN\07.dgn	

REVISIONS	
NAME	DATE

**Clorba Group, Inc.**  
CONSULTING ENGINEERS  
5507 North Cumberland Avenue, Suite 402 Chicago, Illinois 60656  
Tel. 773.775.4009 Fax 773.775.4014 Email chicago@clorba.com

CITY OF NORTH CHICAGO  
MARTIN LUTHER KING JR. DRIVE IMPROVEMENTS  
MARTIN LUTHER KING JR. DRIVE  
PROPOSED STORM SEWER  
PLAN AND PROFILE  
STA. 237+00 TO 243+00

SCALE: 1"=20'  
DATE: APRIL, 2008  
DRAWN BY: KMS  
CHECKED BY: MJL