
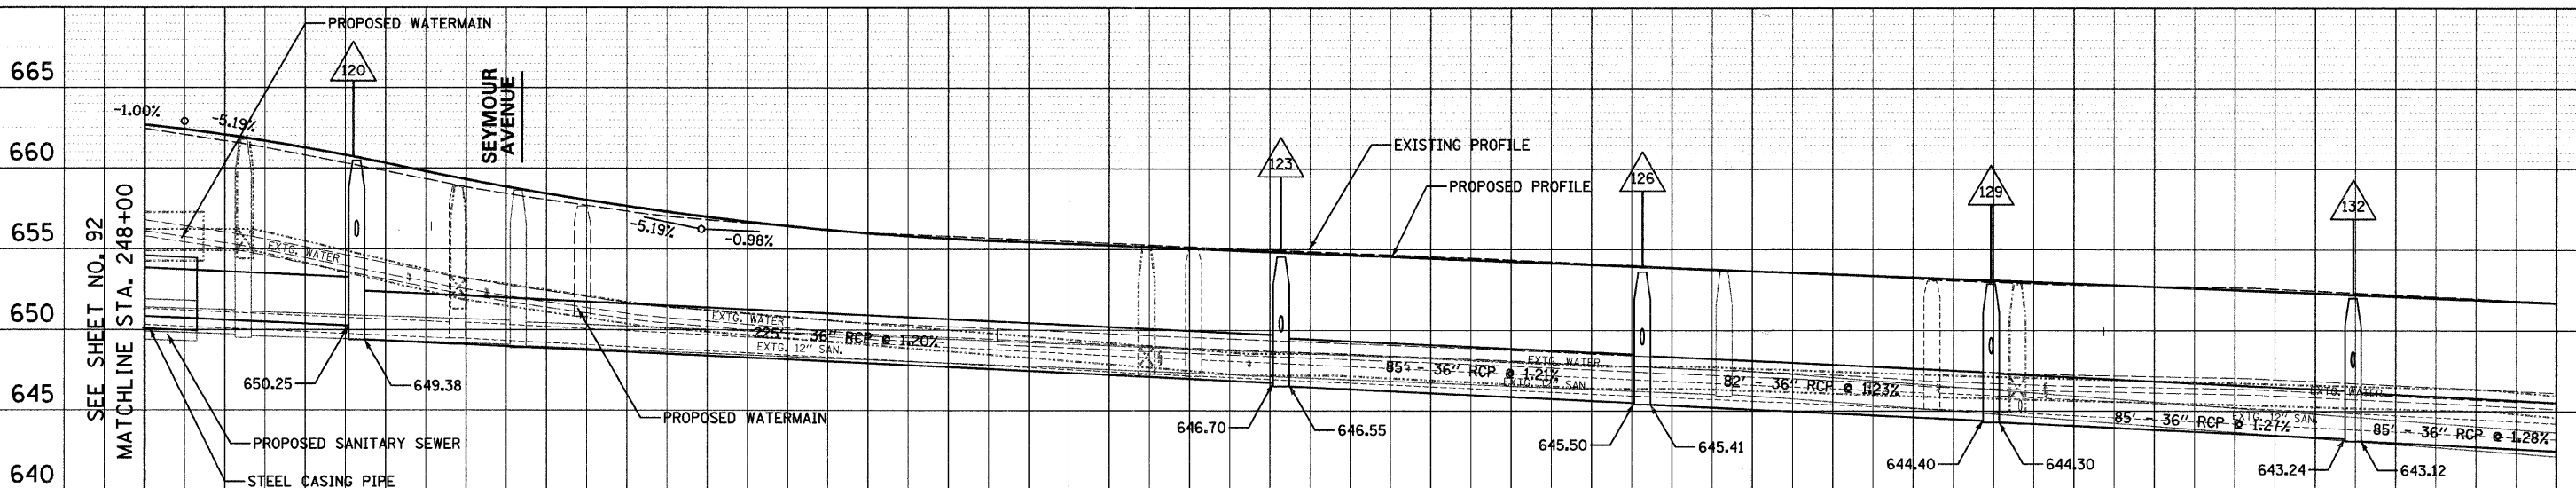


F.A.U. RTE.	SECTION	COUNTY	TOTAL SHEETS	SHEET NO.
1230	03-00159-00-PV	LAKE	262	93
STA. 248+00		TO STA. 254+00		
FED. ROAD DIST. NO. 1		ILLINOIS		FED. AID PROJECT
				CONTRACT: 83828

PLAN	DATE
BY	
REVISIONS	
NO.	
DESCRIPTION	

PROFILE	DATE
BY	
REVISIONS	
NO.	
DESCRIPTION	

DATE: 7/1/2008
 DRAWN BY: JMS
 FILENAME: N:\PROJECTS\161\Design\Drawings\161-DRN-09.dgn

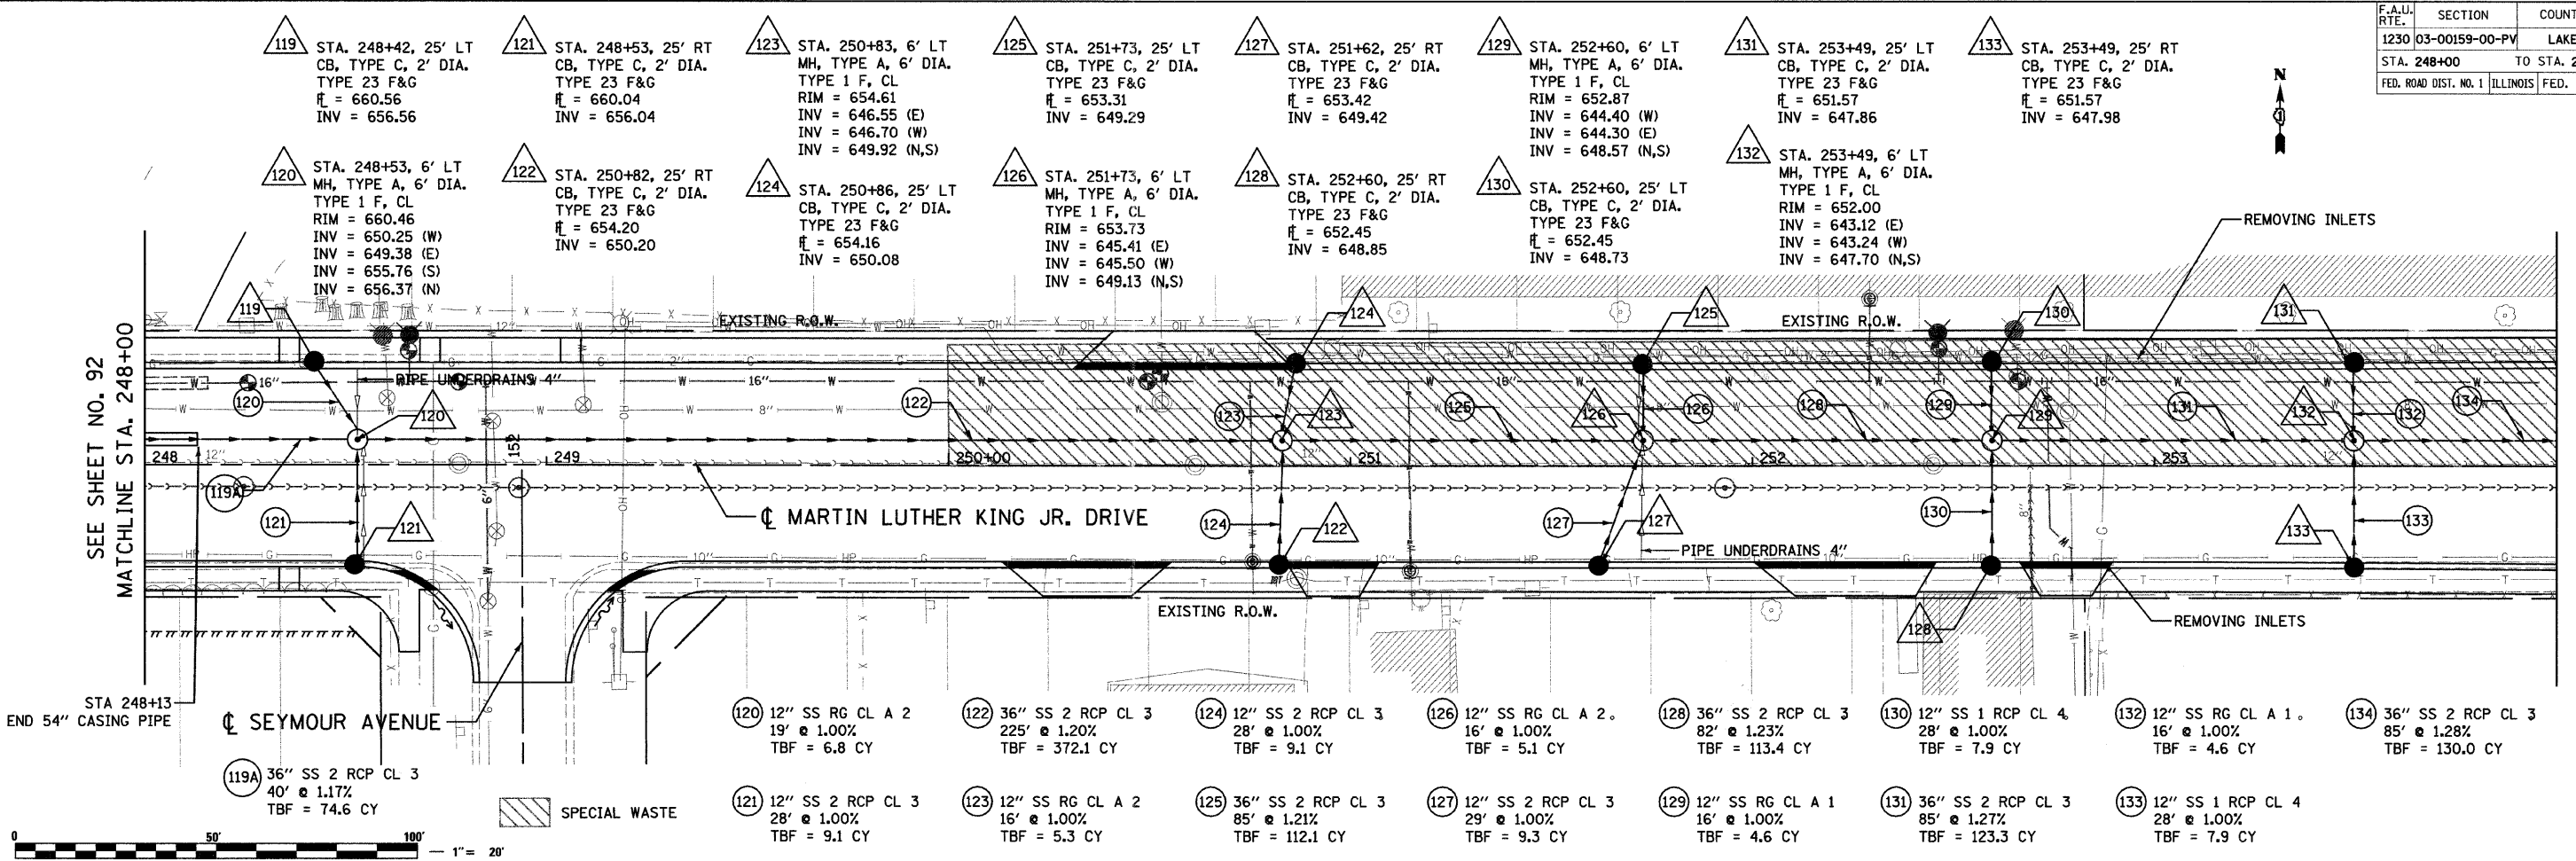

STATION	EXISTING ELEVATION	PROPOSED ELEVATION	PIPE SIZE	SLOPE	DEPTH	INVERT ELEVATION	MANHOLE
248+00	662.37	662.60	36" SS 2 RCP CL 3	1.17%	120 LF	659.01	119
248+50	661.43	661.80	36" SS 2 RCP CL 3	1.17%	120 LF	659.47	120
249+00	657.95	658.34	36" SS 2 RCP CL 3	1.00%	120 LF	658.34	121
249+50	656.52	656.60	36" SS 2 RCP CL 3	1.00%	120 LF	656.60	122
250+00	655.01	656.00	36" SS 2 RCP CL 3	1.00%	120 LF	656.00	123
250+50	655.72	655.87	36" SS 2 RCP CL 3	1.20%	120 LF	655.87	124
251+00	654.46	655.30	36" SS 2 RCP CL 3	1.20%	120 LF	655.30	125
251+50	654.18	655.06	36" SS 2 RCP CL 3	1.21%	120 LF	655.06	126
252+00	654.92	654.81	36" SS 2 RCP CL 3	1.00%	120 LF	654.81	127
252+50	654.43	654.32	36" SS 2 RCP CL 3	1.23%	120 LF	654.32	128
253+00	654.16	654.07	36" SS 2 RCP CL 3	1.00%	120 LF	654.07	129
253+50	653.88	653.83	36" SS 2 RCP CL 3	1.27%	120 LF	653.83	130
254+00	653.61	653.58	36" SS 2 RCP CL 3	1.27%	120 LF	653.58	131
254+00	653.34	653.34	36" SS 2 RCP CL 3	1.28%	120 LF	653.34	132
254+00	652.98	653.09	36" SS 2 RCP CL 3	1.28%	120 LF	653.09	133
254+00	652.75	652.85	36" SS 2 RCP CL 3	1.28%	120 LF	652.85	134

REVISIONS	
NAME	DATE

Clorba Group, Inc.
 CONSULTING ENGINEERS
 5507 North Cumberland Avenue, Suite 402 Chicago, Illinois 60656
 Tel. 773.775.4059 Fax. 773.775.4014 Email. chicago@clorba.com

CITY OF NORTH CHICAGO
 MARTIN LUTHER KING JR. DRIVE IMPROVEMENTS
 MARTIN LUTHER KING JR. DRIVE
 PROPOSED STORM SEWER
 PLAN AND PROFILE
 STA. 248+00 TO 254+00

SCALE: 1"=20'
 DATE: APRIL, 2008
 DRAWN BY: KMS
 CHECKED BY: MJL