


F.A.U. RTE.	SECTION	COUNTY	TOTAL SHEETS	SHEET NO.
1230	03-00159-00-PV	LAKE	262	188
STA. 169+00		TO STA. 171+90		
FED. ROAD DIST. NO. 1		ILLINOIS	FED. AID PROJECT	
CONTRACT: 83828				

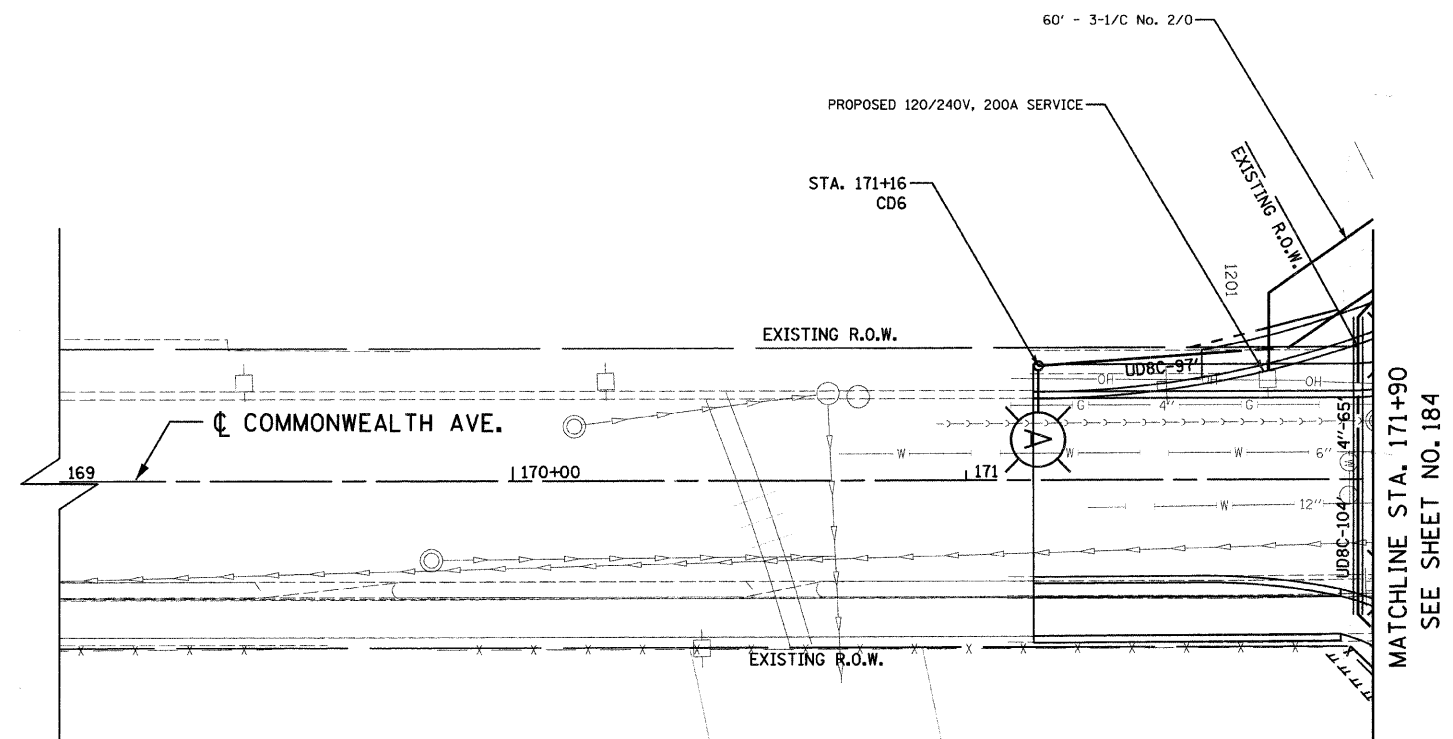


LEGEND


- ⓔ-○ - EXISTING LIGHT POLE, SIZE AND TYPE AS NOTED
- ⓐ-○ - INSTALL LIGHT POLE, 30' M.H., 6' M.A., 310W DECORATIVE LUMINAIRE & 70W PEDESTRIAN LUMINAIRE
- ⓑ-○ - INSTALL LIGHT POLE, 45' M.H., 15' M.A. AND 400W COBRA-HEAD LUMINAIRE
- ⓒ-○ - INSTALL 400W COBRA-HEAD LUMINAIRE ON STEEL COMBINATION MAST ARM AND ASSEMBLY POLE
- UD8C-10' UNIT DUCT WITH 7-1/C NO. 4 AND 1/C NO. 6 GROUND, 600V (EPR-TYPE RHW) 2" POLYETHYLENE AND LENGTH AS NOTED
- 4"-10' GALVANIZED STEEL CONDUIT, PUSHED, DIAMETER AND LENGTH AS NOTED
- ▭ INSTALL LIGHTING CONTROLLER, 120/240 VOLT, 100 AMP
- F INSTALL OFFSET FOUNDATION SEE SHEET 193
- BOLLARD

NOTE

1. POLES SHALL BE OFFSET 6.5' FROM EDGE OF PAVEMENT, UNLESS OTHERWISE NOTED

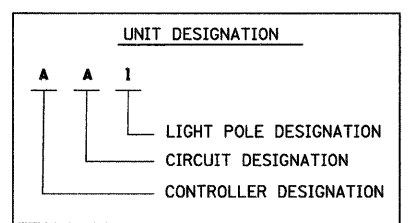

NO UNDERGROUND SPLICING ALLOWED

 

COMMONWEALTH AVENUE

Clorba Group, Inc.
CONSULTING ENGINEERS
5507 North Cumberland Avenue, Suite 402 Chicago, Illinois 60656
Tel. 773.775.4009 Fax 773.775.4014 Email: chicago@clorba.com

CITY OF NORTH CHICAGO
MARTIN LUTHER KING JR. DRIVE IMPROVEMENTS

COMMONWEALTH AVENUE
PROPOSED LIGHTING PLAN
STA. 169+00 TO 171+90

REVISIONS	
NAME	DATE

SCALE: 1"=20'
DATE: APRIL, 2008
DRAWN BY: KDM
CHECKED BY: JMW

DATE: 7/1/2008
TIME: 12:37:47 PM
FILENAME: N:\PROJ\5161\Design\Lighting\5161-LgtPlan14.dgn