
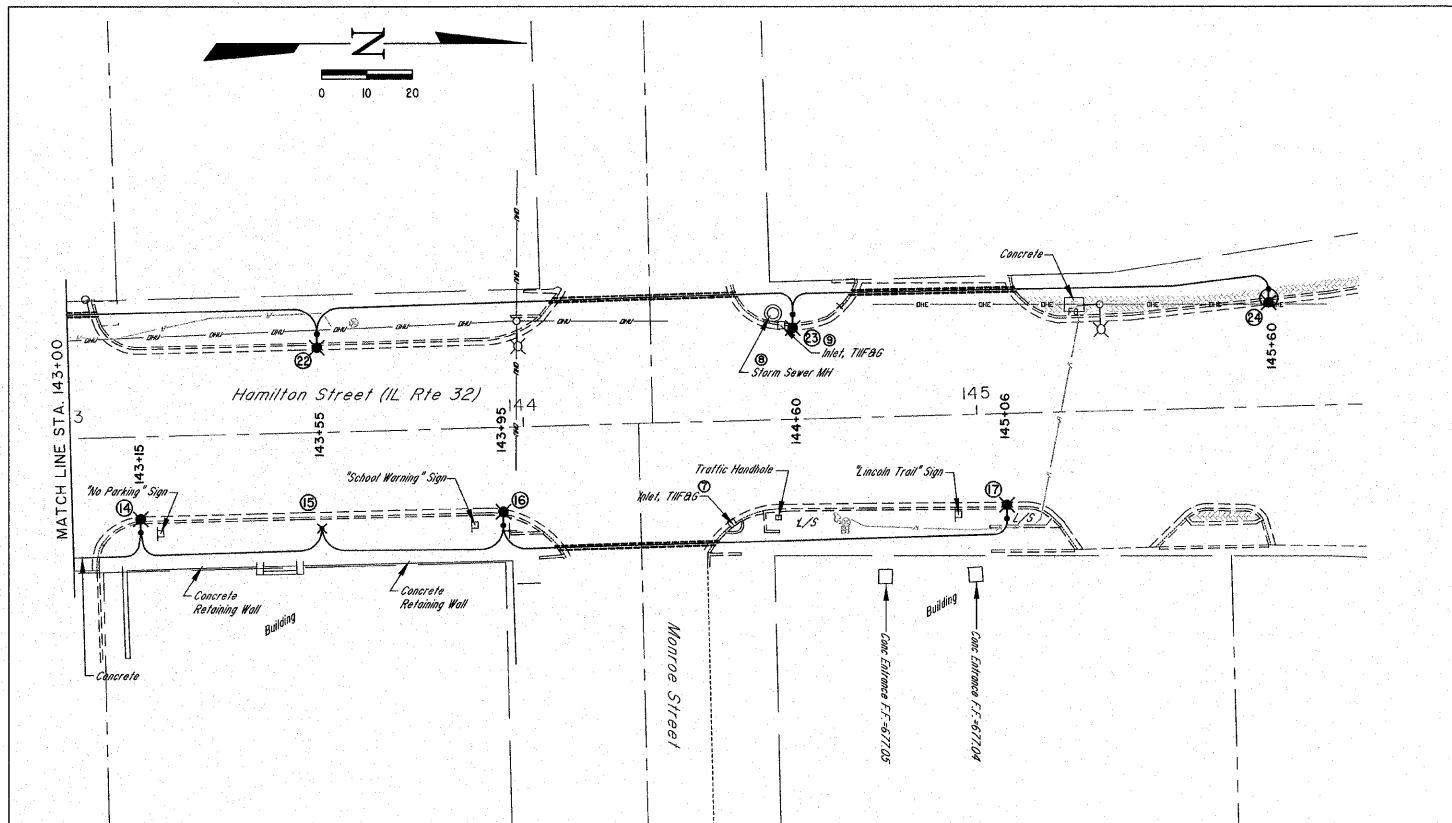
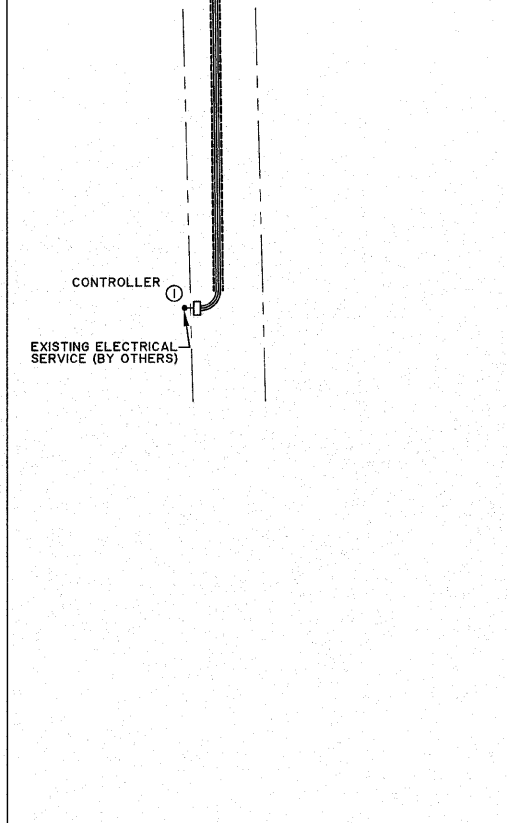


|                       |               |                   |              |           |
|-----------------------|---------------|-------------------|--------------|-----------|
| ROUTE NO.             | SECTION       | COUNTY            | TOTAL SHEETS | SHEET NO. |
| S&L                   | 06-0032-00-SW | MOULTRIE          | 24           | 16        |
| FED. ROAD DIST. NO. 7 | ILLINOIS      | FED. AID PROJECT- |              |           |

CONTRACT #95561

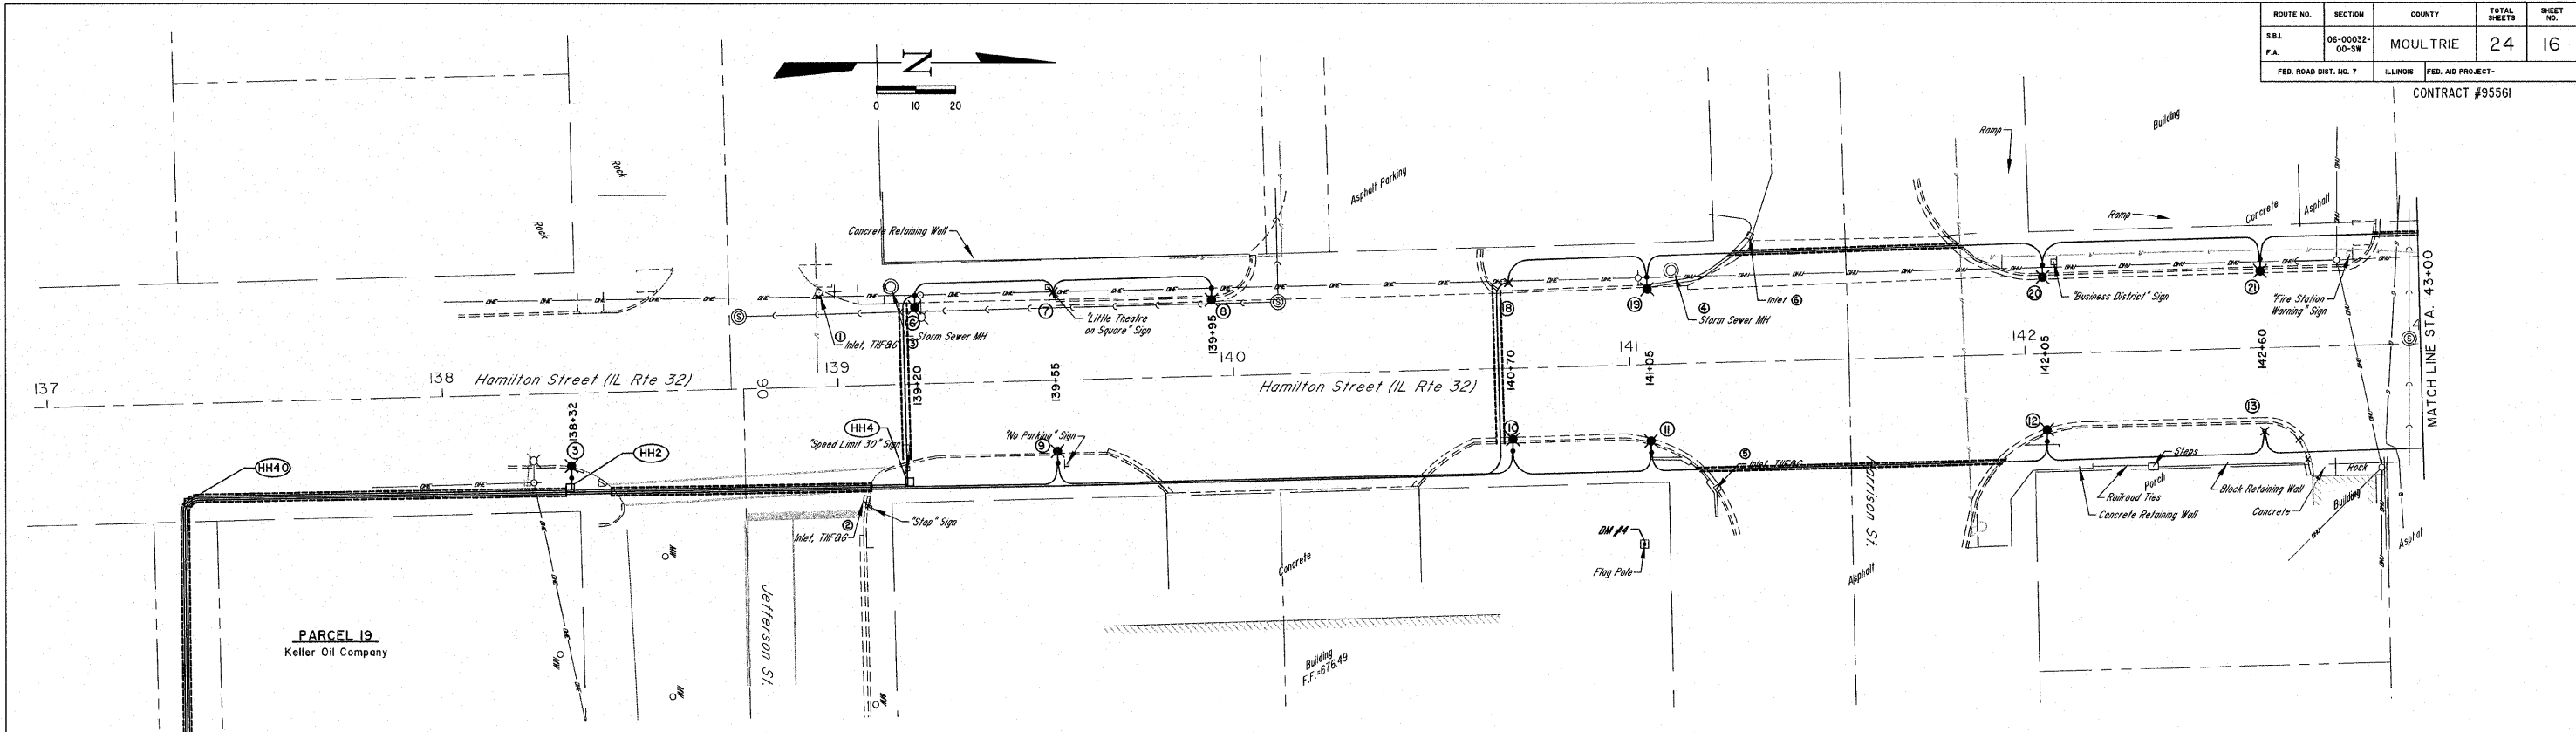

NOTE:  
LIGHT POLE #5 OMITTED

**MILANO & GRUNLOH ENGINEERS, LLC**  
 34 WEST WASHINGTON  
 P.O. BOX 897  
 EFFINGHAM, ILLINOIS 62401  
 Phone: (617) 547-7262  
 (800) 677-2714  
 Fax #: (617) 542-3433  
 Web Address: www.mgengineers.com  
 Design Firm #: 184-00308

ELECTRICAL PLAN  
 HAMILTON STREET (ILL RTE 32)  
 SIDEWALK ENHANCEMENT  
 CITY OF SULLIVAN  
 MOULTRIE CO., ILLINOIS

File name: S:\DWG\06\06244\dwg\Plans.dwg  
 Plot date: 9/6/07 at 13:45 F.B. 620