 
 





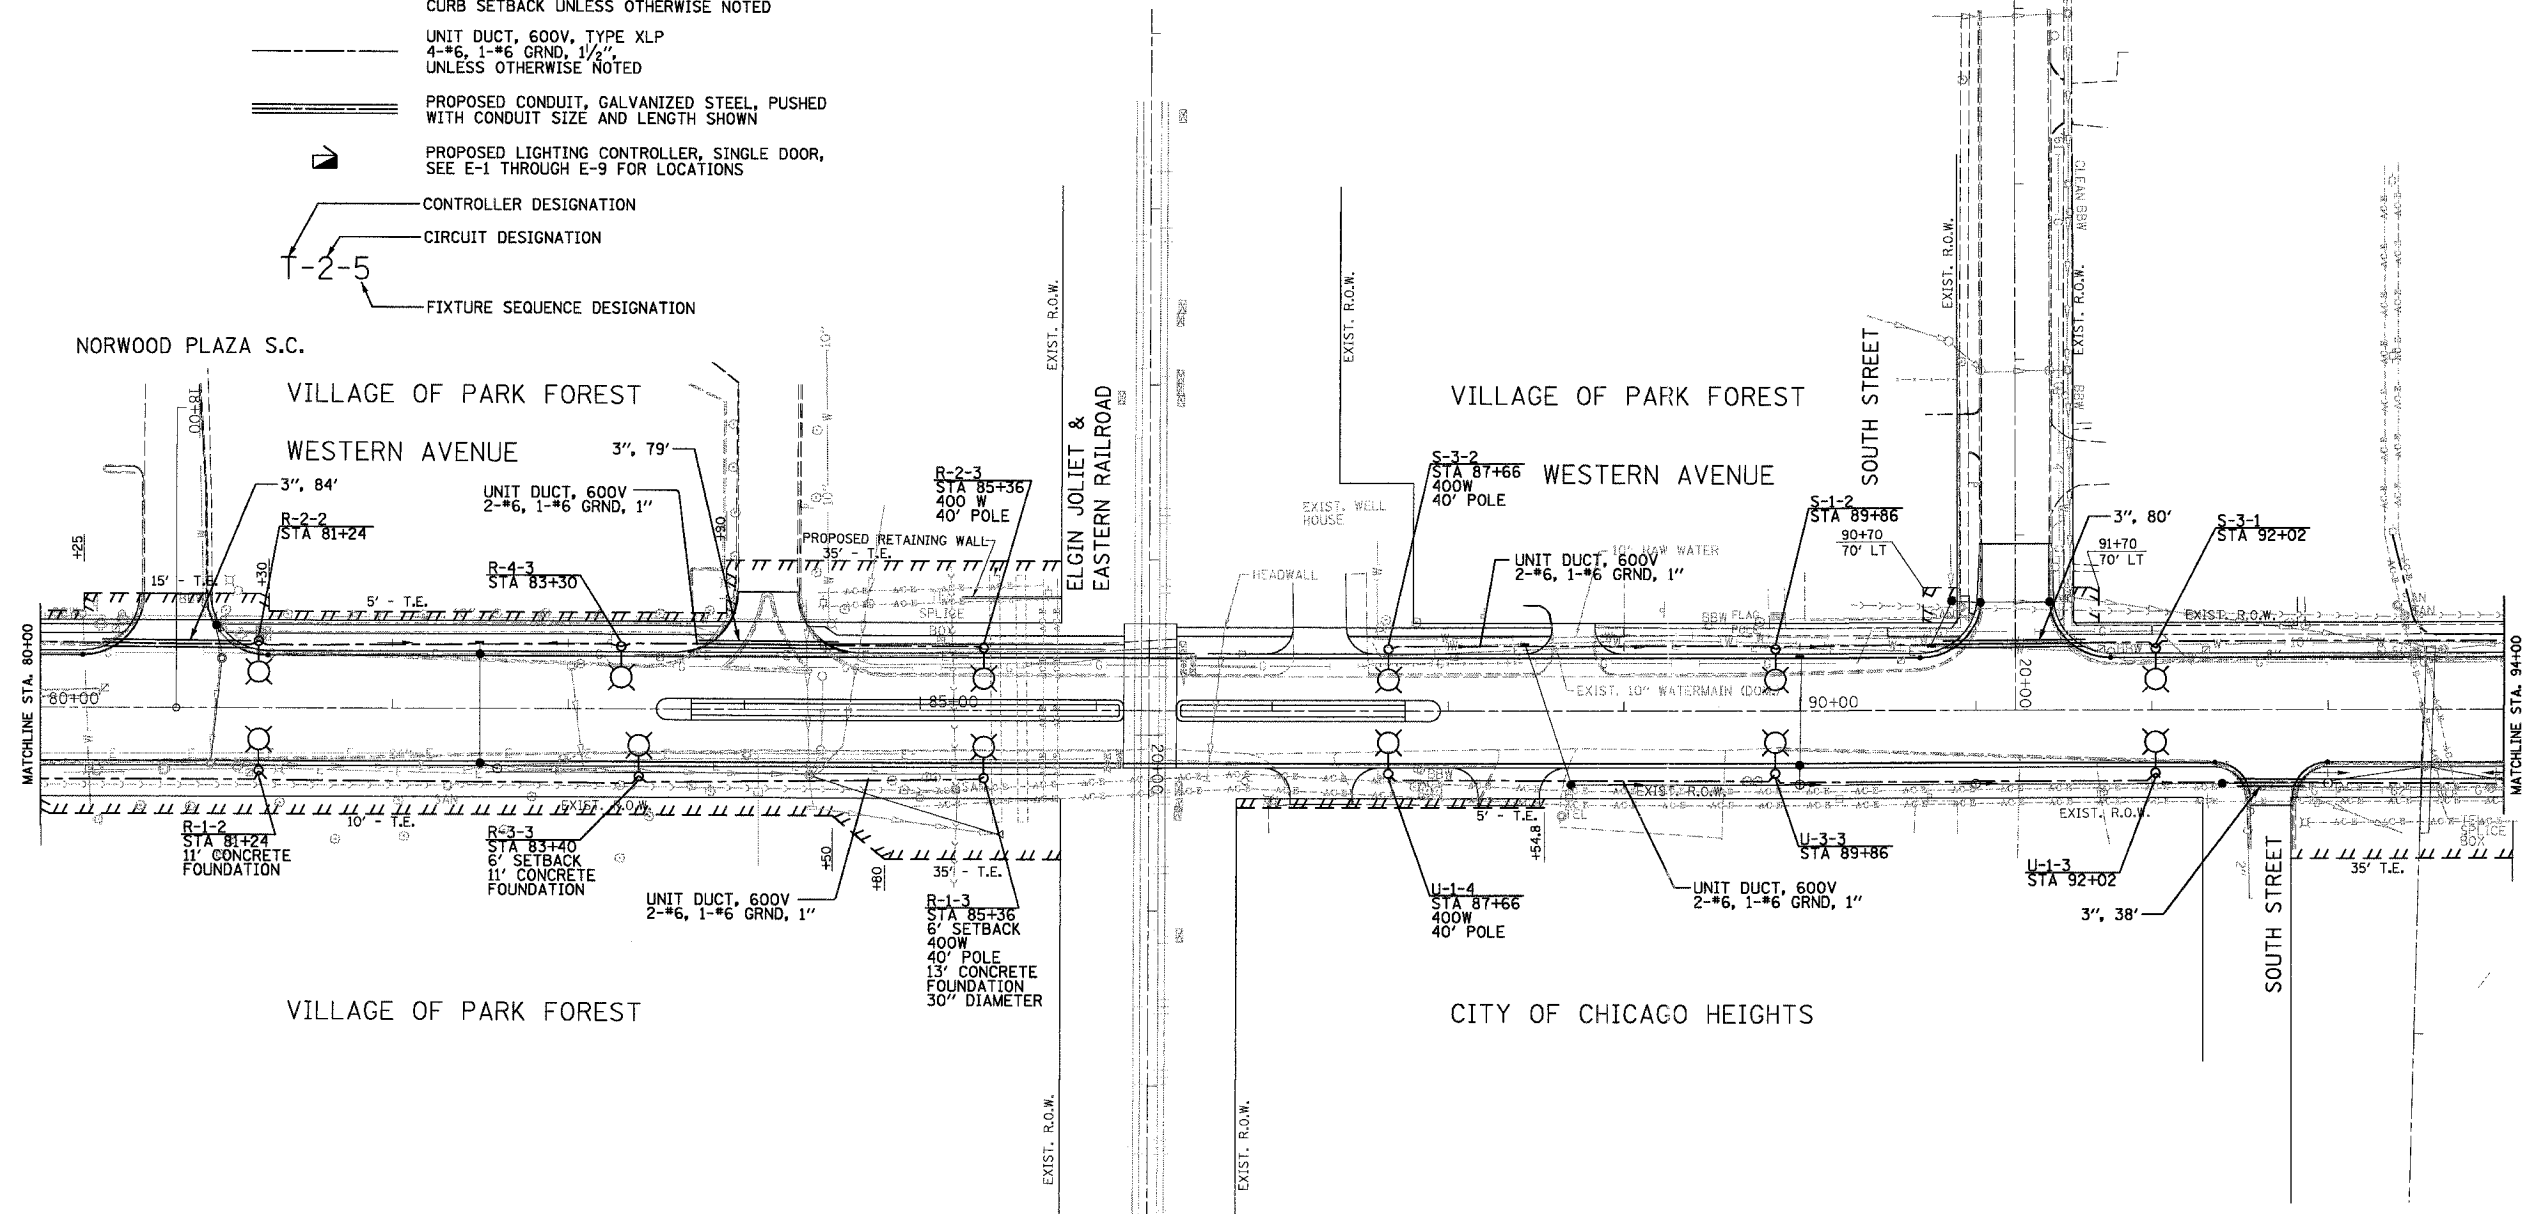



F.A. RTE.	SECTION	COUNTY	TOTAL SHEETS	SHEET NO.
2845	3152 WRS	COOK	195	140
STA. 80+00		TO STA. 94+00		
FED. ROAD DIST. NO. 1		ILLINOIS FED. AID PROJECT		

LEGEND:

-  PROPOSED SINGLE ARM LIGHTING UNIT
35' MOUNTING HEIGHT, 12' MAST ARM,
250 W LUMINAIRE METAL HELIX FNDN
BREAKAWAY TYPE WITH 3' BACK OF
CURB SETBACK UNLESS OTHERWISE NOTED
-  UNIT DUCT, 600V, TYPE XLP
4-#6, 1-#6 GRND, 1/2"
UNLESS OTHERWISE NOTED
-  PROPOSED CONDUIT, GALVANIZED STEEL, PUSHED
WITH CONDUIT SIZE AND LENGTH SHOWN
-  PROPOSED LIGHTING CONTROLLER, SINGLE DOOR,
SEE E-1 THROUGH E-9 FOR LOCATIONS
-  CONTROLLER DESIGNATION
-  CIRCUIT DESIGNATION
-  FIXTURE SEQUENCE DESIGNATION



GRAPHIC SCALE

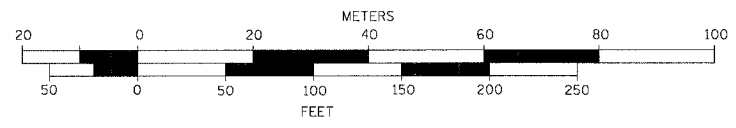

E-16

REVISIONS	
NAME	DATE

ILLINOIS DEPARTMENT OF TRANSPORTATION

WESTERN AVE.
PROPOSED LIGHTING PLAN

SCALE: 1" = 50'
DATE: 1/7/07

DRAWN BY: A.P.
CHECKED BY: G.A.O.

EPSTEIN
A. EPSTEIN AND SONS INTERNATIONAL, INC.
800 WEST FULLON STREET CHICAGO, ILLINOIS 60607-1100
T: 312-454-9100 F: 312-859-1217 www.epstein-intl.com
CHICAGO LOS ANGELES TEL AVIV WARSAW BUCHAREST

PLOT DATE = 5/10/2007
PLOT NAME = #FILED#
PLOT NUMBER = #USER#
USER NAME = #USER#