


F.A. RTE.	SECTION	COUNTY	TOTAL SHEETS	SHEET NO.
2845	3152 WRS	COOK	192	149
STA. -		TO STA. -		
FED. ROAD DIST. NO. 1		ILLINOIS FED. AID PROJECT		

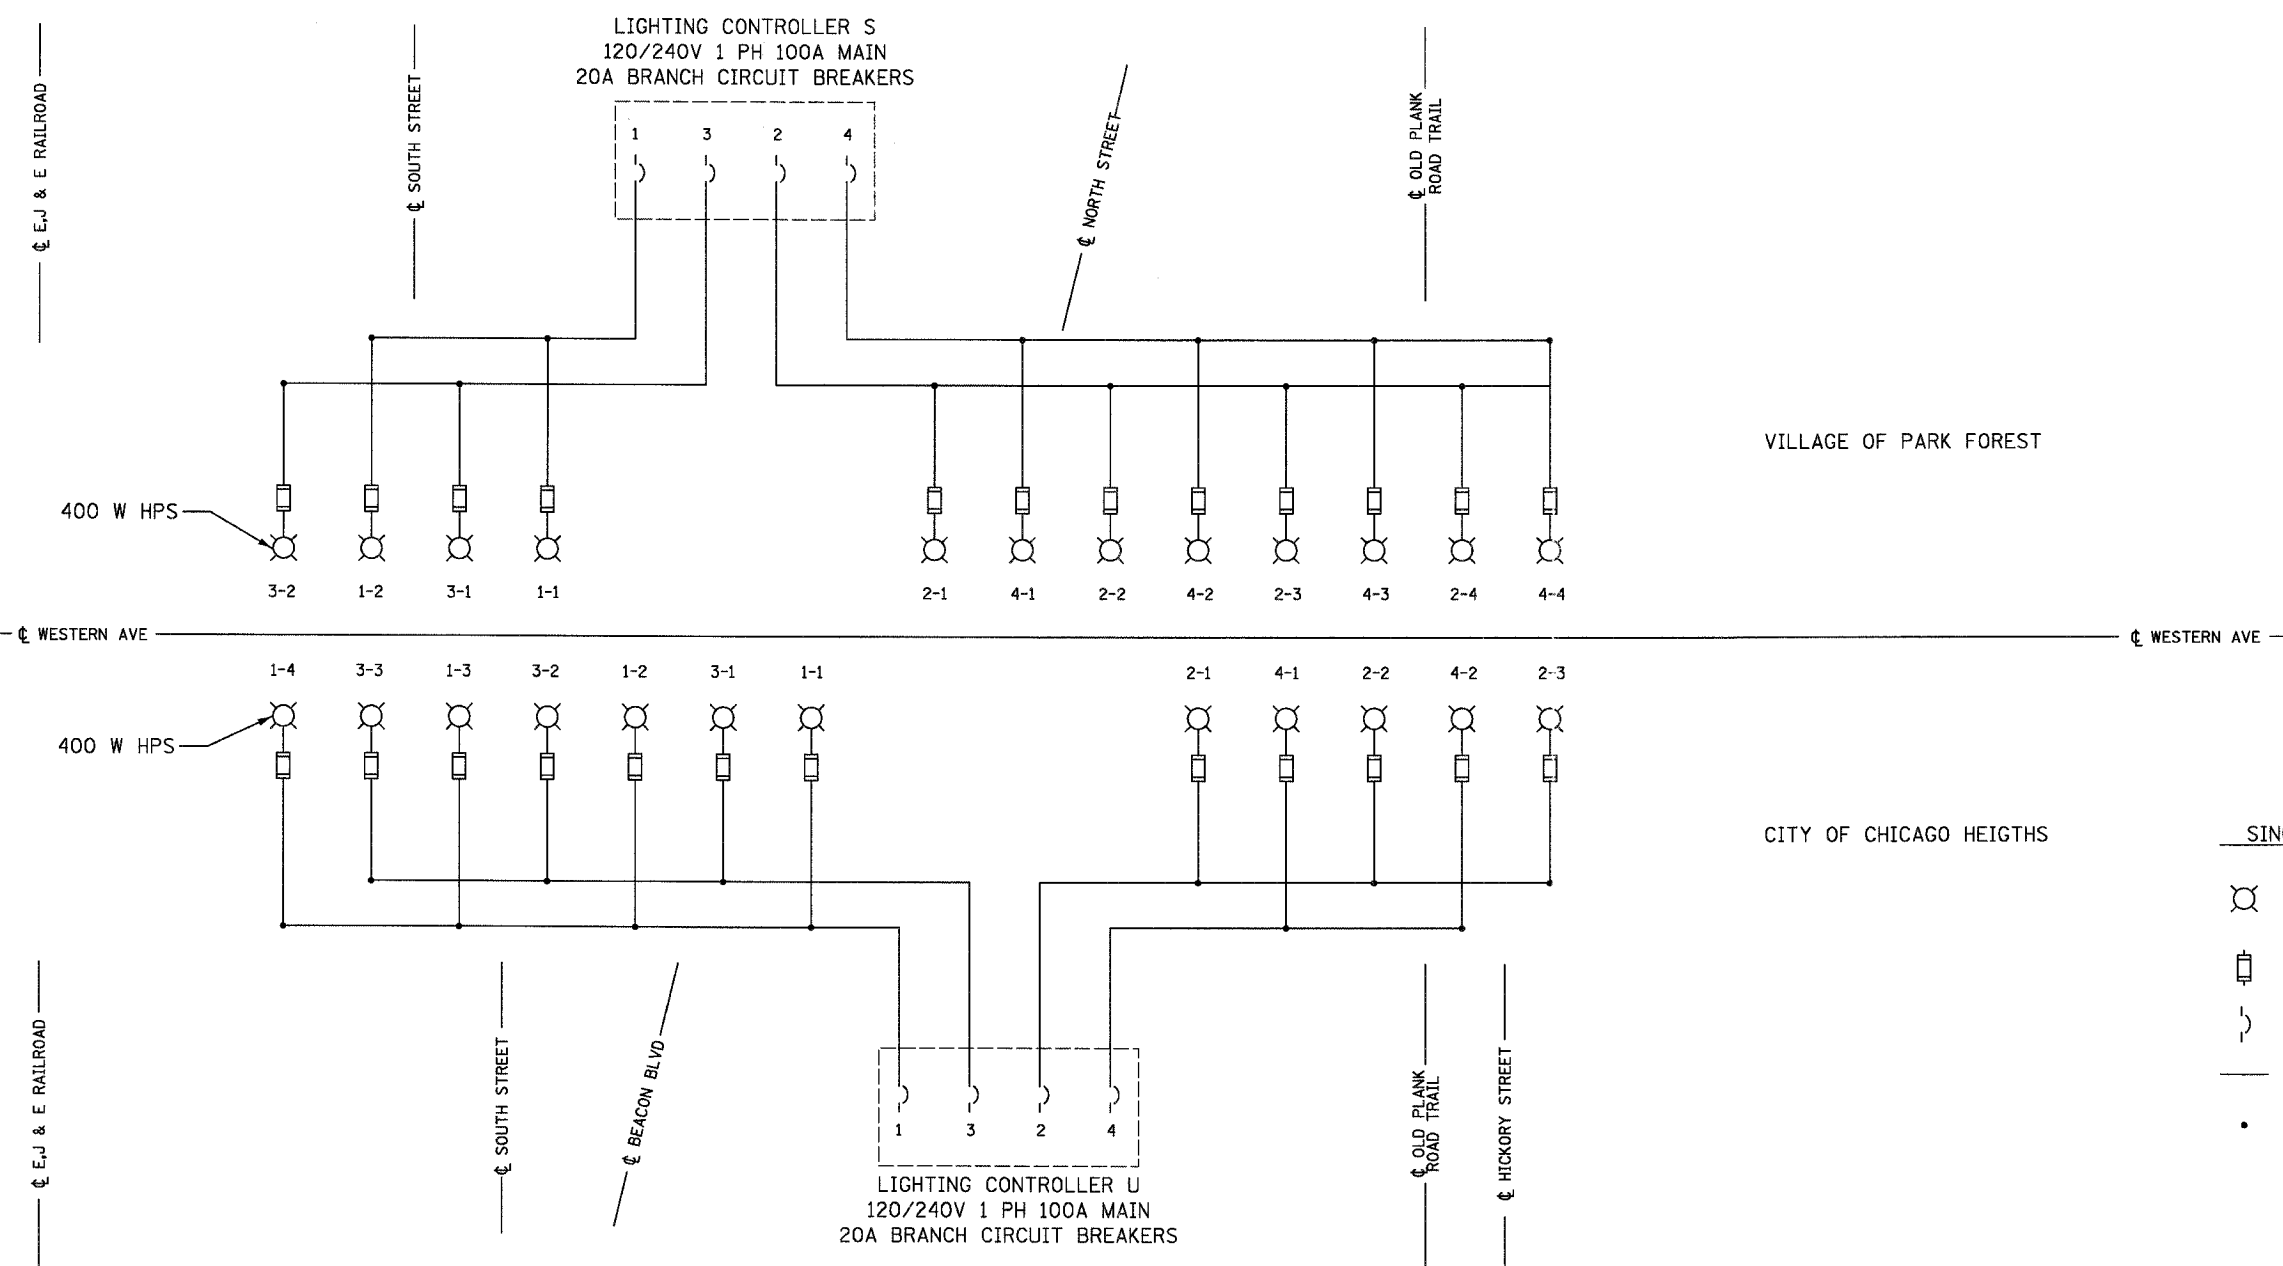

VILLAGE OF PARK FOREST

CITY OF CHICAGO HEIGHTS

- SINGLE LINE LEGEND**
- ⊗ LUMINAIRE, 250 W HPS, U.O.N.
 - ⊞ FUSE, 5A UNLESS OTHERWISE INDICATED
 - ⌋ CIRCUIT BREAKER
 - 3 1/C #6 & 1/C #6 GND
 - CONNECTION

LOAD TABULATION
CONTROLLER S

CIRCUIT	LOAD (WATTS)
S-1	672
S-2	1344
S-3	840
S-4	1344

LOAD TABULATION
CONTROLLER U

CIRCUIT	LOAD (WATTS)
U-1	1512
U-2	1008
U-3	1008
U-4	672

E-24

REVISIONS	
NAME	DATE

ILLINOIS DEPARTMENT OF TRANSPORTATION

**WESTERN AVE.
ONE LINE DIAGRAM
CONTROLLER S & U**

SCALE: N.T.S. DRAWN BY: A.P.
DATE: 1/7/07 CHECKED BY: G.A.O.

EPSTEIN

A. EPSTEIN AND SONS INTERNATIONAL, INC.
800 WEST FULLON STREET, CHICAGO, ILLINOIS 60661-1100
T: 312-454-0100 F: 312-869-1917 www.epstein-isi.com
CHICAGO LOS ANGELES TEL AVIV WARSAW BUCHAREST

PLT DATE = 5/10/2007
 FILE NAME = 014514
 USER NAME = RUBEN*