


F.A. RTE.	SECTION	COUNTY	TOTAL SHEETS	SHEET NO.
2845	3152 WRS	COOK	195	149
STA. -		TO STA. -		
FED. ROAD DIST. NO. 1		ILLINOIS		FED. AID PROJECT

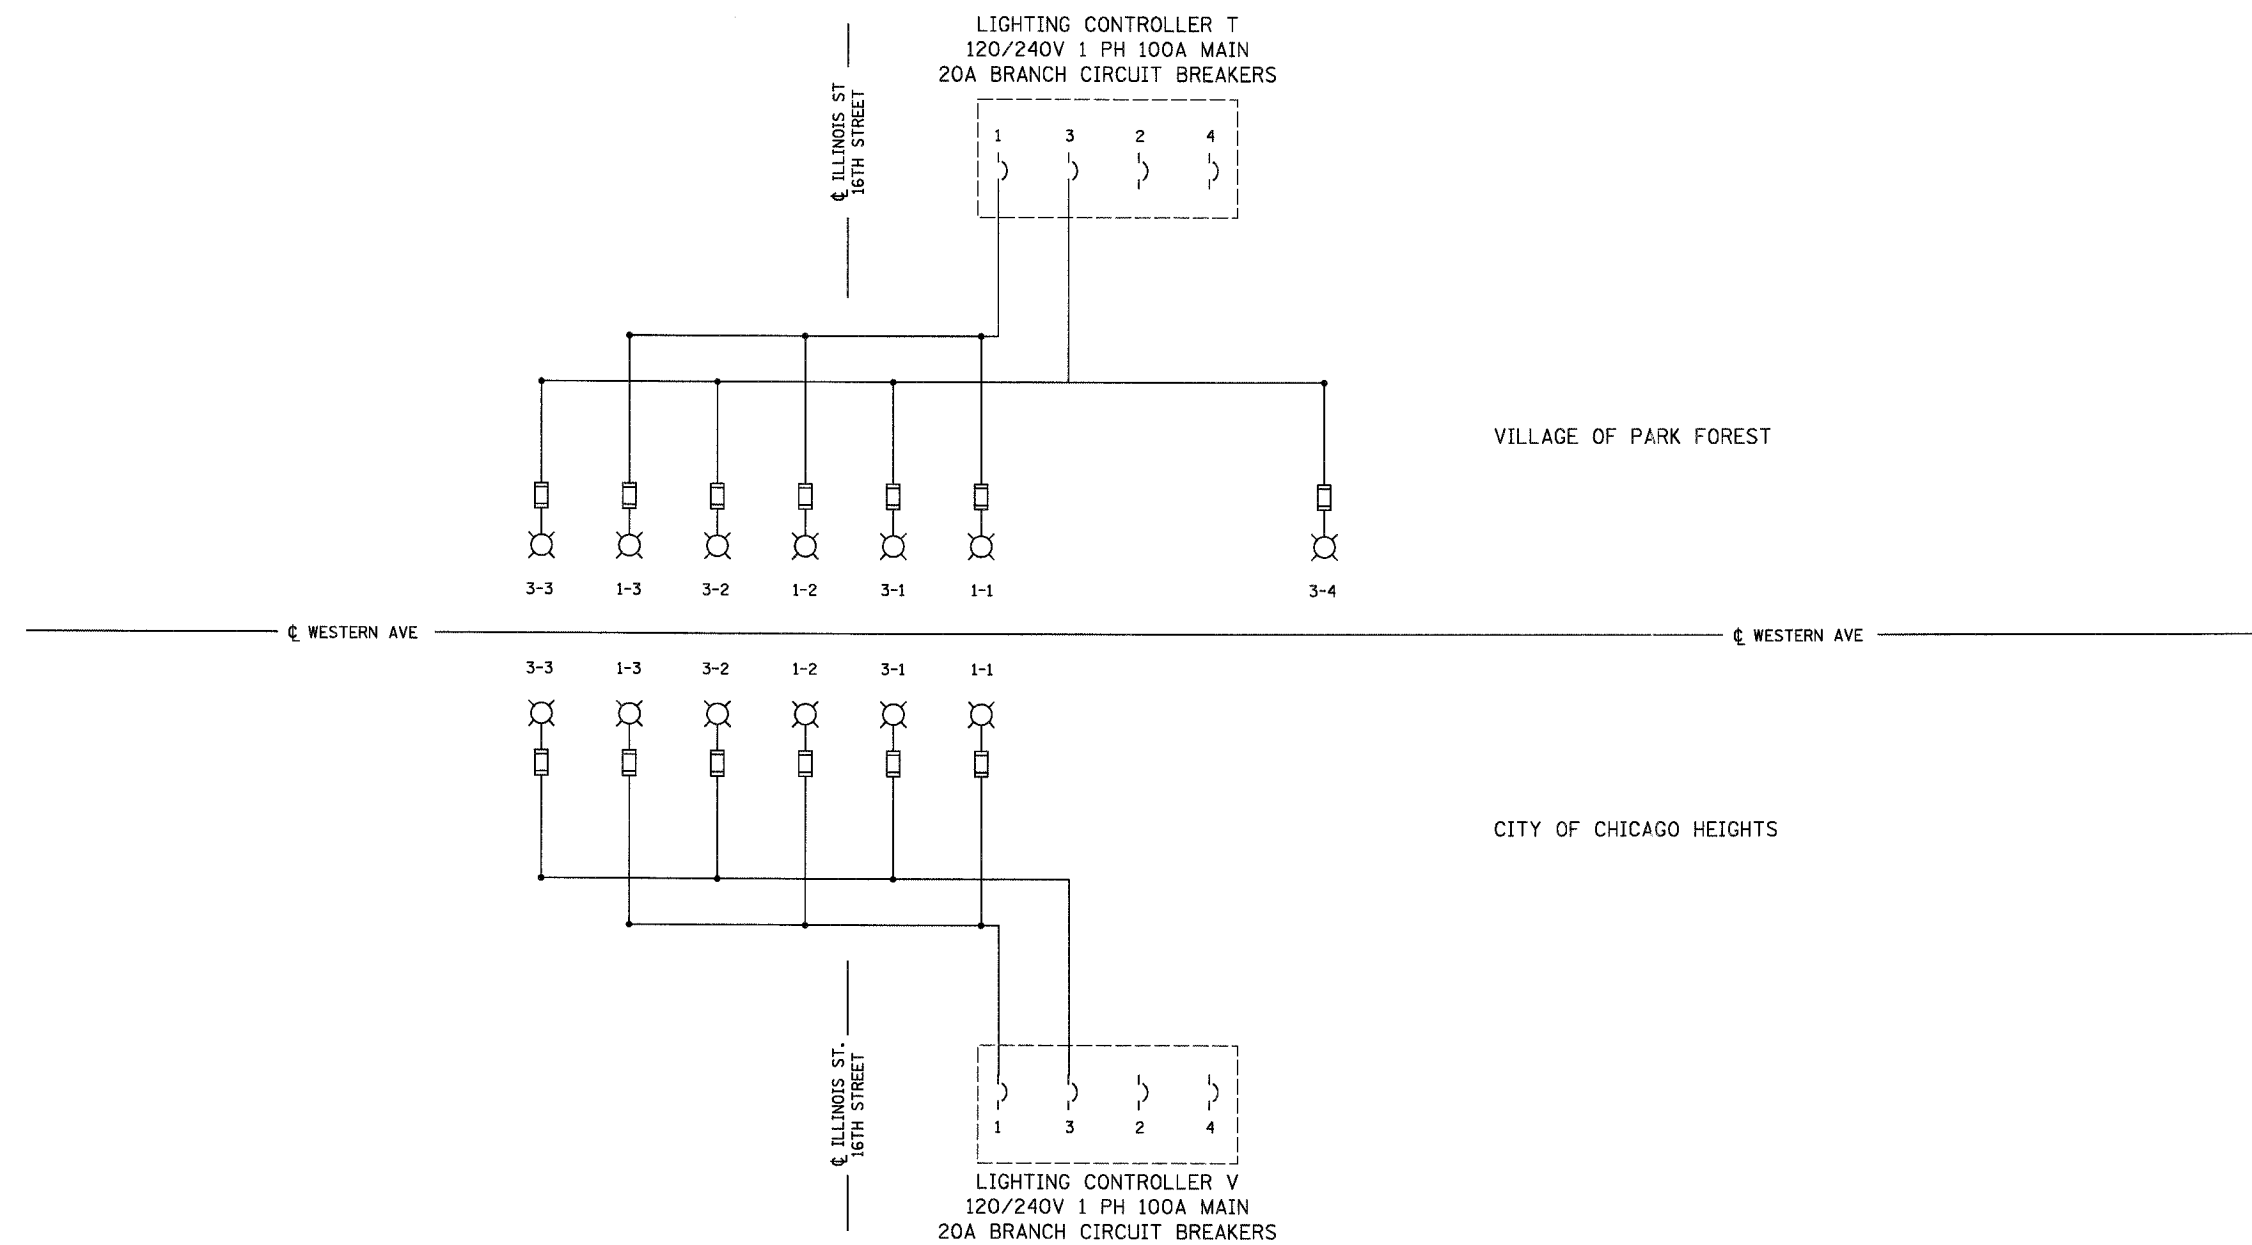

- SINGLE LINE LEGEND**
- LUMINAIRE, 250 W HPS
  - FUSE, 5A UNLESS OTHERWISE INDICATED
  - CIRCUIT BREAKER
  - 3 1/C #6 & 1/C #6 GND
  - CONNECTION

LOAD TABULATION CONTROLLER T	
CIRCUIT	LOAD (WATTS)
T-1	1008
T-2	0
T-3	1344
T-4	0

LOAD TABULATION CONTROLLER V	
CIRCUIT	LOAD (WATTS)
V-1	1008
V-2	0
V-3	1008
V-4	0



REVISIONS	
NAME	DATE

ILLINOIS DEPARTMENT OF TRANSPORTATION

**WESTERN AVE.  
ONE LINE DIAGRAM  
CONTROLLER T & V**

SCALE: N.T.S.      DRAWN BY: A.P.  
DATE: 1/7/07      CHECKED BY: C.A.O.

PLOT DATE = 6/18/2007  
 FILE NAME = #FILE#  
 FILE NO = #FILE#  
 USER NAME = #USER#