


**NOTES**  
 1. REPLACE EXISTING CONTROLLER C3 WITH NEW CONTROLLER RATED 200A, 120/240V, 1Ø, 3W.

SCALE: HOR. 1"=20'



**GENERAL NOTES:**  
 1. SEE SHEET 65 FOR KEYED NOTES  
 2. SEE SHEET 72 FOR CIRCUIT SCHEDULES

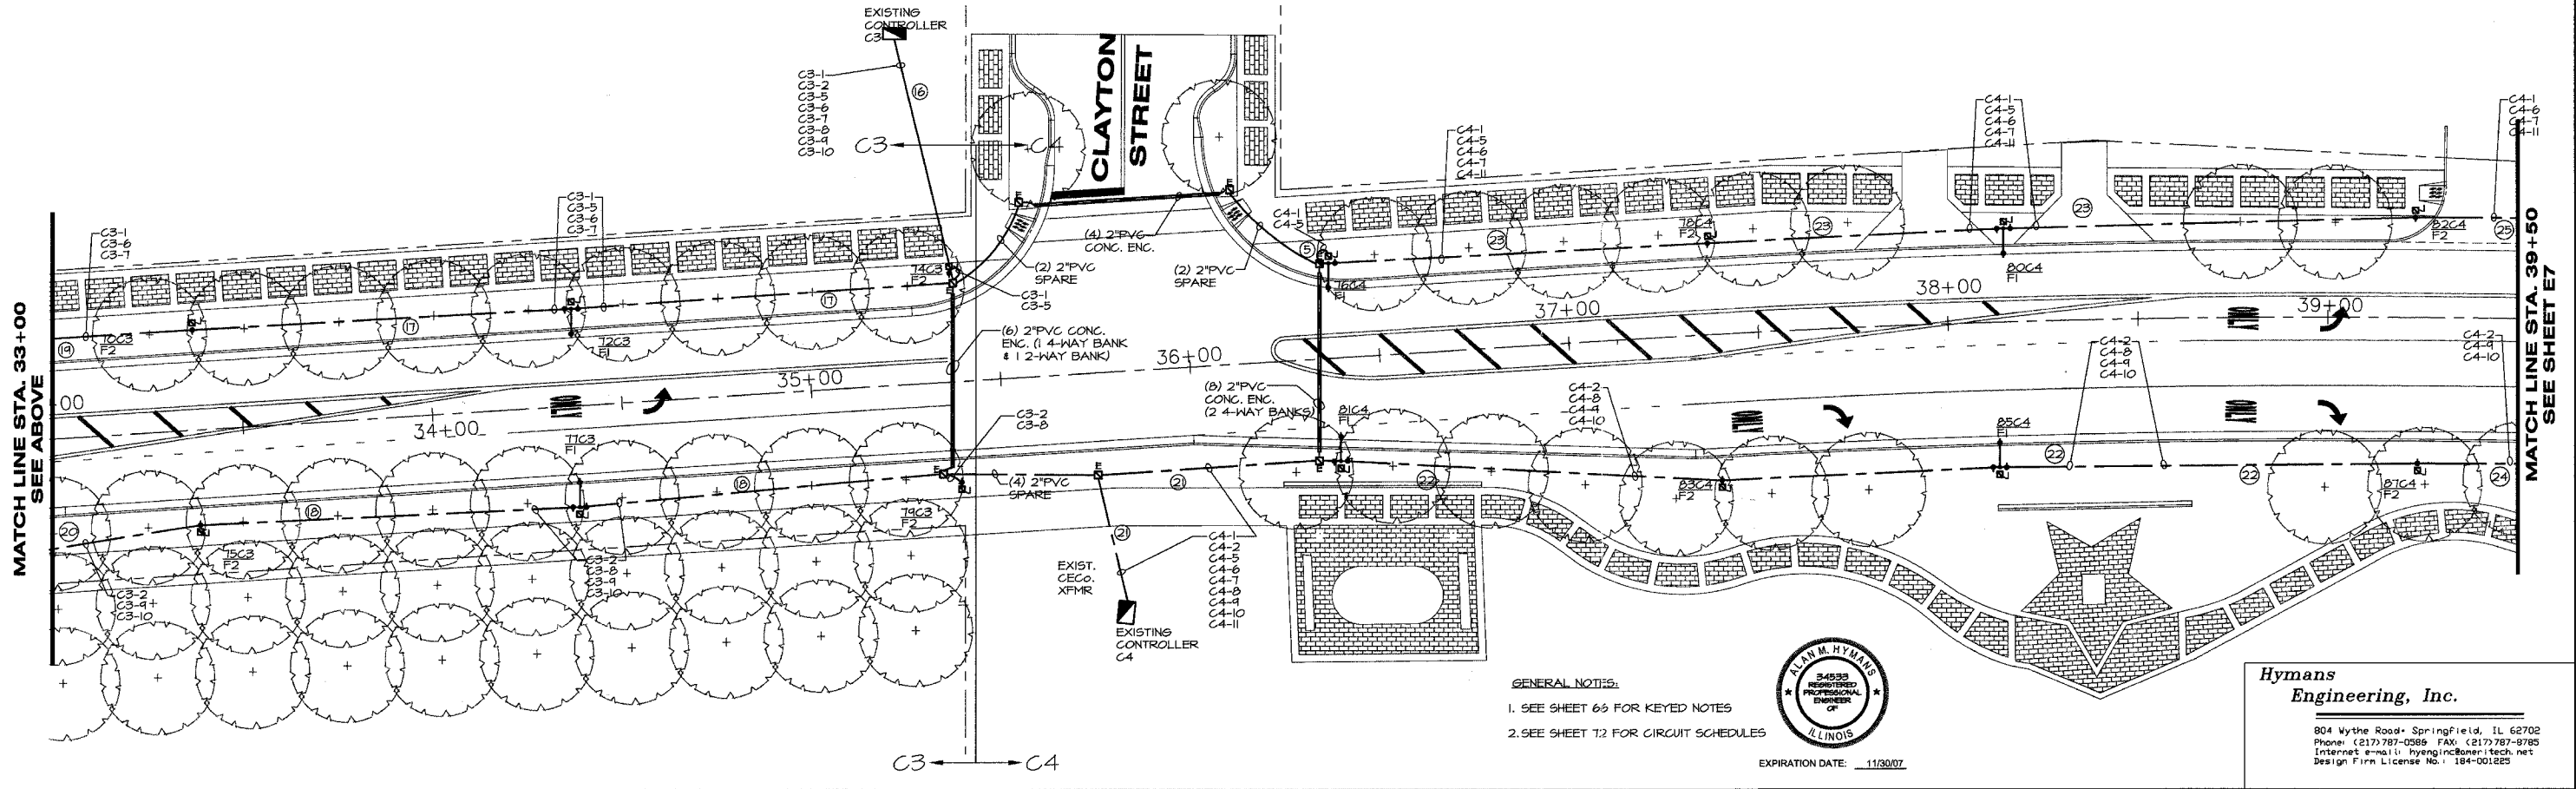

**Hymans Engineering, Inc.**  
 804 Myrtle Road • Springfield, IL 62702  
 Phone: (217) 787-0585 FAX: (217) 787-8785  
 Internet e-mail: hysenginc@ameritech.net  
 Design Firm License No. 184-001225

**SHEET KEY**

--	--	--	--	--	--	--	--	--	--

REVISIONS		
NO.	ITEM	DATE

SCALE: 1" = 20'  
 DRAWN BY: KEH/DEH  
 CHECKED BY: AMH  
 DATE: 3-3-06

**McCLURE ENGINEERING ASSOCIATES, INC.**  
 2728 Grand Ave. Waukegan, IL 60085 Design Firm License: Illinois #184-000816  
 TEL 847-336-7100 FAX 847-336-7155 Copyright 2004 by  
 EMAIL wk@mcclureengineering.com McClure Engineering Associates, Inc.

**LIGHTING PLAN-STA 26+50 TO 39+50**  
**SHERIDAN ROAD IMPROVEMENTS**  
 CITY OF WAUKEGAN JOB NUMBER: 02-28-03-231 LAKE COUNTY, ILLINOIS  
 W:\dwg\K\SHERIDAN-RD\Lighting\LightingPlanE4-E6\_SheridanRd-Light-010106.dwg 3/6/2006 11:34:43 AM CST

SHEET NO. **72** of **122**