


- NOTES:
1. STATIONS AND OFFSETS SHOWN ON THIS SHEET ARE TO THE CENTER OF HANDHOLE AND LIGHT POLE FOUNDATIONS.
 2. COORDINATE INSTALLATION OF UNDERGROUND CONDUIT AND LIGHT FIXTURES WITH ALL EXISTING UNDERGROUND SYSTEMS AND PROPOSED LANDSCAPE FEATURES AND PLANTINGS.
 3. SEE IRRIGATION PLANS FOR UNDERGROUND CONDUIT AND PIPING. COORDINATE INSTALLATION OF UNDERGROUND FACILITIES.
 4. 'F' DESIGNATIONS OF LIGHT FIXTURES SHOWN ON LIGHTING DETAILS SHEET.

ALL KEYED NOTES APPLY TO THIS SHEET ONLY.

- KEYED NOTES:
1. PORTLAND CEMENT CONCRETE 81400100 - HANDHOLE IDOT STANDARD 814001-02. GROUND HANDHOLE PER IDOT STANDARD 873001-02.
 2. 2" CONDUIT, 2*4 AND 1*4 GND FOR CIRCUIT LC4-9.
 3. 2" CONDUIT, 2*6 AND 1*6 GND FOR CIRCUIT LC4-7.
 4. 2" CONDUIT, 2*6 AND 1*6 GND FOR CIRCUIT LC4-10.

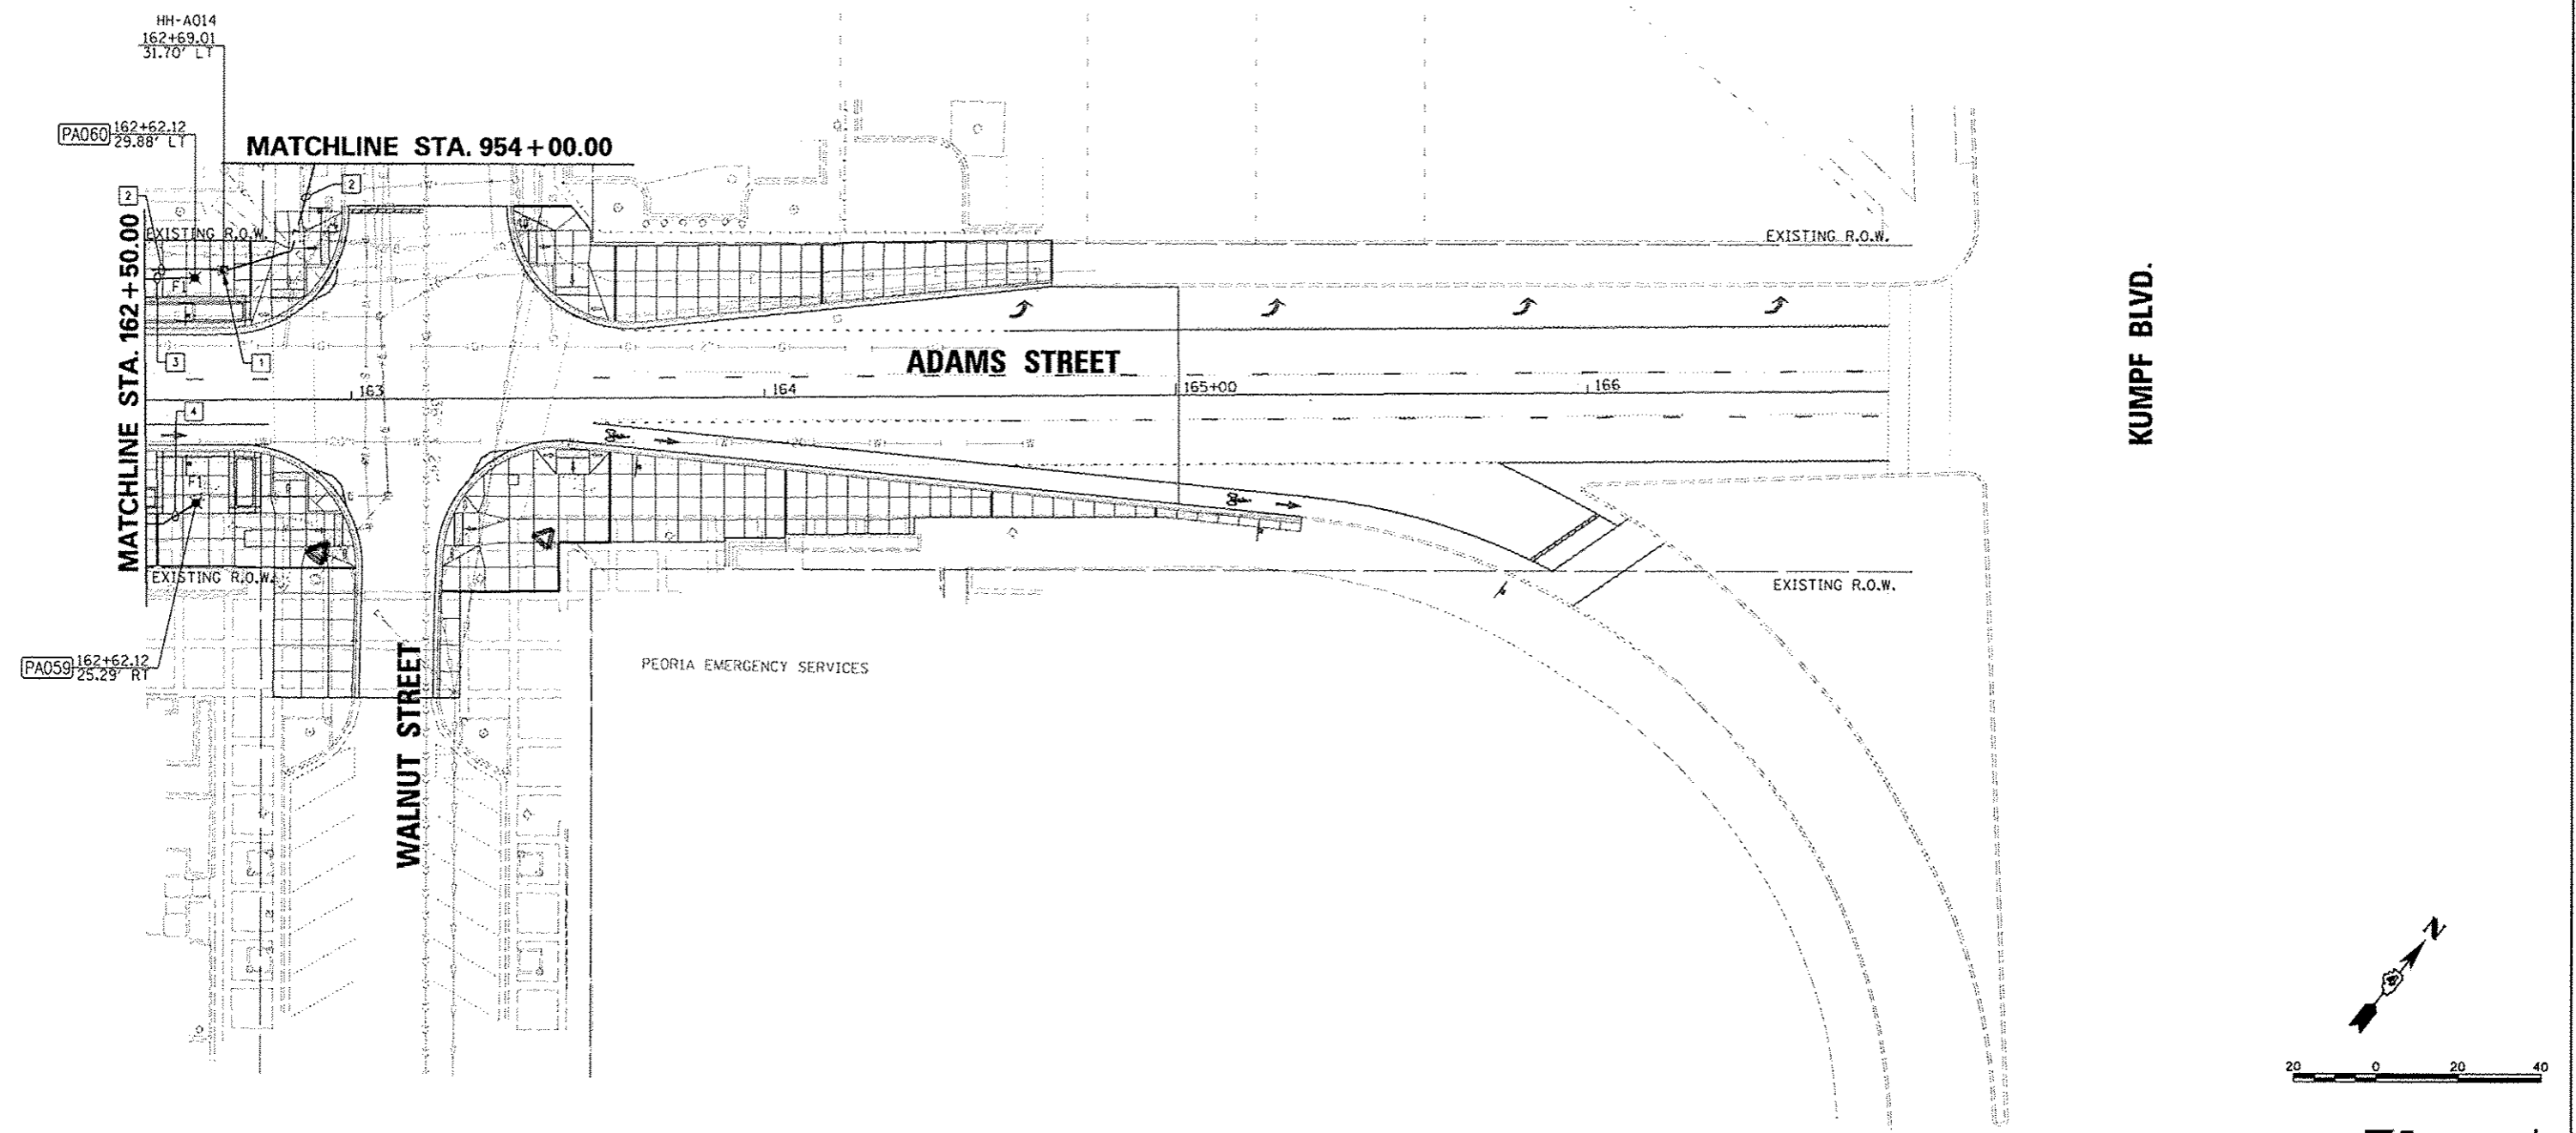

FILE NAME = c:\pwise\work\do_not_delete\dms73318\041	USER NAME = manak01398 RL0155-shr-light024.dgn	DESIGNED - JDE	REVISED -	STATE OF ILLINOIS DEPARTMENT OF TRANSPORTATION	ADAMS STREET LIGHTING PLAN	F.A.U. RTE. 12	SECTION 12-00356-01-PV	COUNTY PEORIA	TOTAL SHEETS 519	SHEET NO. 358		
	PLOT SCALE = 39.9999 1 / in.	DRAWN - TMT	REVISED -			SCALE: 1"=20'	SHEET NO. OF SHEETS	STA. 162+50	TO STA. 166+50	CONTRACT NO. 89626		
	PLOT DATE = 07/23/2012	CHECKED - BMS	REVISED -			ILLINOIS FED. AID PROJECT TIG-50931581						
		DATE - 7/18/12	REVISED -									

Farnsworth GROUP
 7707 N. KNOXVILLE AVE, SUITE 100
 PEORIA, ILLINOIS 61614
 (309) 699-9655 / (309) 699-9620 Fax
 www.fw.com